

Key Plan :

Notes :

1. THIS DRAWING AND DESIGN IS THE PROPERTY OF THE DESIGNERS. NO PORTION MAY BE USED OR REPRODUCED WITHOUT THEIR WRITTEN PERMISSION.
2. THIS DRAWING IS TO BE READ IN CONJUNCTION WITH THE DESIGNERS SPECIFICATIONS AND CONDITIONS OF CONTRACT.
3. ALL DIMENSIONS ARE TO BE READ NOT SCALED.
4. ALL INDICATED LEVELS ARE FINISHED LEVELS UNLESS NOTED OTHERWISE.
5. ALL OUTER DIMENSIONS IN METER & INTERNAL DIMENSIONS IN MM.
6. PANEL LOCATION IS TENTATIVE IT MAYBE BE PLACE APPROPRIATE LOCATION AT THE TIME OF CONSTRUCTION.

PROJECT TITLE
PROPOSED CONSTRUCTION OF MULTI STOREY BUILDING FOR SBI BANK AT KALYANPUR NEAR CIRCUIT HOUSE, DEOGARH

CLIENT :-
 STATE BANK OF INDIA PATNA

ARCHITECT:-
 D K & ASSOCIATES
(ARCHITECTS & INTERIOR DESIGNERS)
A-385, DEFENCE COLONY, NEW DELHI - 110024.
Tel: 91-11-24333312/918 Email : dps200@gmail.com

DRAWING STAGE:-
TENDER DRAWING


MEP - CONSULTANT
 AD CONSULTANTS
C-419, 4th Floor Vipul Plaza | Email: info@adconsultants.co.in
Sector-31 Faridabad-121002 | Website: www.adconsultants.co.in
HARYANA INDIA | Ph: +91-9811-662885

Drawn: **ATUL PANDEY**
Checked: **MOHAN SHARMA**

DRAWING TITLE:-
**FIRST FLOOR PLAN
LIGHTING LAYOUT**

SCALE A1 SHEET:- A2 SHEET:- A3 SHEET:-	ARCH./ENGR.: DRAWN KAMLESH CHECKED GURPREET	DATE 04-03-2025 APPROVED	REV. R1
---	---	---------------------------------------	-----------------------

DRAWING NO.
DKA/SBI/TD/EL/FIRST-01

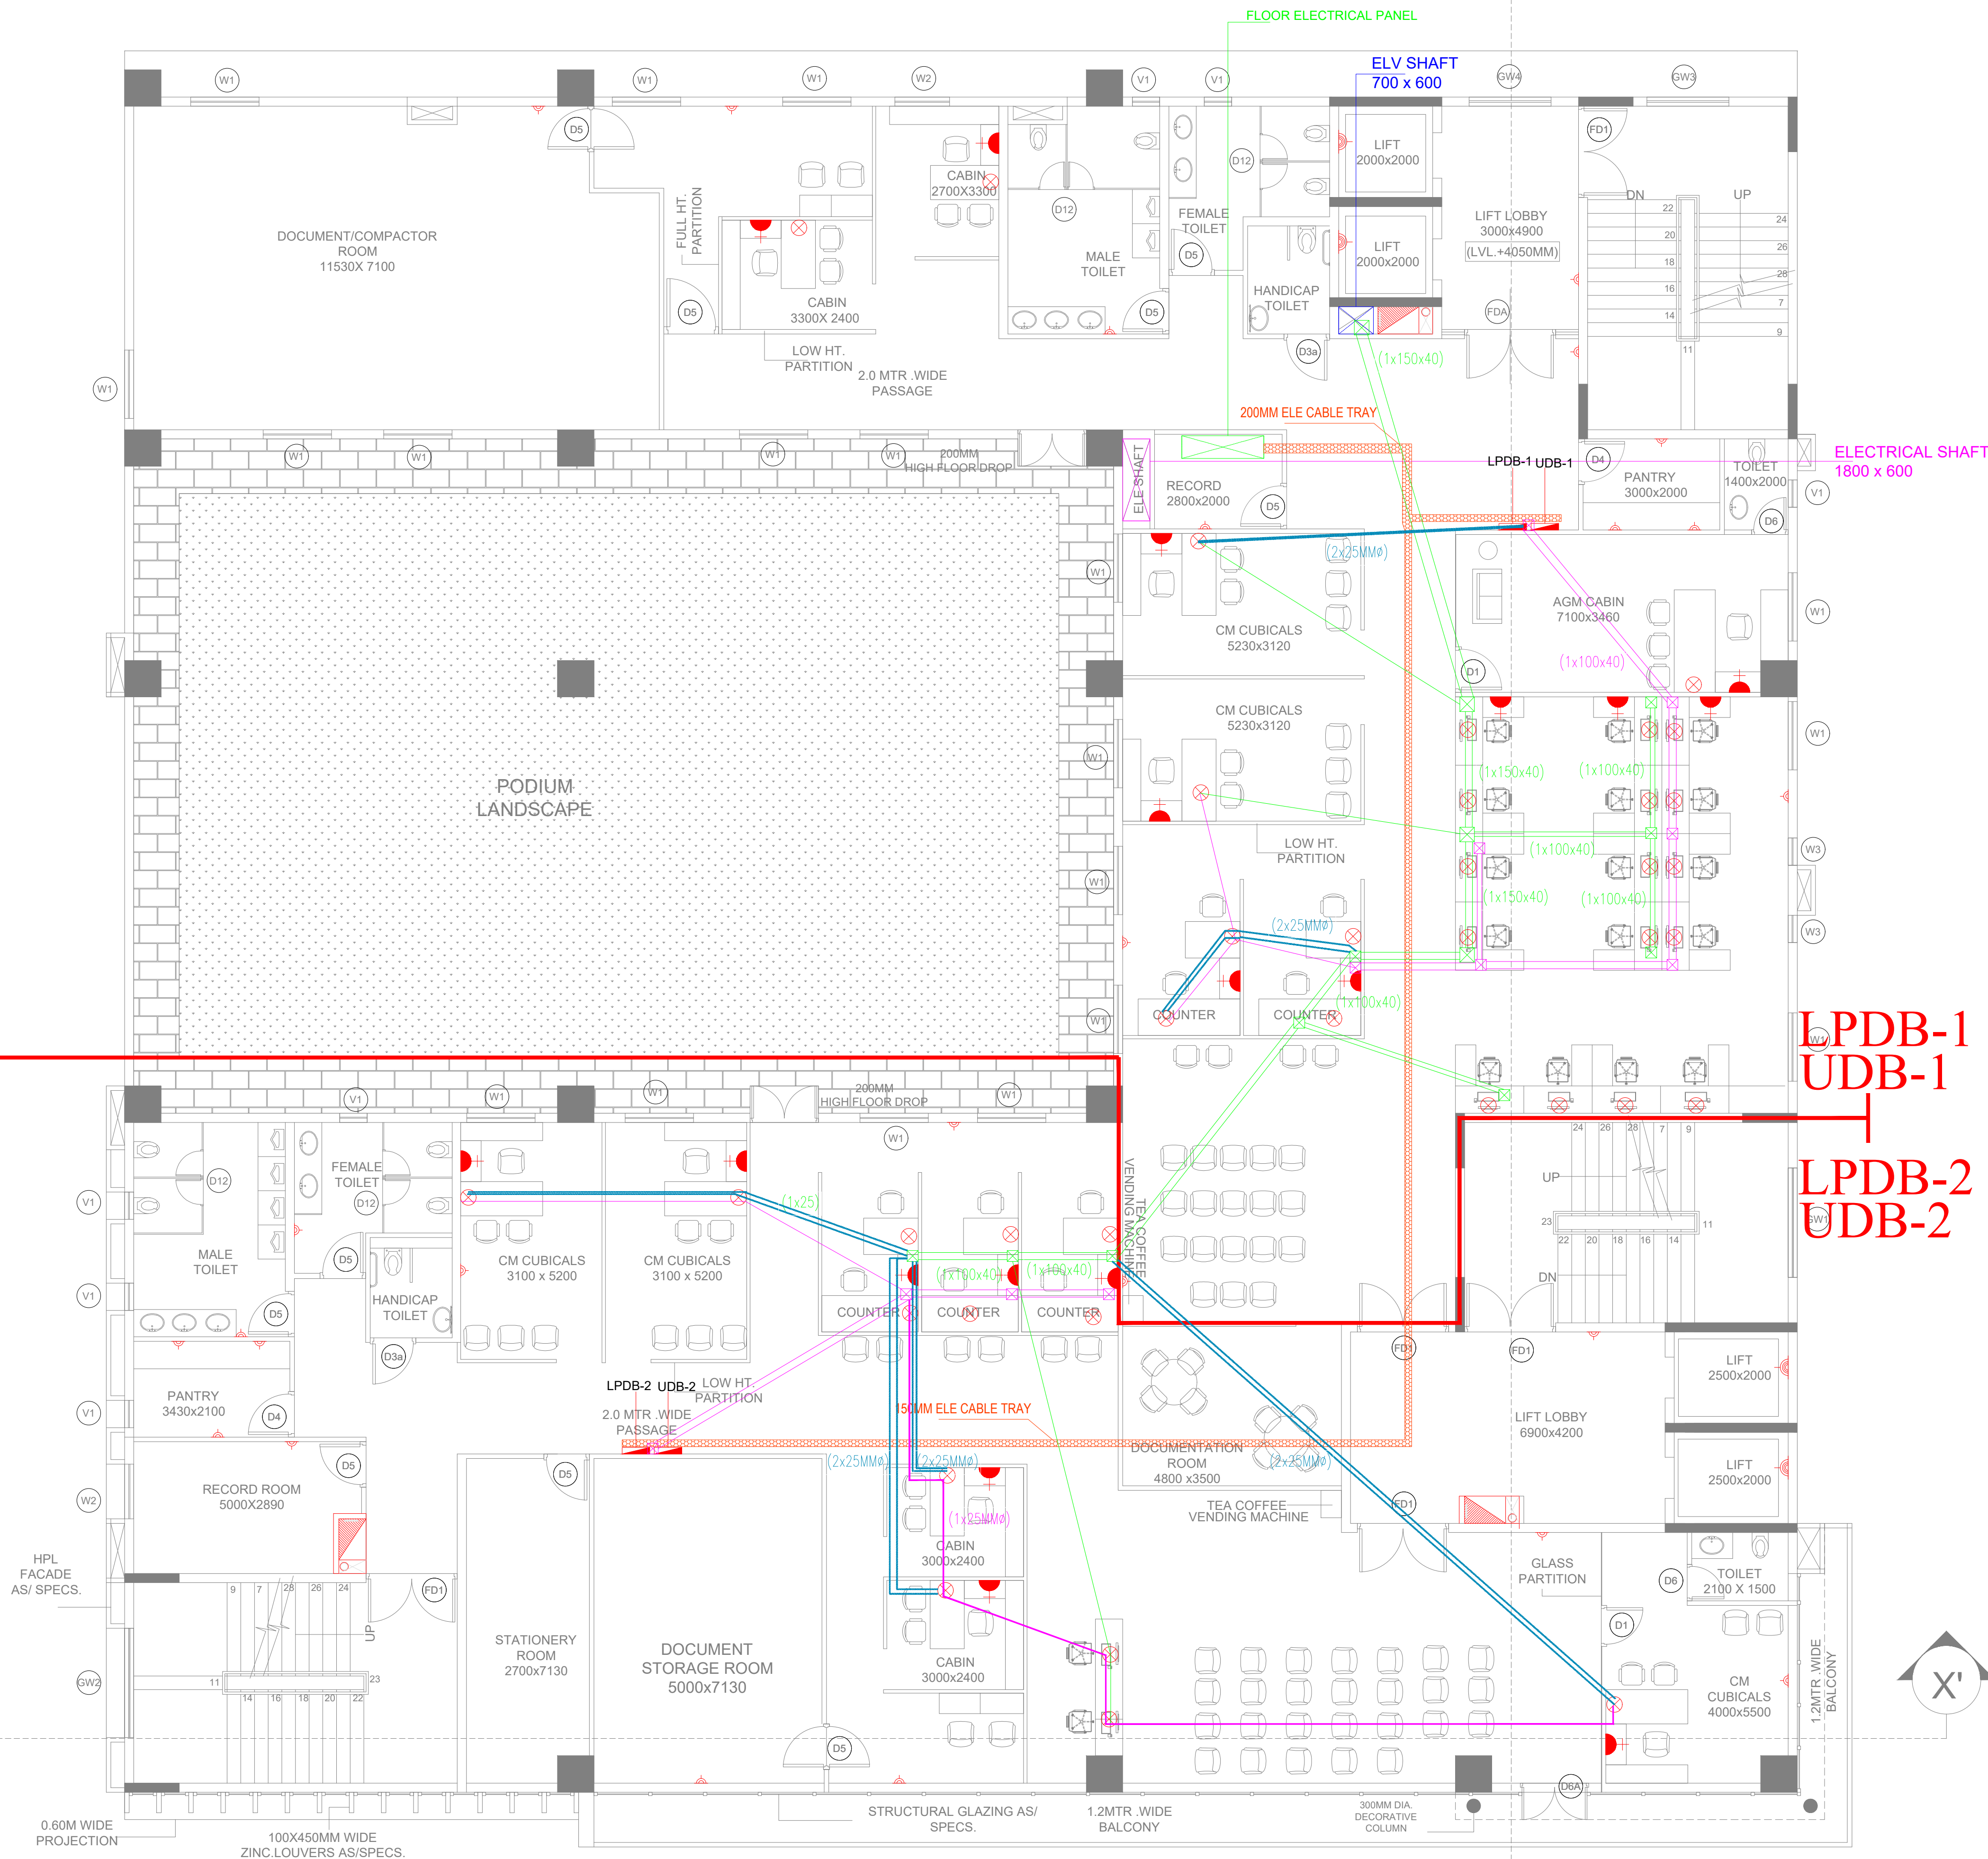

Key Plan :

Notes :

1. THIS DRAWING AND DESIGN IS THE PROPERTY OF THE DESIGNERS. NO PORTION MAY BE USED OR REPRODUCED WITHOUT THEIR WRITTEN PERMISSION.
2. THIS DRAWING IS TO BE READ IN CONJUNCTION WITH THE DESIGNERS SPECIFICATIONS AND CONDITIONS OF CONTRACT.
3. ALL DIMENSIONS ARE TO BE READ NOT SCALED.
4. ALL INDICATED LEVELS ARE FINISHED LEVELS UNLESS NOTED OTHERWISE.
5. ALL OUTER DIMENSIONS IN METER & INTERNAL DIMENSIONS IN MM.
6. PANEL LOCATION IS TENTATIVE IT MAYBE BE PLACE APPROPRIATE LOCATION AT THE TIME OF CONSTRUCTION.



PROJECT TITLE

PROPOSED CONSTRUCTION OF MULTI STOREY BUILDING FOR SBI BANK AT KALYANPUR NEAR CIRCUIT HOUSE, DEOGARH

CLIENT :-

STATE BANK OF INDIA PATNA

ARCHITECT:-

D K & ASSOCIATES
(ARCHITECTS & INTERIOR DESIGNERS)
A-385, DEFENCE COLONY, NEW DELHI - 110024
Tel: 91-11-24333312/918 Email : dps200@gmail.com

DRAWING STAGE:-

TENDER DRAWING

MEP - CONSULTANT


AD CONSULTANTS
C-419, 4th Floor Vipul Plaza | Email: info@adconsultants.co.in
Sector-31 Faridabad-121002 | Website: www.adconsultants.co.in
HARYANA INDIA | Ph: +91-9811-662885

Drawn: **ATUL PANDEY** Checked: **MOHAN SHARMA**

DRAWING TITLE:-

FIRST FLOOR PLAN
POWER LAYOUT

SCALE	ARCH./ENGR.:	DATE	REV.
A1 SHEET:- A2 SHEET:- A3 SHEET:-	DRAWN KAMLESH CHECKED GURPREET	04-03-2025 APPROVED	R1
DRAWING NO. DKA/SBI/TD/EL/FIRST-02			

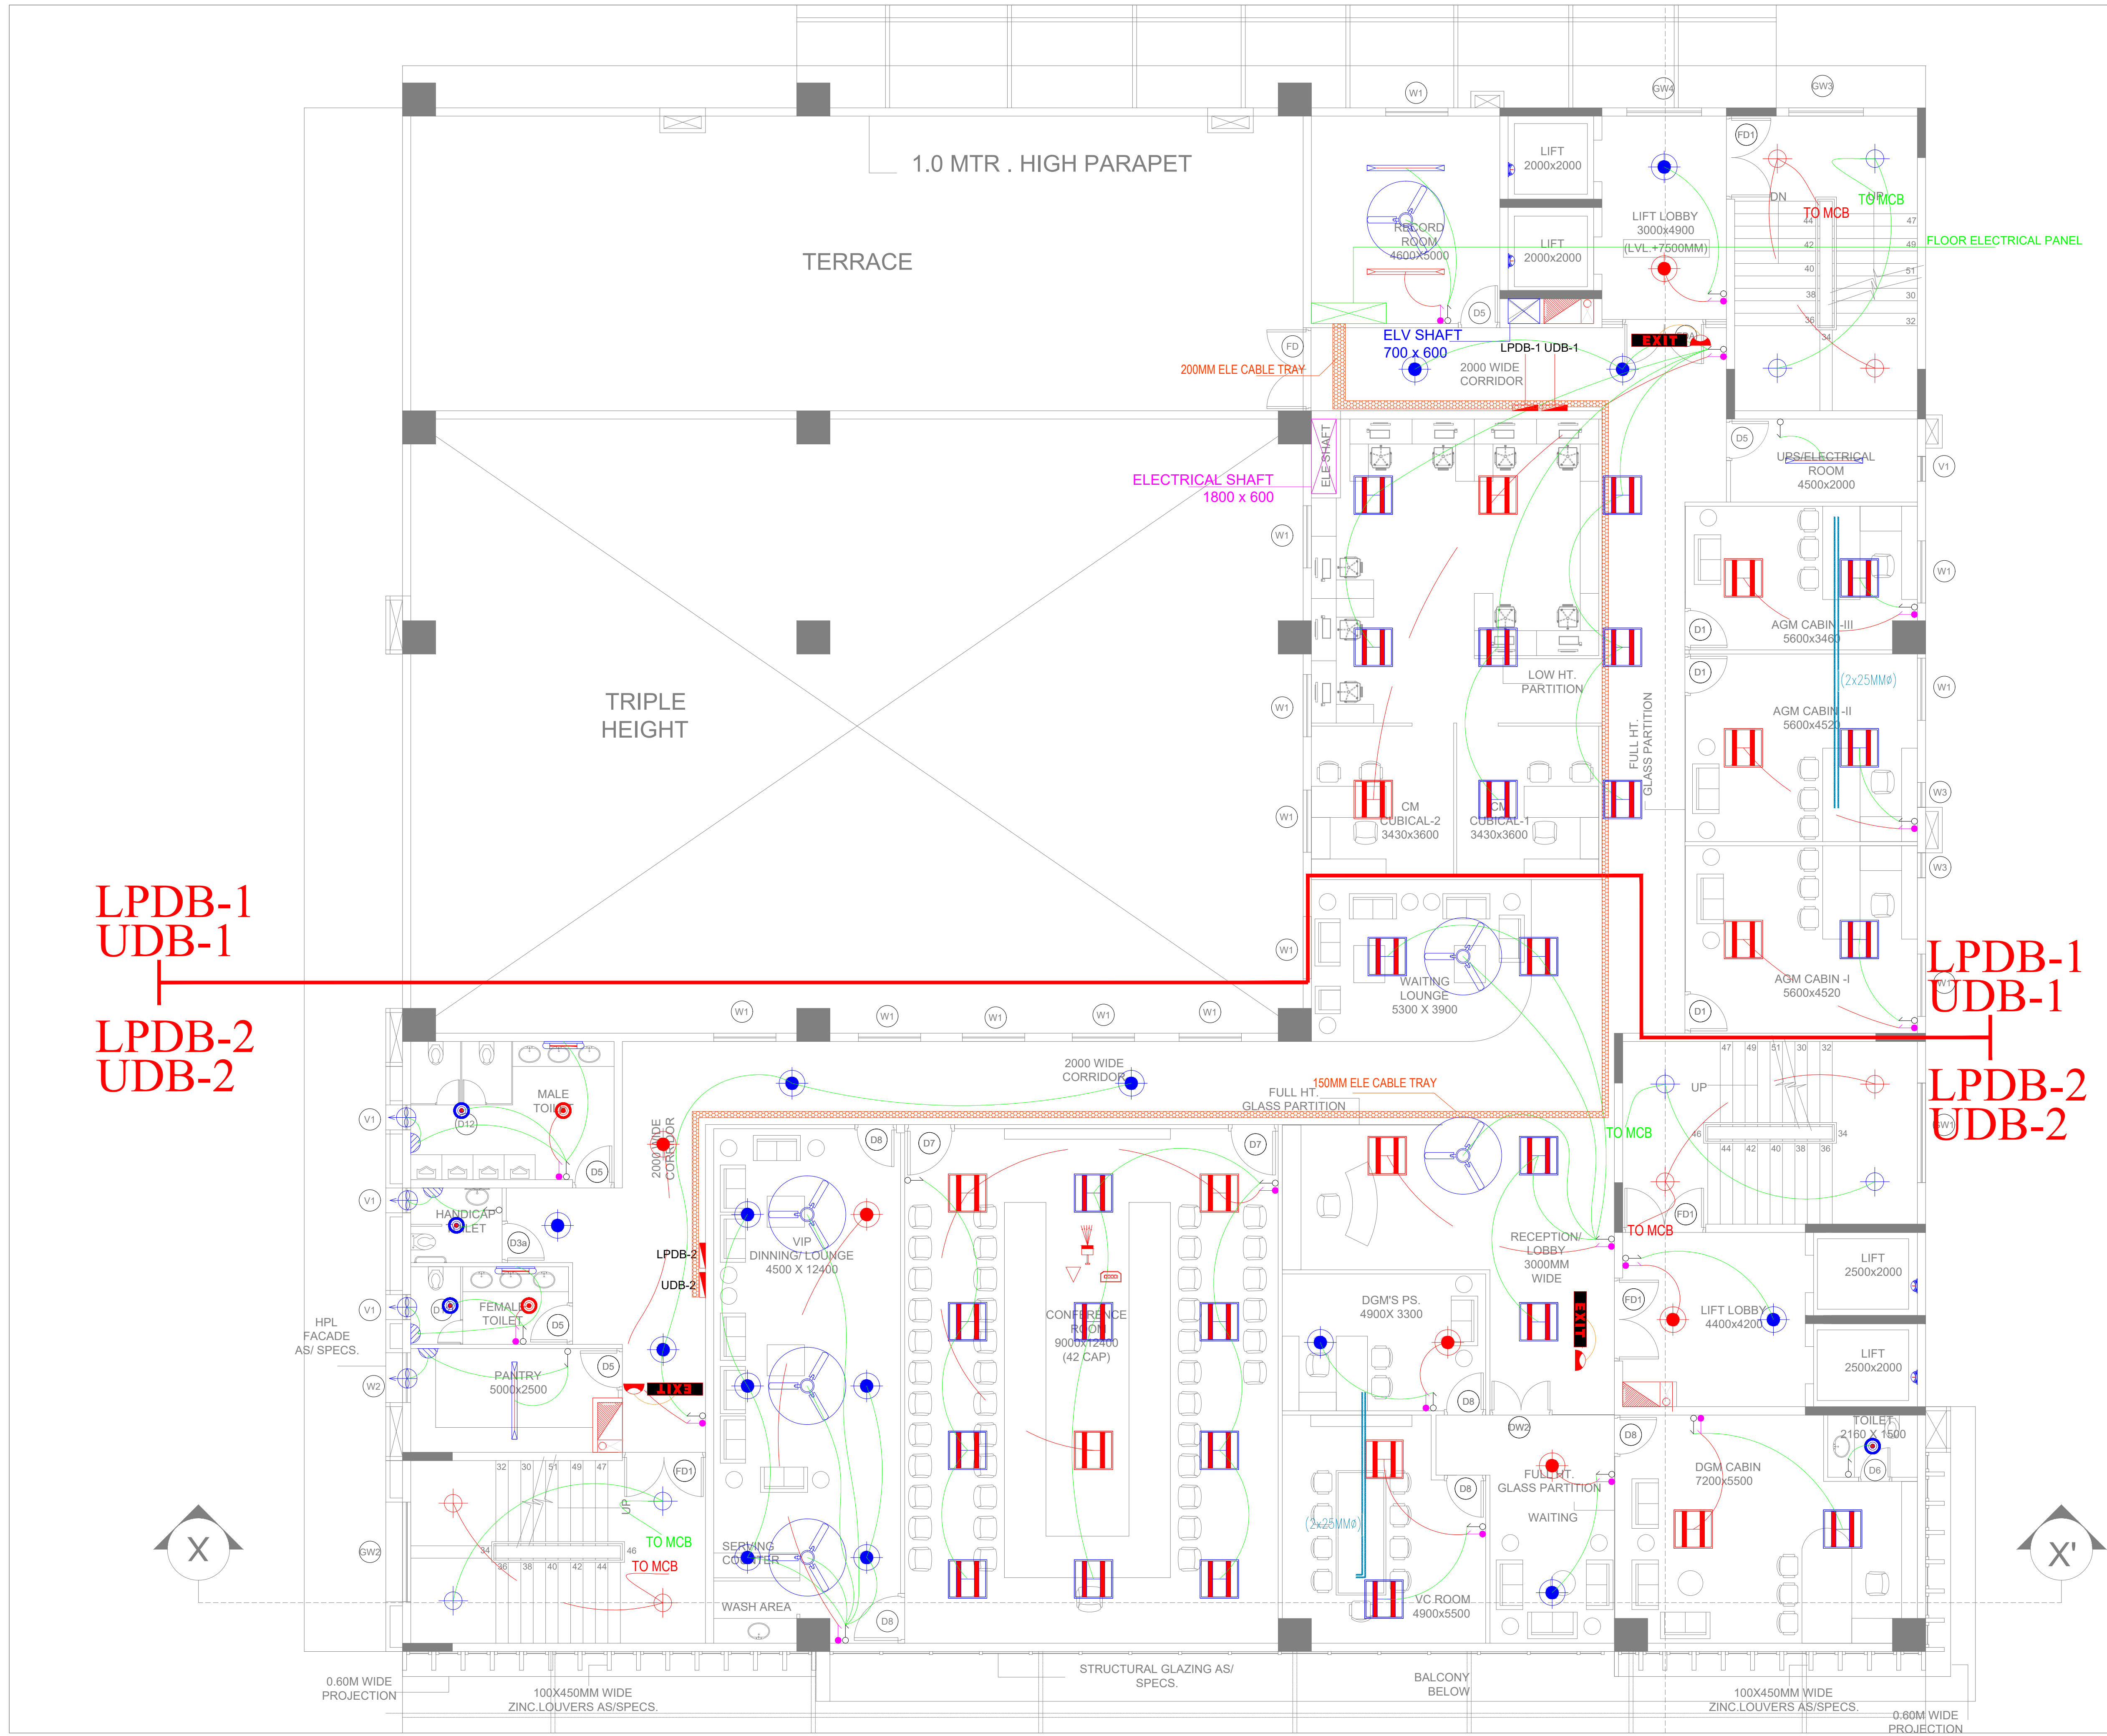

Key Plan :

Notes :

1. THIS DRAWING AND DESIGN IS THE PROPERTY OF THE DESIGNERS. NO PORTION MAY BE USED OR REPRODUCED WITHOUT THEIR WRITTEN PERMISSION.
2. THIS DRAWING IS TO BE READ IN CONJUNCTION WITH THE DESIGNERS SPECIFICATIONS AND CONDITIONS OF CONTRACT.
3. ALL DIMENSIONS ARE TO BE READ NOT SCALED.
4. ALL INDICATED LEVELS ARE FINISHED LEVELS UNLESS NOTED OTHERWISE.
5. ALL OUTER DIMENSIONS IN METER & INTERNAL DIMENSIONS IN MM.
6. PANEL LOCATION IS TENTATIVE IT MAYBE BE PLACE APPROPRIATE LOCATION AT THE TIME OF CONSTRUCTION.



PROJECT TITLE

PROPOSED CONSTRUCTION OF MULTI STOREY BUILDING FOR SBI BANK AT KALYANPUR NEAR CIRCUIT HOUSE, DEOGARH

CLIENT :-

SBI STATE BANK OF INDIA PATNA

ARCHITECT:-

D K & ASSOCIATES
(ARCHITECTS & INTERIOR DESIGNERS)
A-385, DEFENCE COLONY, NEW DELHI - 110024
Tel: 91-11-24333312/918 Email : dks200@gmail.com

DRAWING STAGE:-

TENDER DRAWING

MEP - CONSULTANT


AD CONSULTANTS
C-419, 4th Floor Vipul Plaza | Email: info@adconsultants.co.in
Sector-31 Faridabad-121002 | Website: www.adconsultants.co.in
HARYANA INDIA | Ph: +91-9811-662885

Drawn: **ATUL PANDEY** Checked: **MOHAN SHARMA**

DRAWING TITLE:-

**SECOND FLOOR PLAN
LIGHTING LAYOUT**

SCALE	ARCH./ENGR.:	DATE	REV.
A1 SHEET:- A2 SHEET:- A3 SHEET:-	DRAWN KAMLESH CHECKED GURPREET	04-03-2025 APPROVED	R1
DRAWING NO. DKA/SBI/TD/EL/SECOND-01			NORTH

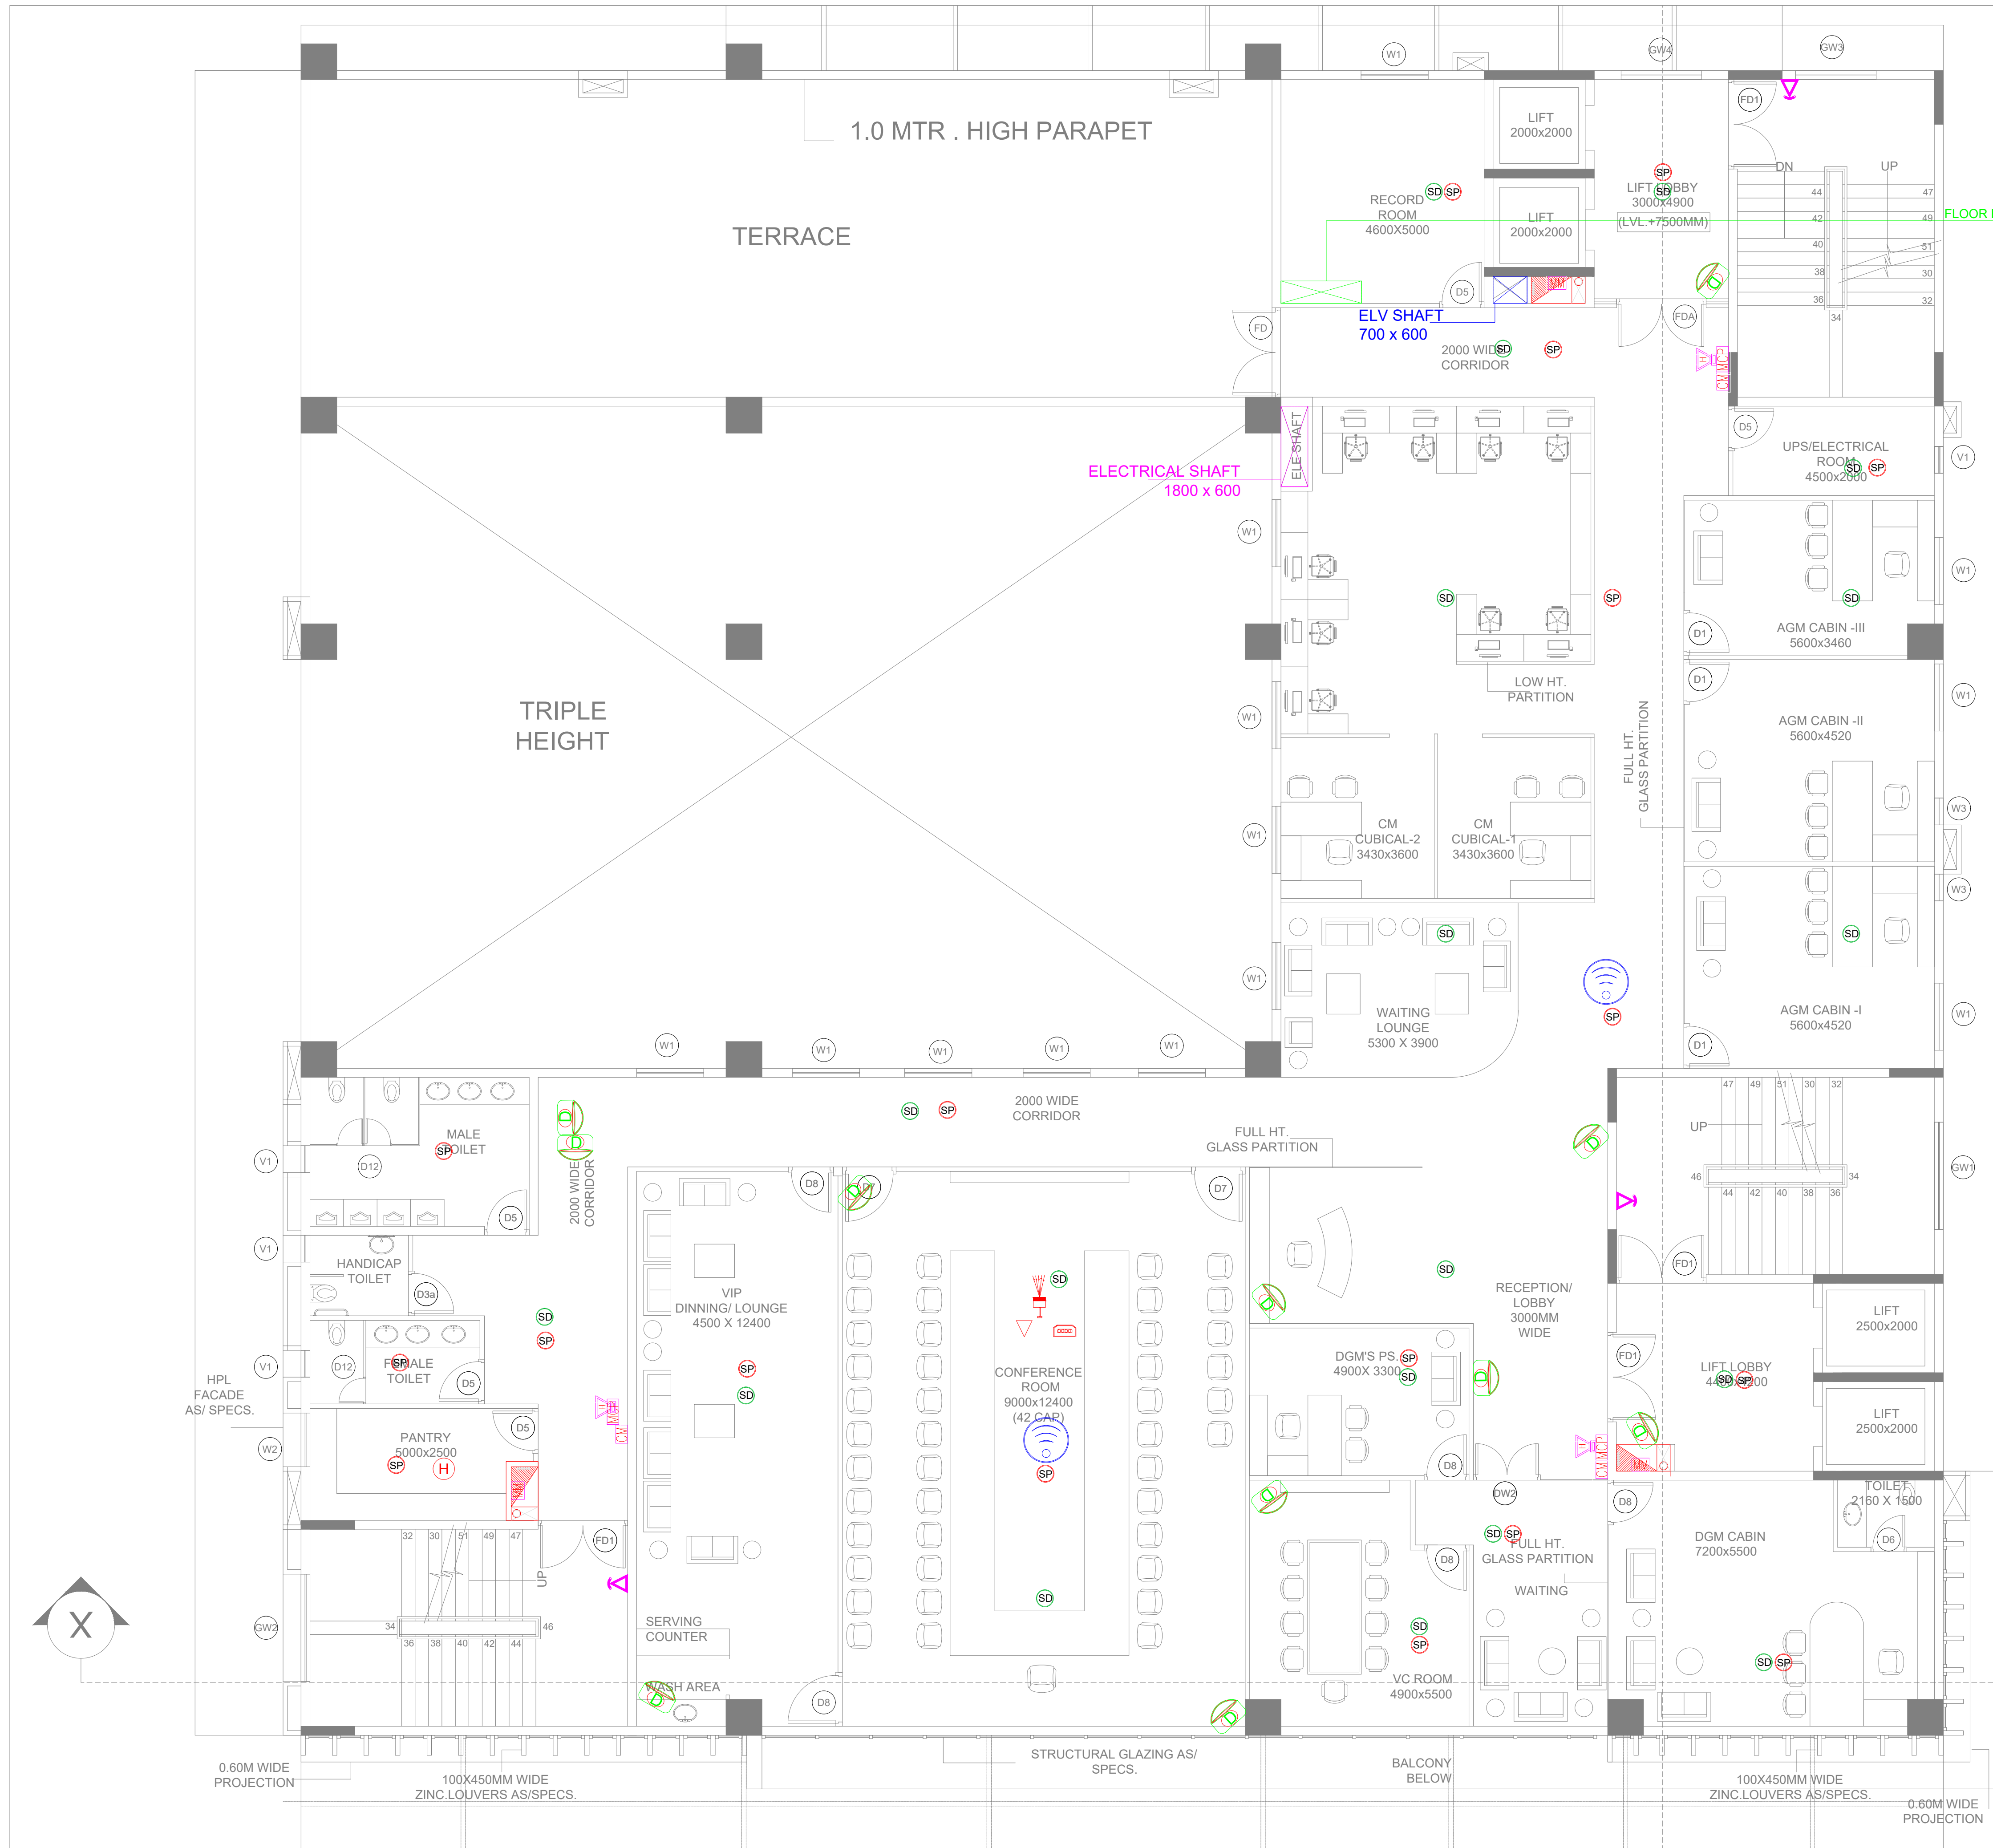

Key Plan :

Notes :

1. THIS DRAWING AND DESIGN IS THE PROPERTY OF THE DESIGNERS. NO PORTION MAY BE USED OR REPRODUCED WITHOUT THEIR WRITTEN PERMISSION.
2. THIS DRAWING IS TO BE READ IN CONJUNCTION WITH THE DESIGNERS SPECIFICATIONS AND CONDITIONS OF CONTRACT.
3. ALL DIMENSIONS ARE TO BE READ NOT SCALED.
4. ALL INDICATED LEVELS ARE FINISHED LEVELS UNLESS NOTED OTHERWISE.
5. ALL OUTER DIMENSIONS IN METER & INTERNAL DIMENSIONS IN MM.
6. PANEL LOCATION IS TENTATIVE IT MAYBE BE PLACE APPROPRIATE LOCATION AT THE TIME OF CONSTRUCTION.



PROJECT TITLE

PROPOSED CONSTRUCTION OF MULTI STOREY BUILDING FOR SBI BANK AT KALYANPUR NEAR CIRCUIT HOUSE, DEOGARH

CLIENT :-

 STATE BANK OF INDIA PATNA

ARCHITECT:-

 **D K & ASSOCIATES**
(ARCHITECTS & INTERIOR DESIGNERS)
A-385, DEFENCE COLONY, NEW DELHI - 110024.
Tel: 91-11-24333312/918 Email : dps200@gmail.com

DRAWING STAGE:-

TENDER DRAWING

MEP - CONSULTANT

 **AD CONSULTANTS**
C-419, 4th Floor Vipul Plaza | Email: info@adconsultants.co.in
Sector-31 Faridabad-121002 | website: www.adconsultants.co.in
HARYANA INDIA Ph: +91-9811-662885

drawn: ATUL PANDEY

checked: MOHAN SHARMA

DRAWING TITLE:-

**SECOND FLOOR PLAN
FIRE ALARM _ PA _ WIFI &
CCTV LAYOUT**

SCALE	ARCH./ENGR.:	DATE	REV.
A1 SHEET:- A2 SHEET:- A3 SHEET:-	DRAWN: KAMLESH CHECKED: GURPREET	04-03-2025 APPROVED	R1

DRAWING NO.
DKA/SBI/TD/EL/SECOND-03

