


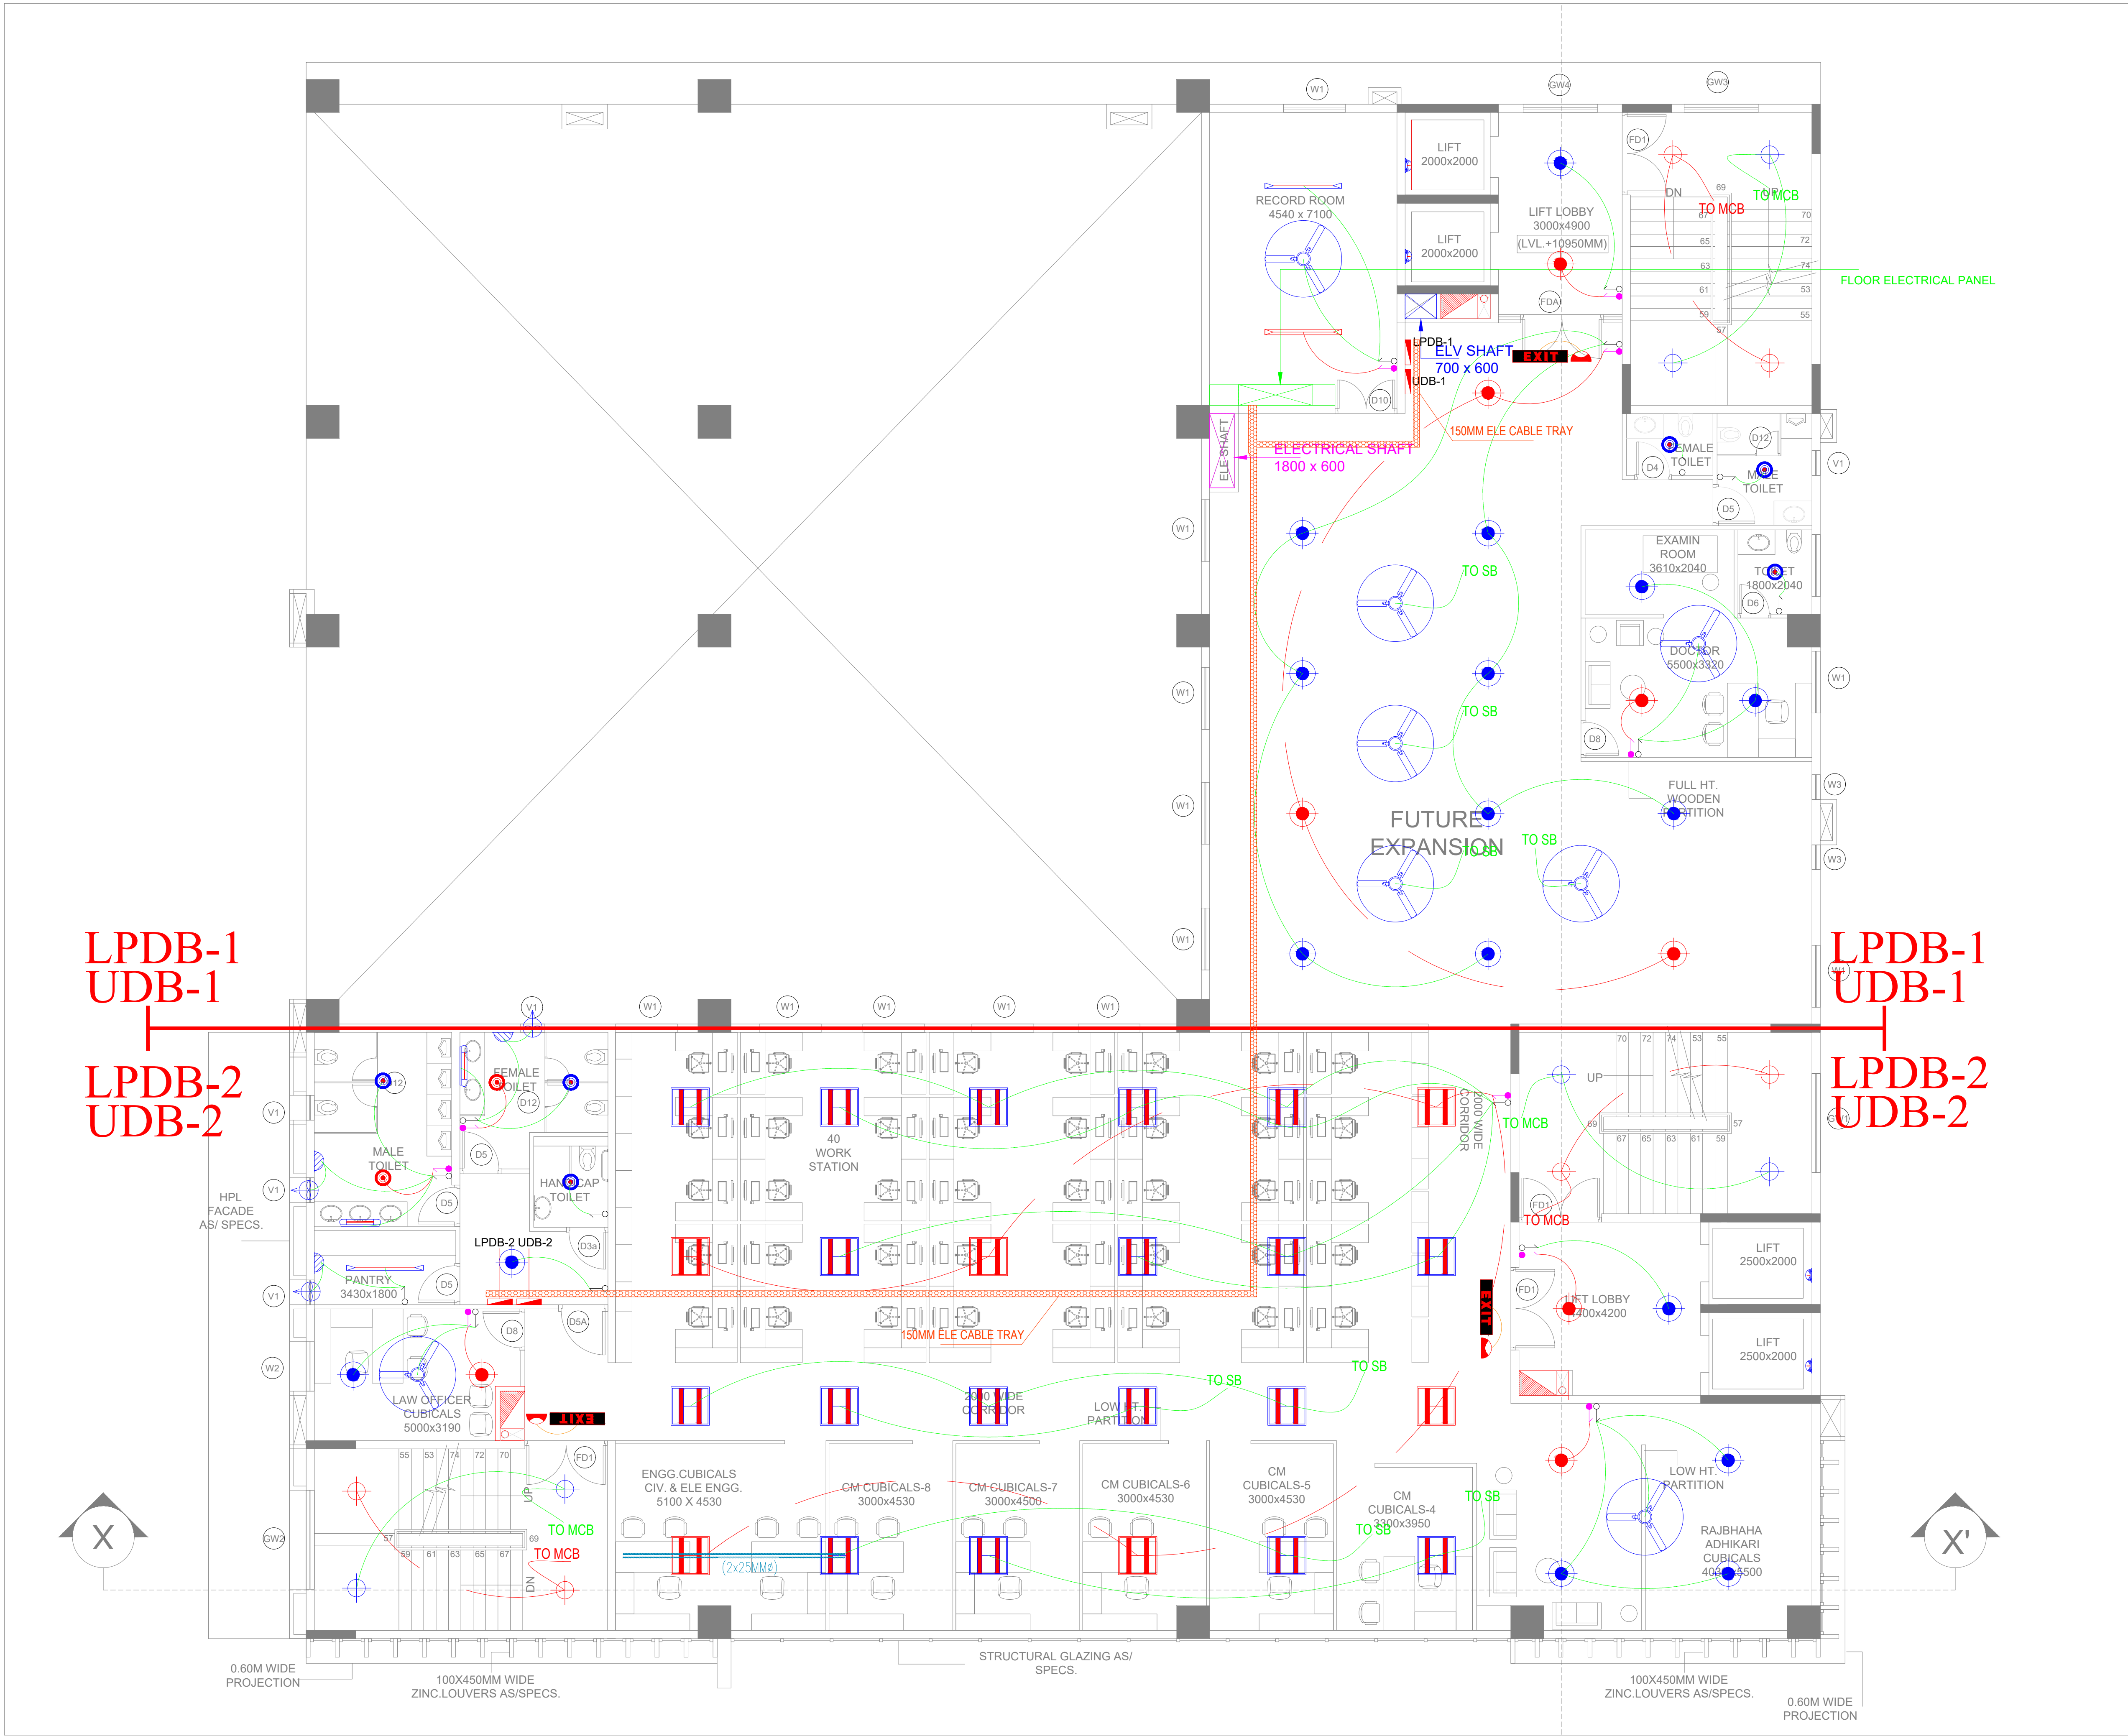

Key Plan :

Notes :

1. THIS DRAWING AND DESIGN IS THE PROPERTY OF THE DESIGNERS. NO PORTION MAY BE USED OR REPRODUCED WITHOUT THEIR WRITTEN PERMISSION.
2. THIS DRAWING IS TO BE READ IN CONJUNCTION WITH THE DESIGNERS SPECIFICATIONS AND CONDITIONS OF CONTRACT.
3. ALL DIMENSIONS ARE TO BE READ NOT SCALED.
4. ALL INDICATED LEVELS ARE FINISHED LEVELS UNLESS NOTED OTHERWISE.
5. ALL OUTER DIMENSIONS IN METER & INTERNAL DIMENSIONS IN MM.
6. PANEL LOCATION IS TENTATIVE IT MAYBE BE PLACE APPROPRIATE LOCATION AT THE TIME OF CONSTRUCTION.



PROJECT TITLE

PROPOSED CONSTRUCTION OF MULTI STOREY BUILDING FOR SBI BANK AT KALYANPUR NEAR CIRCUIT HOUSE, DEOGARH

CLIENT :-

STATE BANK OF INDIA PATNA

ARCHITECT:-

**D K & ASSOCIATES**  
(ARCHITECTS & INTERIOR DESIGNERS)  
A-385, DEFENCE COLONY, NEW DELHI - 110024  
Tel: 91-11-24333312/918 Email : dps200@gmail.com

DRAWING STAGE:-

TENDER DRAWING

MEP - CONSULTANT


**AD CONSULTANTS**  
C-419, 4th Floor Vipul Plaza | Email: info@adconsultants.co.in  
Sector-31 Faridabad-121002 | website: www.adconsultants.co.in  
HARYANA INDIA | Ph: +91-9811-662885

Drawn: **ATUL PANDEY** Checked: **MOHAN SHARMA**

DRAWING TITLE:-

THIRD FLOOR PLAN  
LIGHTING LAYOUT

| SCALE                                  | ARCH./ENGR.:                                          | DATE                   | REV. |
|----------------------------------------|-------------------------------------------------------|------------------------|------|
| A1 SHEET:-<br>A2 SHEET:-<br>A3 SHEET:- | DRAWN<br><b>KAMLESH</b><br>CHECKED<br><b>GURPREET</b> | 04-03-2025<br>APPROVED | R1   |
| DRAWING NO.<br>DKA/SBI/TD/EL/THIRD-01  |                                                       |                        |      |

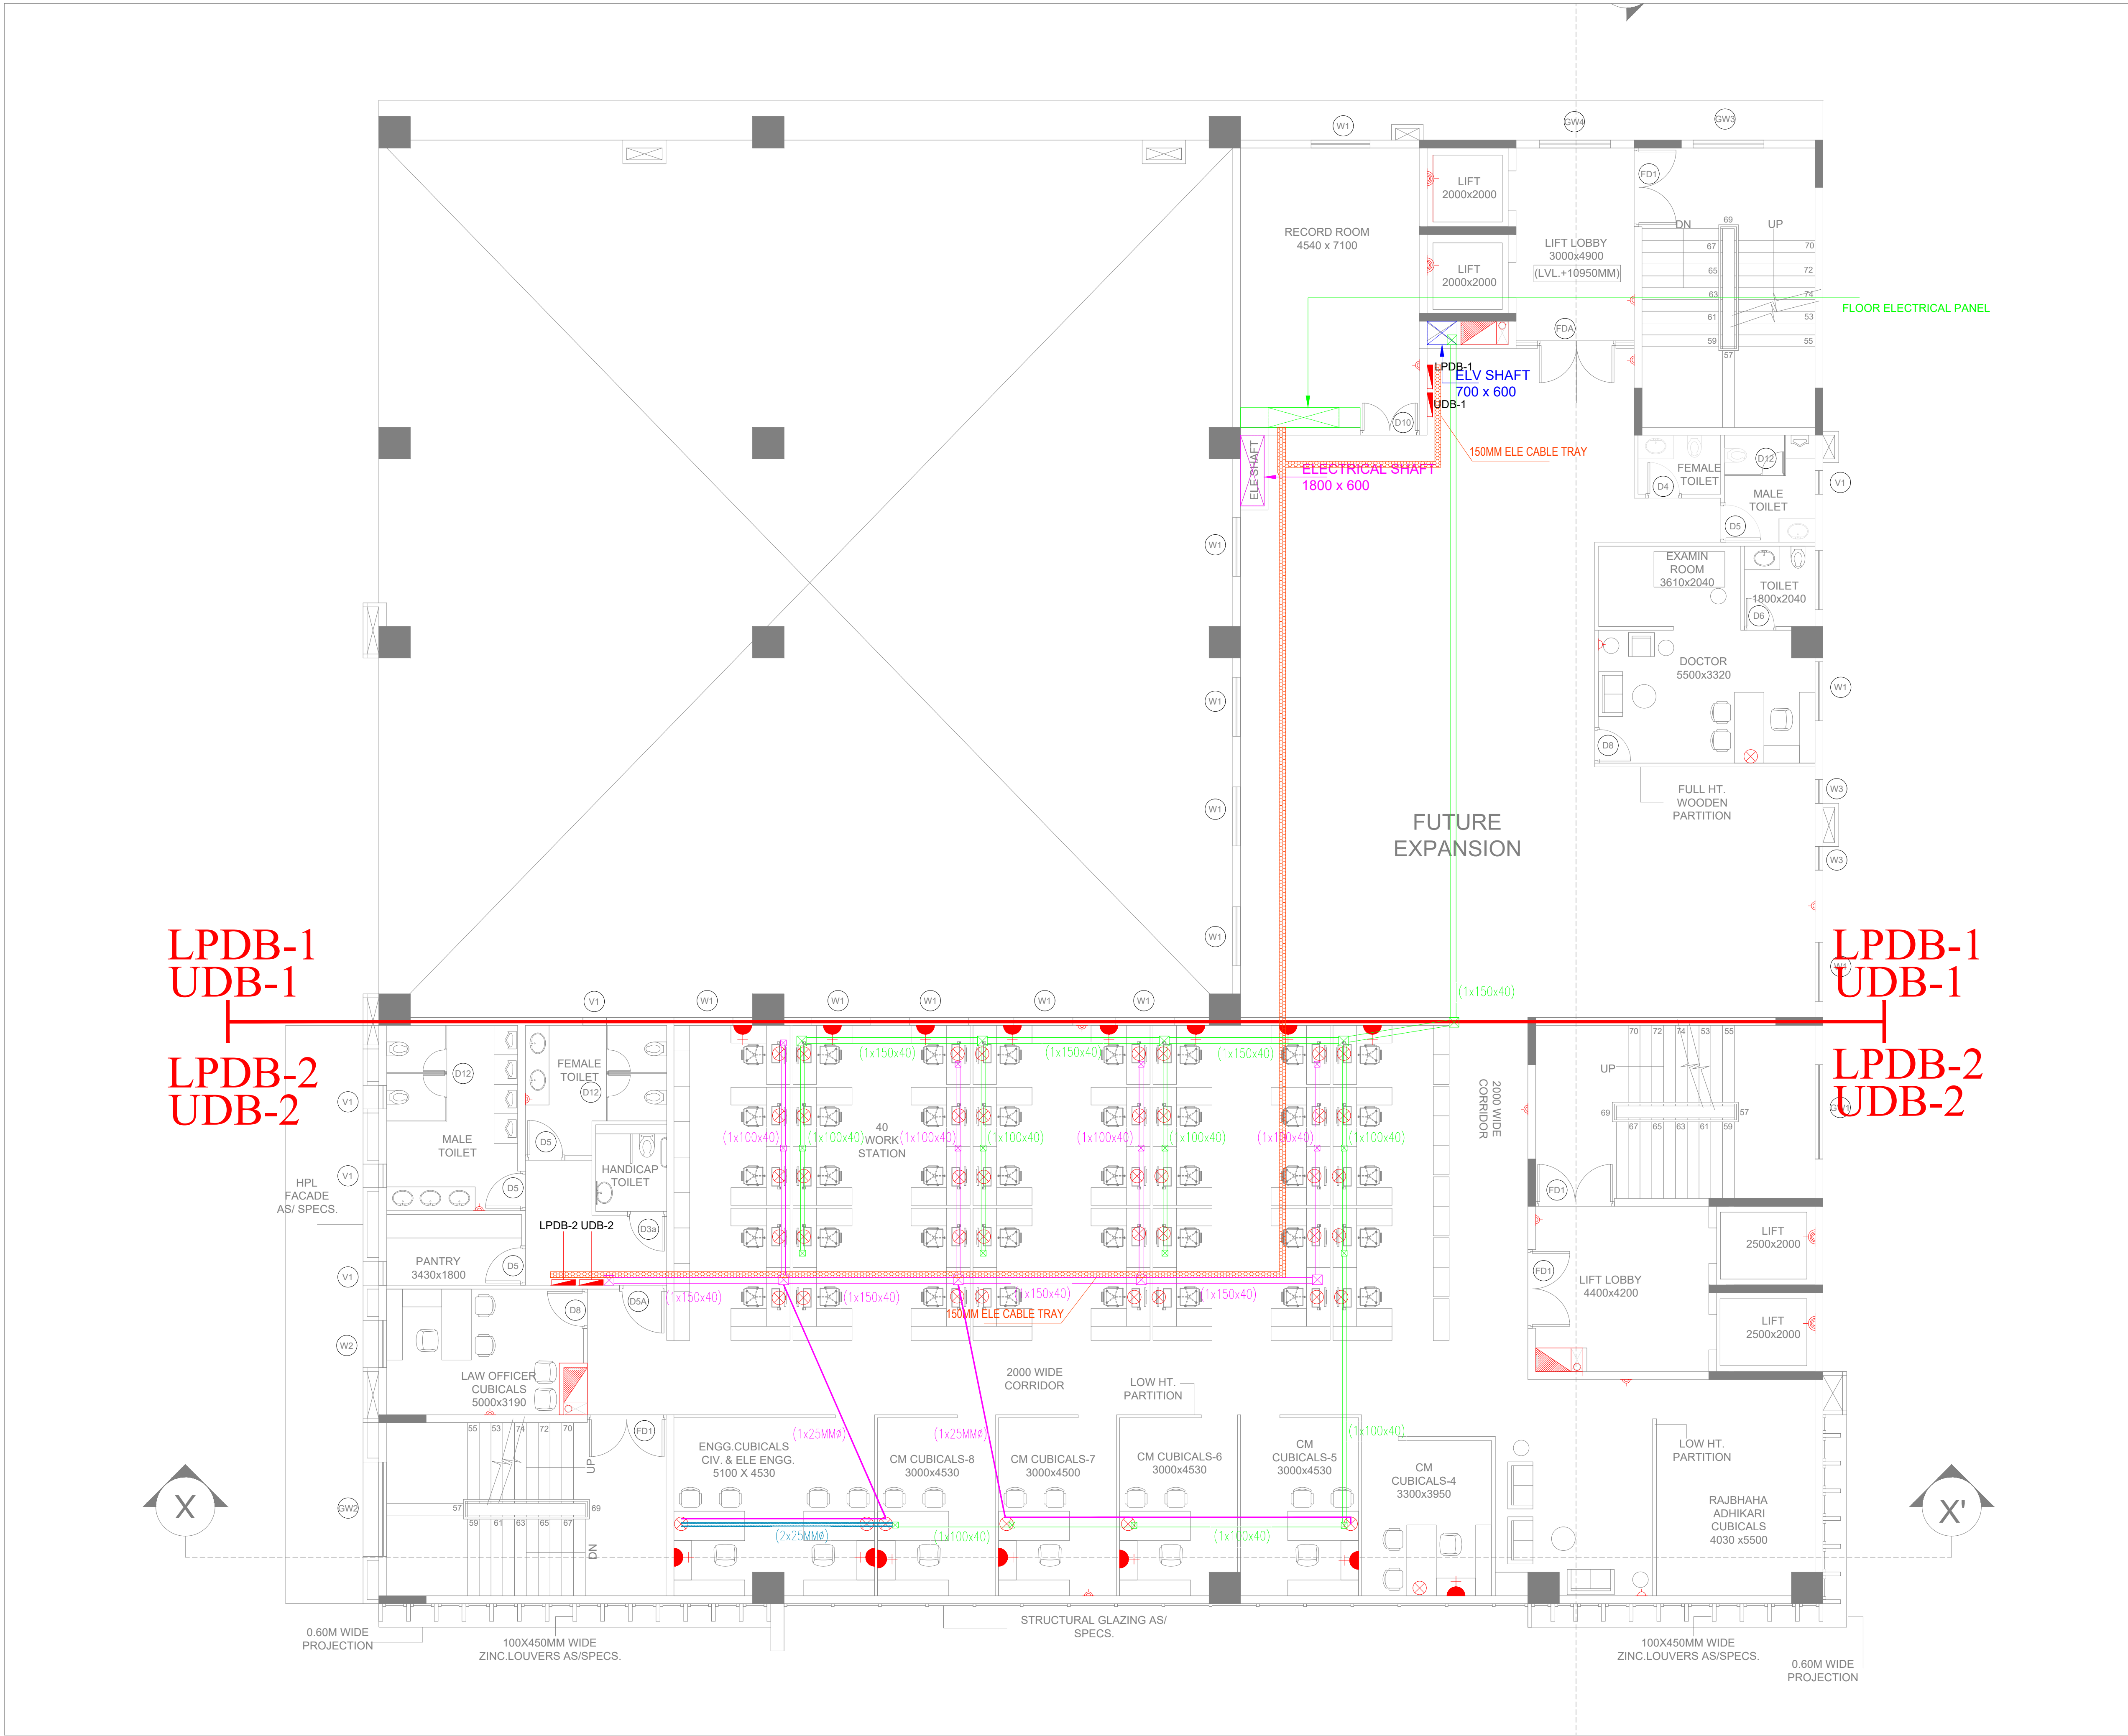

Key Plan :

Notes :

1. THIS DRAWING AND DESIGN IS THE PROPERTY OF THE DESIGNERS. NO PORTION MAY BE USED OR REPRODUCED WITHOUT THEIR WRITTEN PERMISSION.
2. THIS DRAWING IS TO BE READ IN CONJUNCTION WITH THE DESIGNERS SPECIFICATIONS AND CONDITIONS OF CONTRACT.
3. ALL DIMENSIONS ARE TO BE READ NOT SCALED.
4. ALL INDICATED LEVELS ARE FINISHED LEVELS UNLESS NOTED OTHERWISE.
5. ALL OUTER DIMENSIONS IN METER & INTERNAL DIMENSIONS IN MM.
6. PANEL LOCATION IS TENTATIVE IT MAYBE BE PLACE APPROPRIATE LOCATION AT THE TIME OF CONSTRUCTION.



PROJECT TITLE

PROPOSED CONSTRUCTION OF MULTI STOREY BUILDING FOR SBI BANK AT KALYANPUR NEAR CIRCUIT HOUSE,DEOGARH

CLIENT :-

**SBI** STATE BANK OF INDIA PATNA

ARCHITECT:-

**D K & ASSOCIATES**  
(ARCHITECTS & INTERIOR DESIGNERS)  
A-385, DEFENCE COLONY, NEW DELHI - 110024.  
Tel: 91-11-24333312/918 Email : dps200@gmail.com

DRAWING STAGE:-

TENDER DRAWING

MEP - CONSULTANT

**AD CONSULTANTS**  
C-419, 4th Floor Vipul Plaza  
Sector-31 Faridabad-121002  
HARYANA INDIA  
Email: info@adconsultants.co.in  
Website: www.adconsultants.co.in  
Ph: +91-9811-662885

Drawn: ATUL PANDEY

Checked: MOHAN SHARMA


DRAWING TITLE:-

THIRD FLOOR PLAN  
POWER LAYOUT

| SCALE                                  | ARCH./ENGR.:                              | DATE                   | REV. |
|----------------------------------------|-------------------------------------------|------------------------|------|
| A1 SHEET:-<br>A2 SHEET:-<br>A3 SHEET:- | DRAWN:<br>KAMLESH<br>CHECKED:<br>GURPREET | 04-03-2025<br>APPROVED | R1   |

DRAWING NO.  
DKA/SBI/TD/EL/THIRD-02



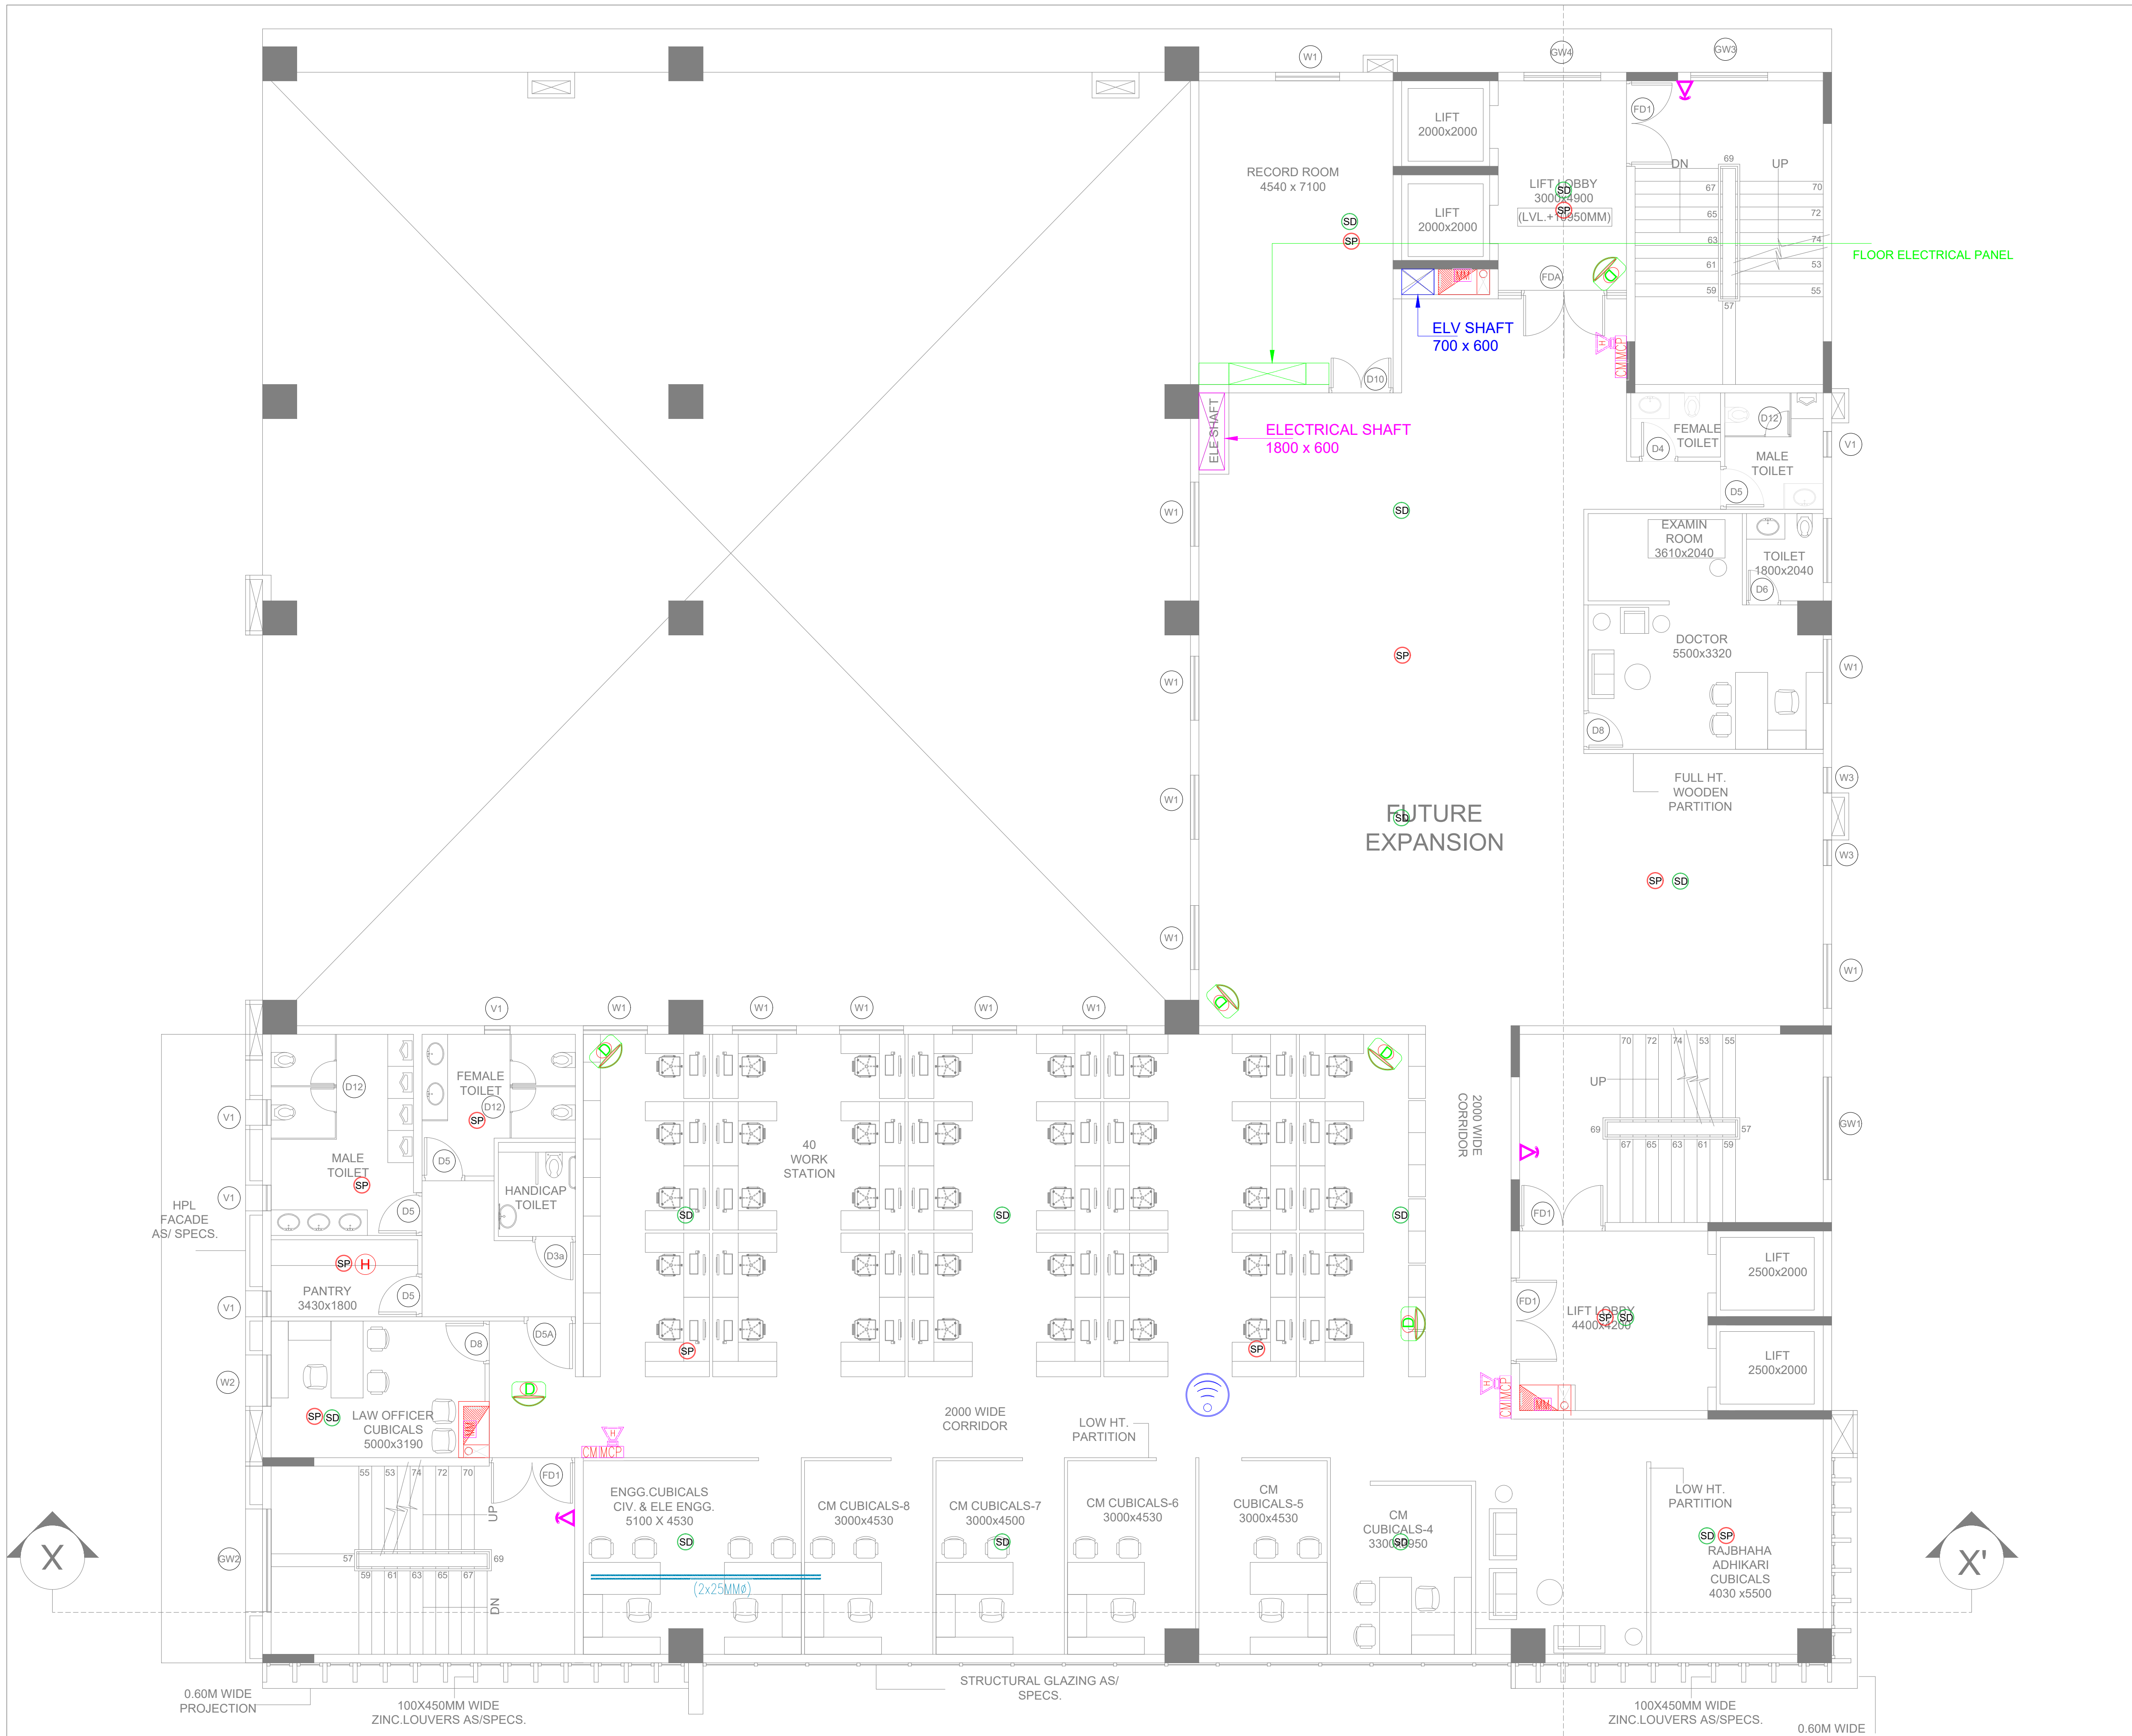

Key Plan :

Notes :

1. THIS DRAWING AND DESIGN IS THE PROPERTY OF THE DESIGNERS. NO PORTION MAY BE USED OR REPRODUCED WITHOUT THEIR WRITTEN PERMISSION.
2. THIS DRAWING IS TO BE READ IN CONJUNCTION WITH THE DESIGNERS SPECIFICATIONS AND CONDITIONS OF CONTRACT.
3. ALL DIMENSIONS ARE TO BE READ NOT SCALED.
4. ALL INDICATED LEVELS ARE FINISHED LEVELS UNLESS NOTED OTHERWISE.
5. ALL OUTER DIMENSIONS IN METER & INTERNAL DIMENSIONS IN MM.
6. PANEL LOCATION IS TENTATIVE IT MAYBE BE PLACE APPROPRIATE LOCATION AT THE TIME OF CONSTRUCTION.



PROJECT TITLE

PROPOSED CONSTRUCTION OF MULTI STOREY BUILDING FOR SBI BANK AT KALYANPUR NEAR CIRCUIT HOUSE, DEOGARH

CLIENT :-

**SBI** STATE BANK OF INDIA PATNA

ARCHITECT:-

**D K & ASSOCIATES**  
(ARCHITECTS & INTERIOR DESIGNERS)  
A-385, DEFENCE COLONY, NEW DELHI - 110024.  
Tel: 91-11-24333312/918 Email : dpe200@gmail.com

DRAWING STAGE:-

**TENDER DRAWING**

MEP - CONSULTANT

**AD CONSULTANTS**  
C-419, 4th Floor Vipul Plaza | Email: info@adconsultants.co.in  
Sector-31 Faridabad-121002 | website: www.adconsultants.co.in  
HARYANA INDIA | Ph: +91-9811-662885

drawn: **ATUL PANDEY**

checked: **MOHAN SHARMA**


DRAWING TITLE:-

**THIRD FLOOR PLAN  
FIRE ALARM \_ PA \_ WIFI &  
CCTV LAYOUT**

| SCALE      | ARCH./ENGR.:             | DATE       | REV. |
|------------|--------------------------|------------|------|
| A1 SHEET:- |                          | 04-03-2025 |      |
| A2 SHEET:- | DRAWN: <b>KAMLESH</b>    | APPROVED   |      |
| A3 SHEET:- | CHECKED: <b>GURPREET</b> |            |      |

DRAWING NO.  
DKA/SBI/TD/EL/THIRD-03



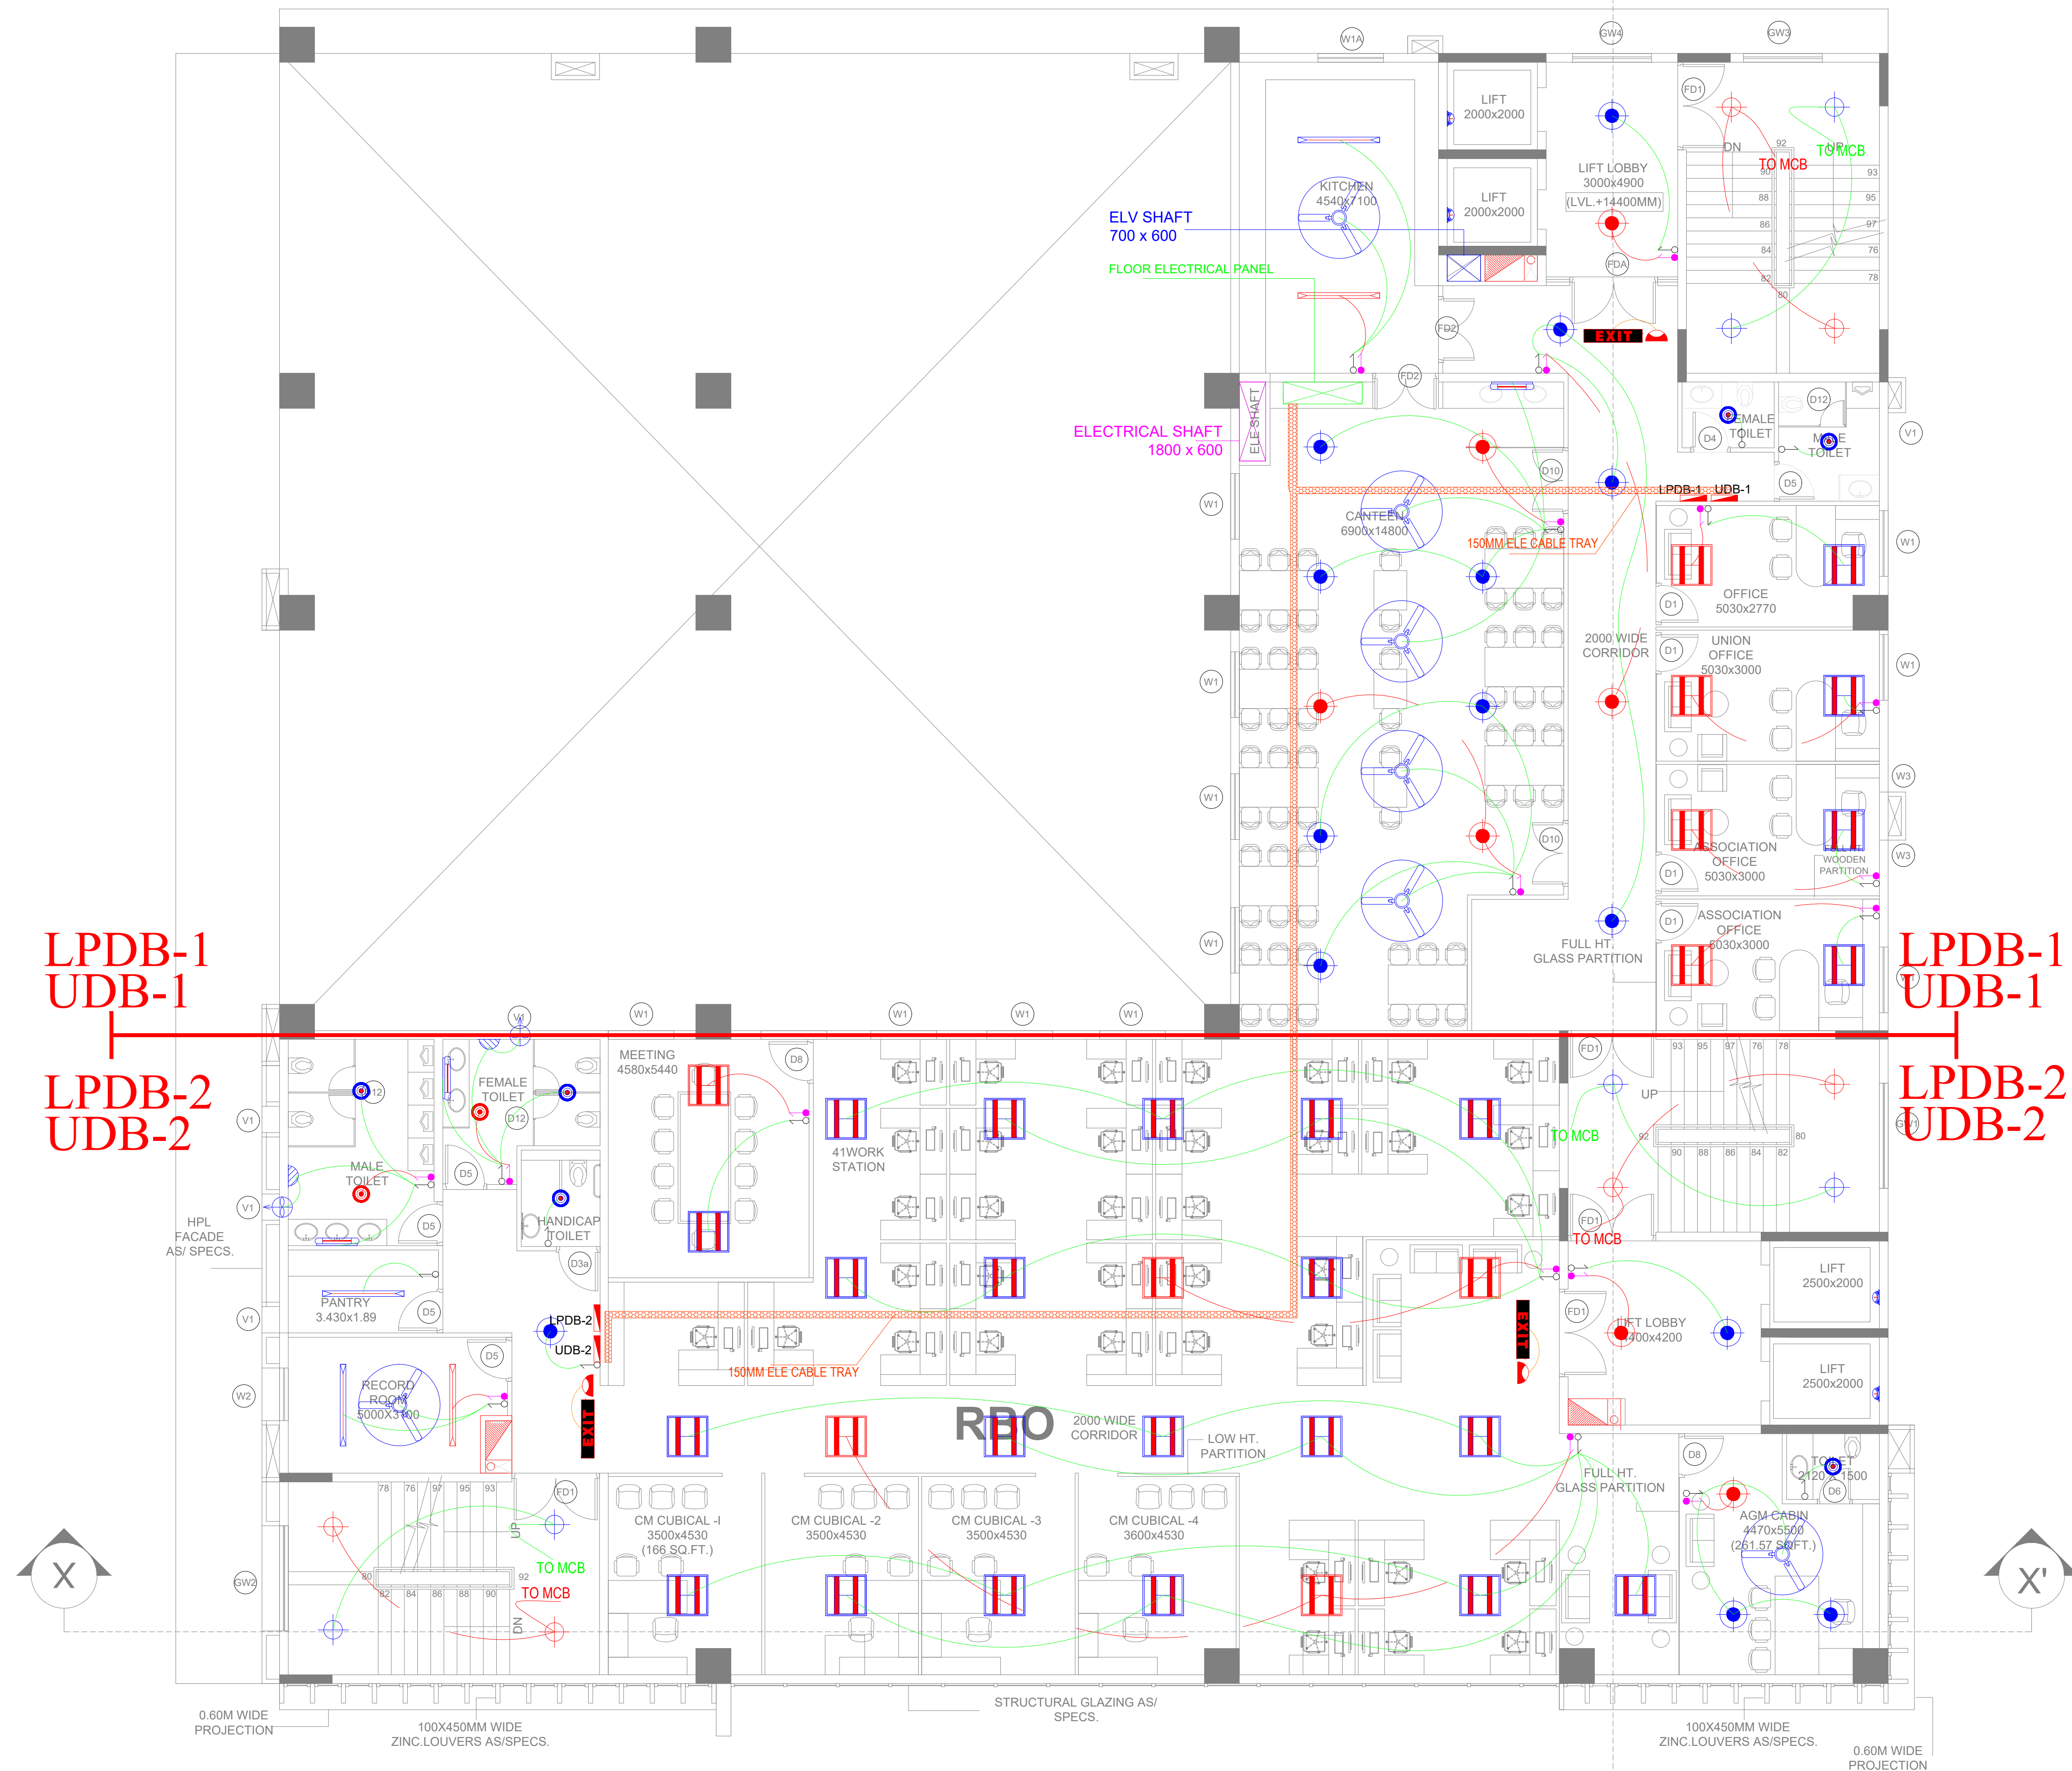

LPDB-1  
UDB-1  
LPDB-2  
UDB-2

LPDB-1  
UDB-1  
LPDB-2  
UDB-2

Key Plan :

Notes :

1. THIS DRAWING AND DESIGN IS THE PROPERTY OF THE DESIGNERS. NO PORTION MAY BE USED OR REPRODUCED WITHOUT THEIR WRITTEN PERMISSION.
2. THIS DRAWING IS TO BE READ IN CONJUNCTION WITH THE DESIGNERS SPECIFICATIONS AND CONDITIONS OF CONTRACT.
3. ALL DIMENSIONS ARE TO BE READ NOT SCALED.
4. ALL INDICATED LEVELS ARE FINISHED LEVELS UNLESS NOTED OTHERWISE.
5. ALL OUTER DIMENSIONS IN METER & INTERNAL DIMENSIONS IN MM.
6. PANEL LOCATION IS TENTATIVE IT MAYBE BE PLACE APPROPRIATE LOCATION AT THE TIME OF CONSTRUCTION.



PROJECT TITLE

PROPOSED CONSTRUCTION OF MULTI STOREY BUILDING FOR SBI BANK AT KALYANPUR NEAR CIRCUIT HOUSE, DEOGARH

CLIENT :-

STATE BANK OF INDIA PATNA

ARCHITECT:-

**D K & ASSOCIATES**  
(ARCHITECTS & INTERIOR DESIGNERS)  
A-385, DEFENCE COLONY, NEW DELHI - 110024  
Tel: 91-11-24333312/918 Email : dps200@gmail.com

DRAWING STAGE:-

TENDER DRAWING

MEP - CONSULTANT


**AD CONSULTANTS**  
C-419, 4th Floor Vipul Plaza | Email: info@adconsultants.co.in  
Sector-31 Faridabad-121002 | Website: www.adconsultants.co.in  
HARYANA INDIA | Ph: +91-9811-662885

Drawn: ATUL PANDEY | Checked: MOHAN SHARMA

DRAWING TITLE:-

FOURTH FLOOR PLAN  
LIGHTING LAYOUT

| SCALE                                  | ARCH./ENGR.:                            | DATE                   | REV. |
|----------------------------------------|-----------------------------------------|------------------------|------|
| A1 SHEET:-<br>A2 SHEET:-<br>A3 SHEET:- | DRAWN<br>KAMLESH<br>CHECKED<br>GURPREET | 04-03-2025<br>APPROVED | R1   |
| DRAWING NO.<br>DKA/SBI/TD/EL/FOURTH-01 |                                         |                        |      |

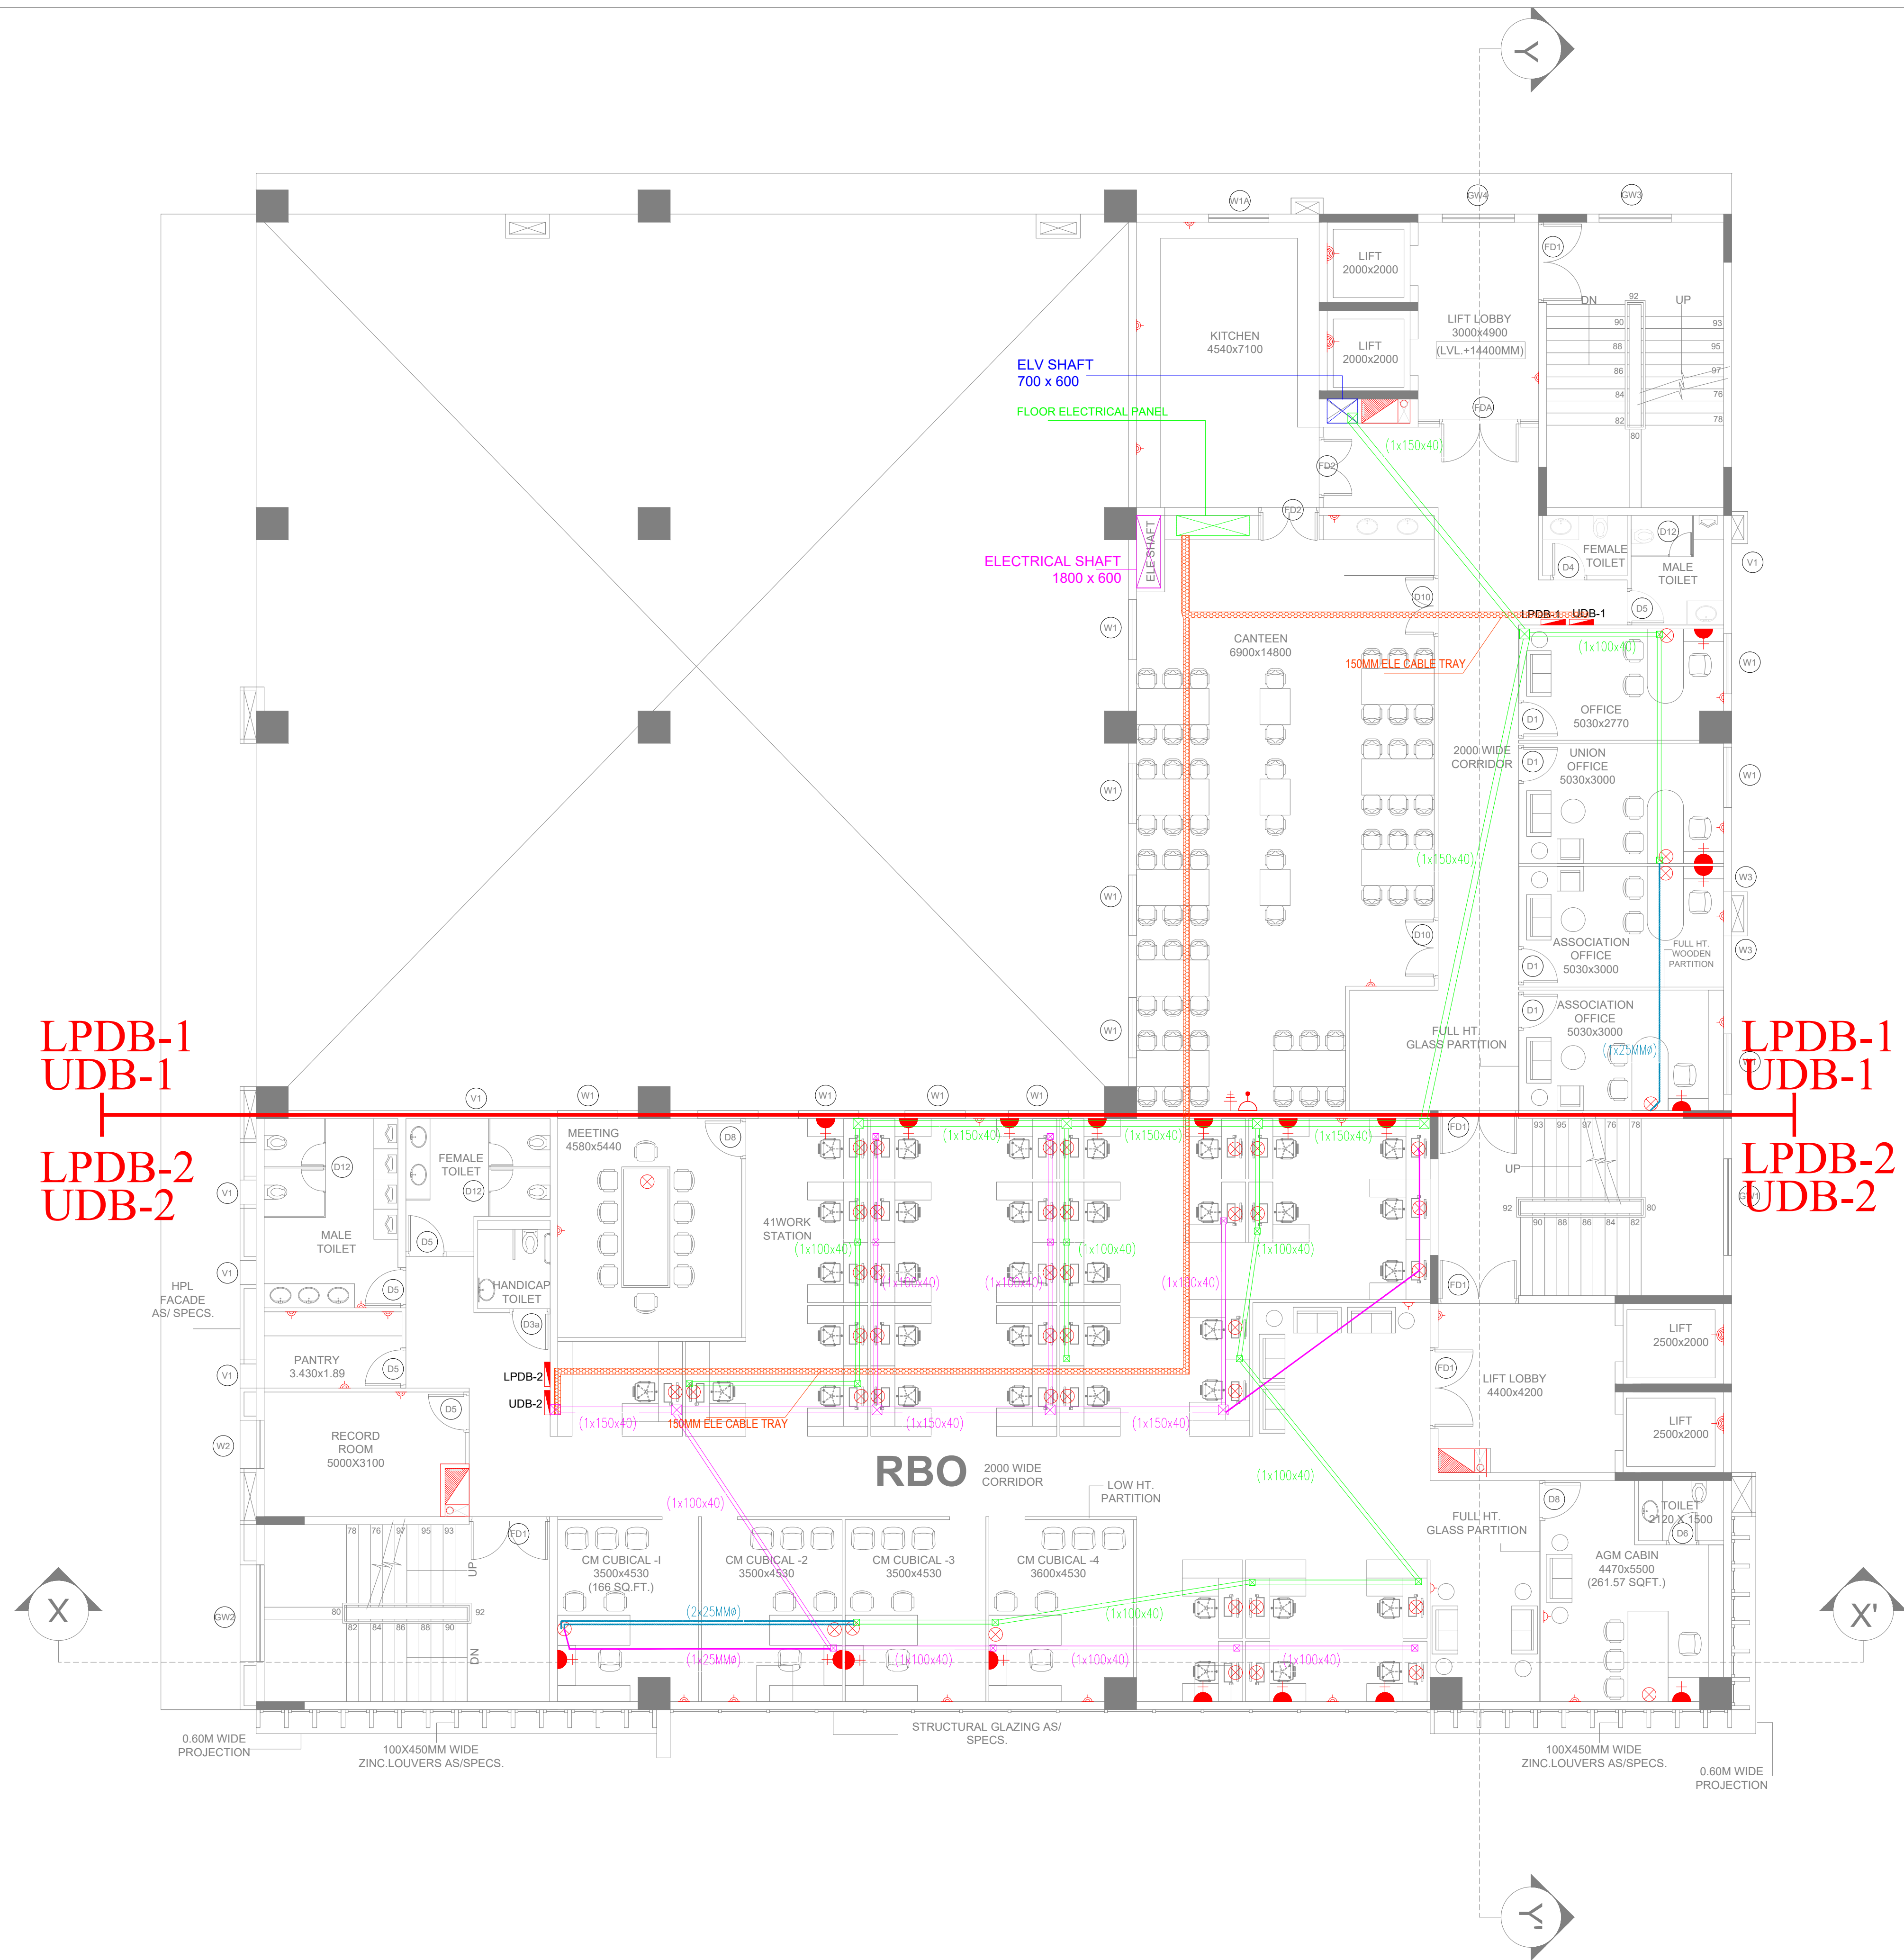

Key Plan :

Notes :

1. THIS DRAWING AND DESIGN IS THE PROPERTY OF THE DESIGNERS. NO PORTION MAY BE USED OR REPRODUCED WITHOUT THEIR WRITTEN PERMISSION.
2. THIS DRAWING IS TO BE READ IN CONJUNCTION WITH THE DESIGNERS SPECIFICATIONS AND CONDITIONS OF CONTRACT.
3. ALL DIMENSIONS ARE TO BE READ NOT SCALED.
4. ALL INDICATED LEVELS ARE FINISHED LEVELS UNLESS NOTED OTHERWISE.
5. ALL OUTER DIMENSIONS IN METER & INTERNAL DIMENSIONS IN MM.
6. PANEL LOCATION IS TENTATIVE IT MAYBE BE PLACE APPROPRIATE LOCATION AT THE TIME OF CONSTRUCTION.



PROJECT TITLE

PROPOSED CONSTRUCTION OF MULTI STOREY BUILDING FOR SBI BANK AT KALYANPUR NEAR CIRCUIT HOUSE, DEOGARH

CLIENT :-

STATE BANK OF INDIA PATNA

ARCHITECT:-

**D K & ASSOCIATES**  
(ARCHITECTS & INTERIOR DESIGNERS)  
A-385, DEFENCE COLONY, NEW DELHI - 110024.  
Tel: 91-11-24333312/918 Email : dpe200@gmail.com

DRAWING STAGE:-

TENDER DRAWING

MEP - CONSULTANT

**AD CONSULTANTS**  
C-419, 4th Floor Vipul Plaza | Email: info@adconsultants.co.in  
Sector-31 Faridabad-121002 | website: www.adconsultants.co.in  
HARYANA INDIA | Ph: +91-9811-662885


drawn: **ATUL PANDEY** checked: **MOHAN SHARMA**


DRAWING TITLE:-

FOURTH FLOOR PLAN  
POWER LAYOUT

| SCALE                                  | ARCH./ENGR.:                                          | DATE                   | REV. |
|----------------------------------------|-------------------------------------------------------|------------------------|------|
| A1 SHEET:-<br>A2 SHEET:-<br>A3 SHEET:- | DRAWN<br><b>KAMLESH</b><br>CHECKED<br><b>GURPREET</b> | 04-03-2025<br>APPROVED | R1   |

 DRAWING NO.  
DKA/SBI/TD/EL/FOURTH-02



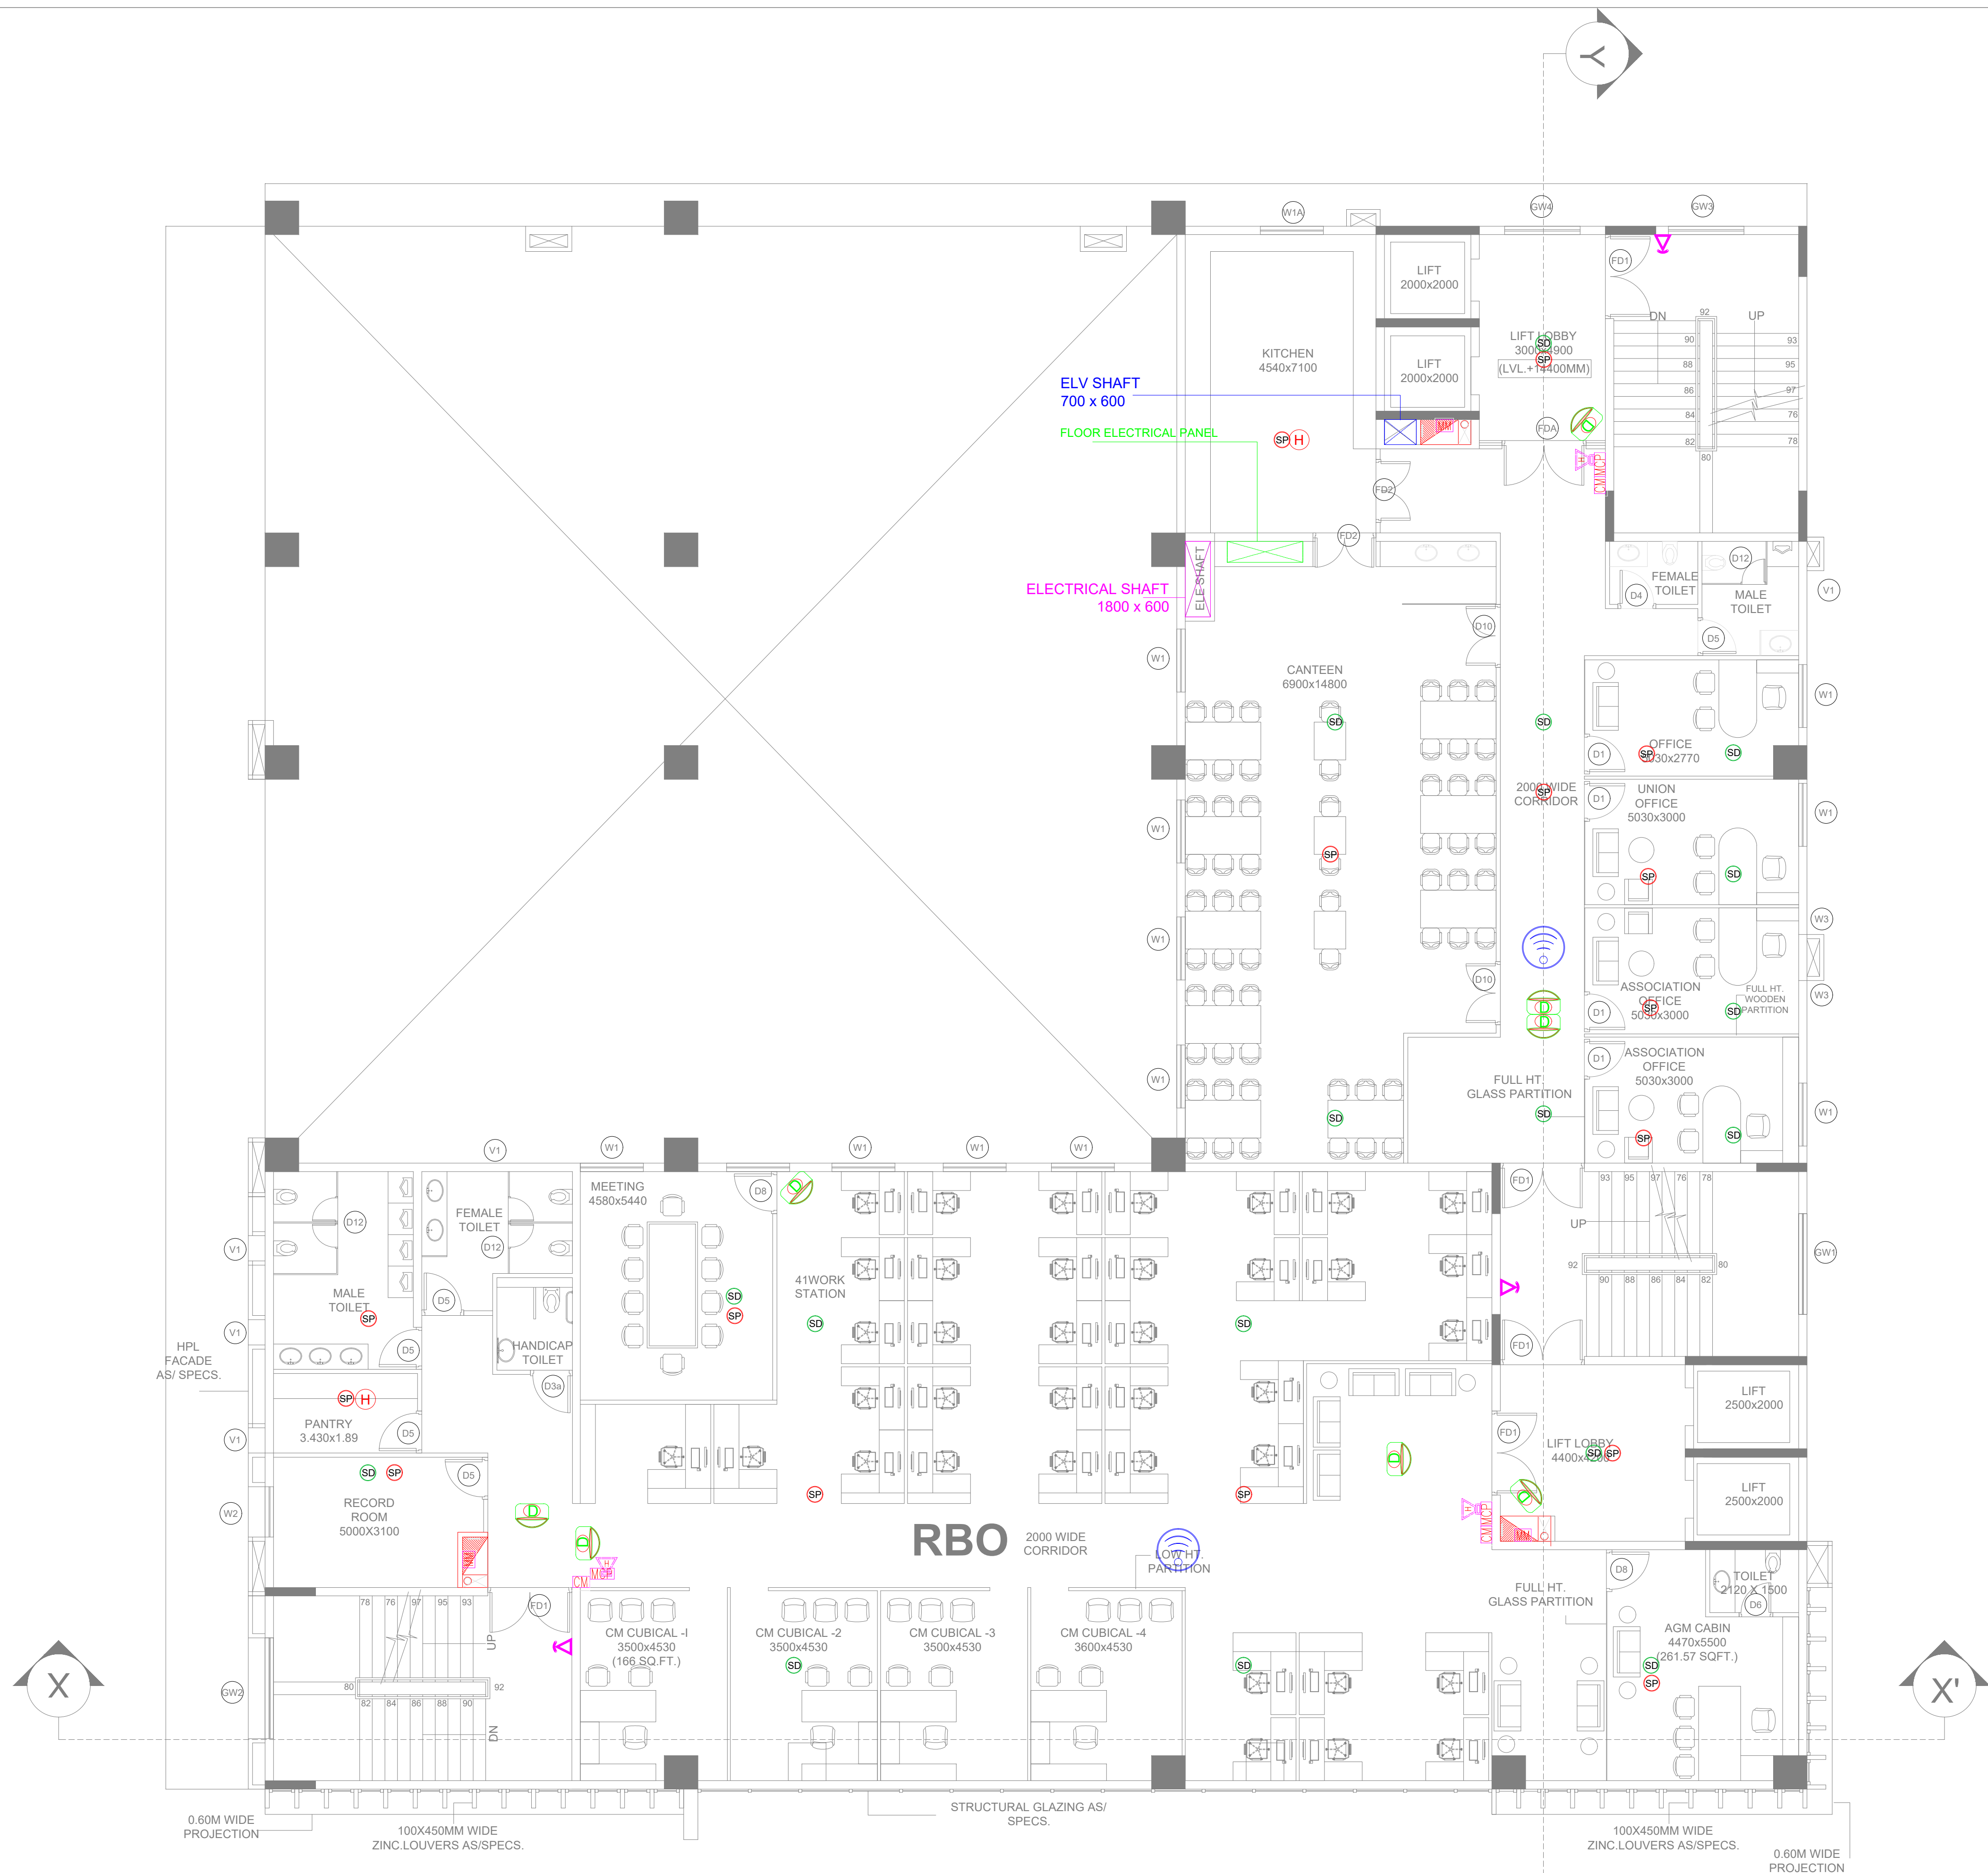

Key Plan :

Notes :

1. THIS DRAWING AND DESIGN IS THE PROPERTY OF THE DESIGNERS. NO PORTION MAY BE USED OR REPRODUCED WITHOUT THEIR WRITTEN PERMISSION.
2. THIS DRAWING IS TO BE READ IN CONJUNCTION WITH THE DESIGNERS SPECIFICATIONS AND CONDITIONS OF CONTRACT.
3. ALL DIMENSIONS ARE TO BE READ NOT SCALED.
4. ALL INDICATED LEVELS ARE FINISHED LEVELS UNLESS NOTED OTHERWISE.
5. ALL OUTER DIMENSIONS IN METER & INTERNAL DIMENSIONS IN MM.
6. PANEL LOCATION IS TENTATIVE IT MAYBE BE PLACE APPROPRIATE LOCATION AT THE TIME OF CONSTRUCTION.



PROJECT TITLE

PROPOSED CONSTRUCTION OF MULTI STOREY BUILDING FOR SBI BANK AT KALYANPUR NEAR CIRCUIT HOUSE, DEOGARH

CLIENT :-

**SBI** STATE BANK OF INDIA PATNA

ARCHITECT:-

**D K & ASSOCIATES**  
(ARCHITECTS & INTERIOR DESIGNERS)  
A-385, DEFENCE COLONY, NEW DELHI - 110024.  
Tel: 91-11-24333312/918 Email : dpe200@gmail.com

DRAWING STAGE:-

**TENDER DRAWING**

MEP - CONSULTANT

**AD CONSULTANTS**  
C-419, 4th Floor Vipul Plaza | Email: info@adconsultants.co.in  
Sector-31 Faridabad-121002 | website: www.adconsultants.co.in  
HARYANA INDIA | Ph: +91-9811-662885

drawn: **ATUL PANDEY** checked: **MOHAN SHARMA**

DRAWING TITLE:-

**FOURTH FLOOR PLAN  
FIRE ALARM \_ PA \_ WIFI &  
CCTV LAYOUT**

| SCALE                                  | ARCH./ENGR.:                                            | DATE                          | REV.      |
|----------------------------------------|---------------------------------------------------------|-------------------------------|-----------|
| A1 SHEET:-<br>A2 SHEET:-<br>A3 SHEET:- | DRAWN:<br><b>KAMLESH</b><br>CHECKED:<br><b>GURPREET</b> | <b>04-03-2025</b><br>APPROVED | <b>R1</b> |

DRAWING NO.  
DKA/SBI/TD/EL/FOURTH-03

