


LPDB-1
UDB-1
LPDB-2
UDB-2

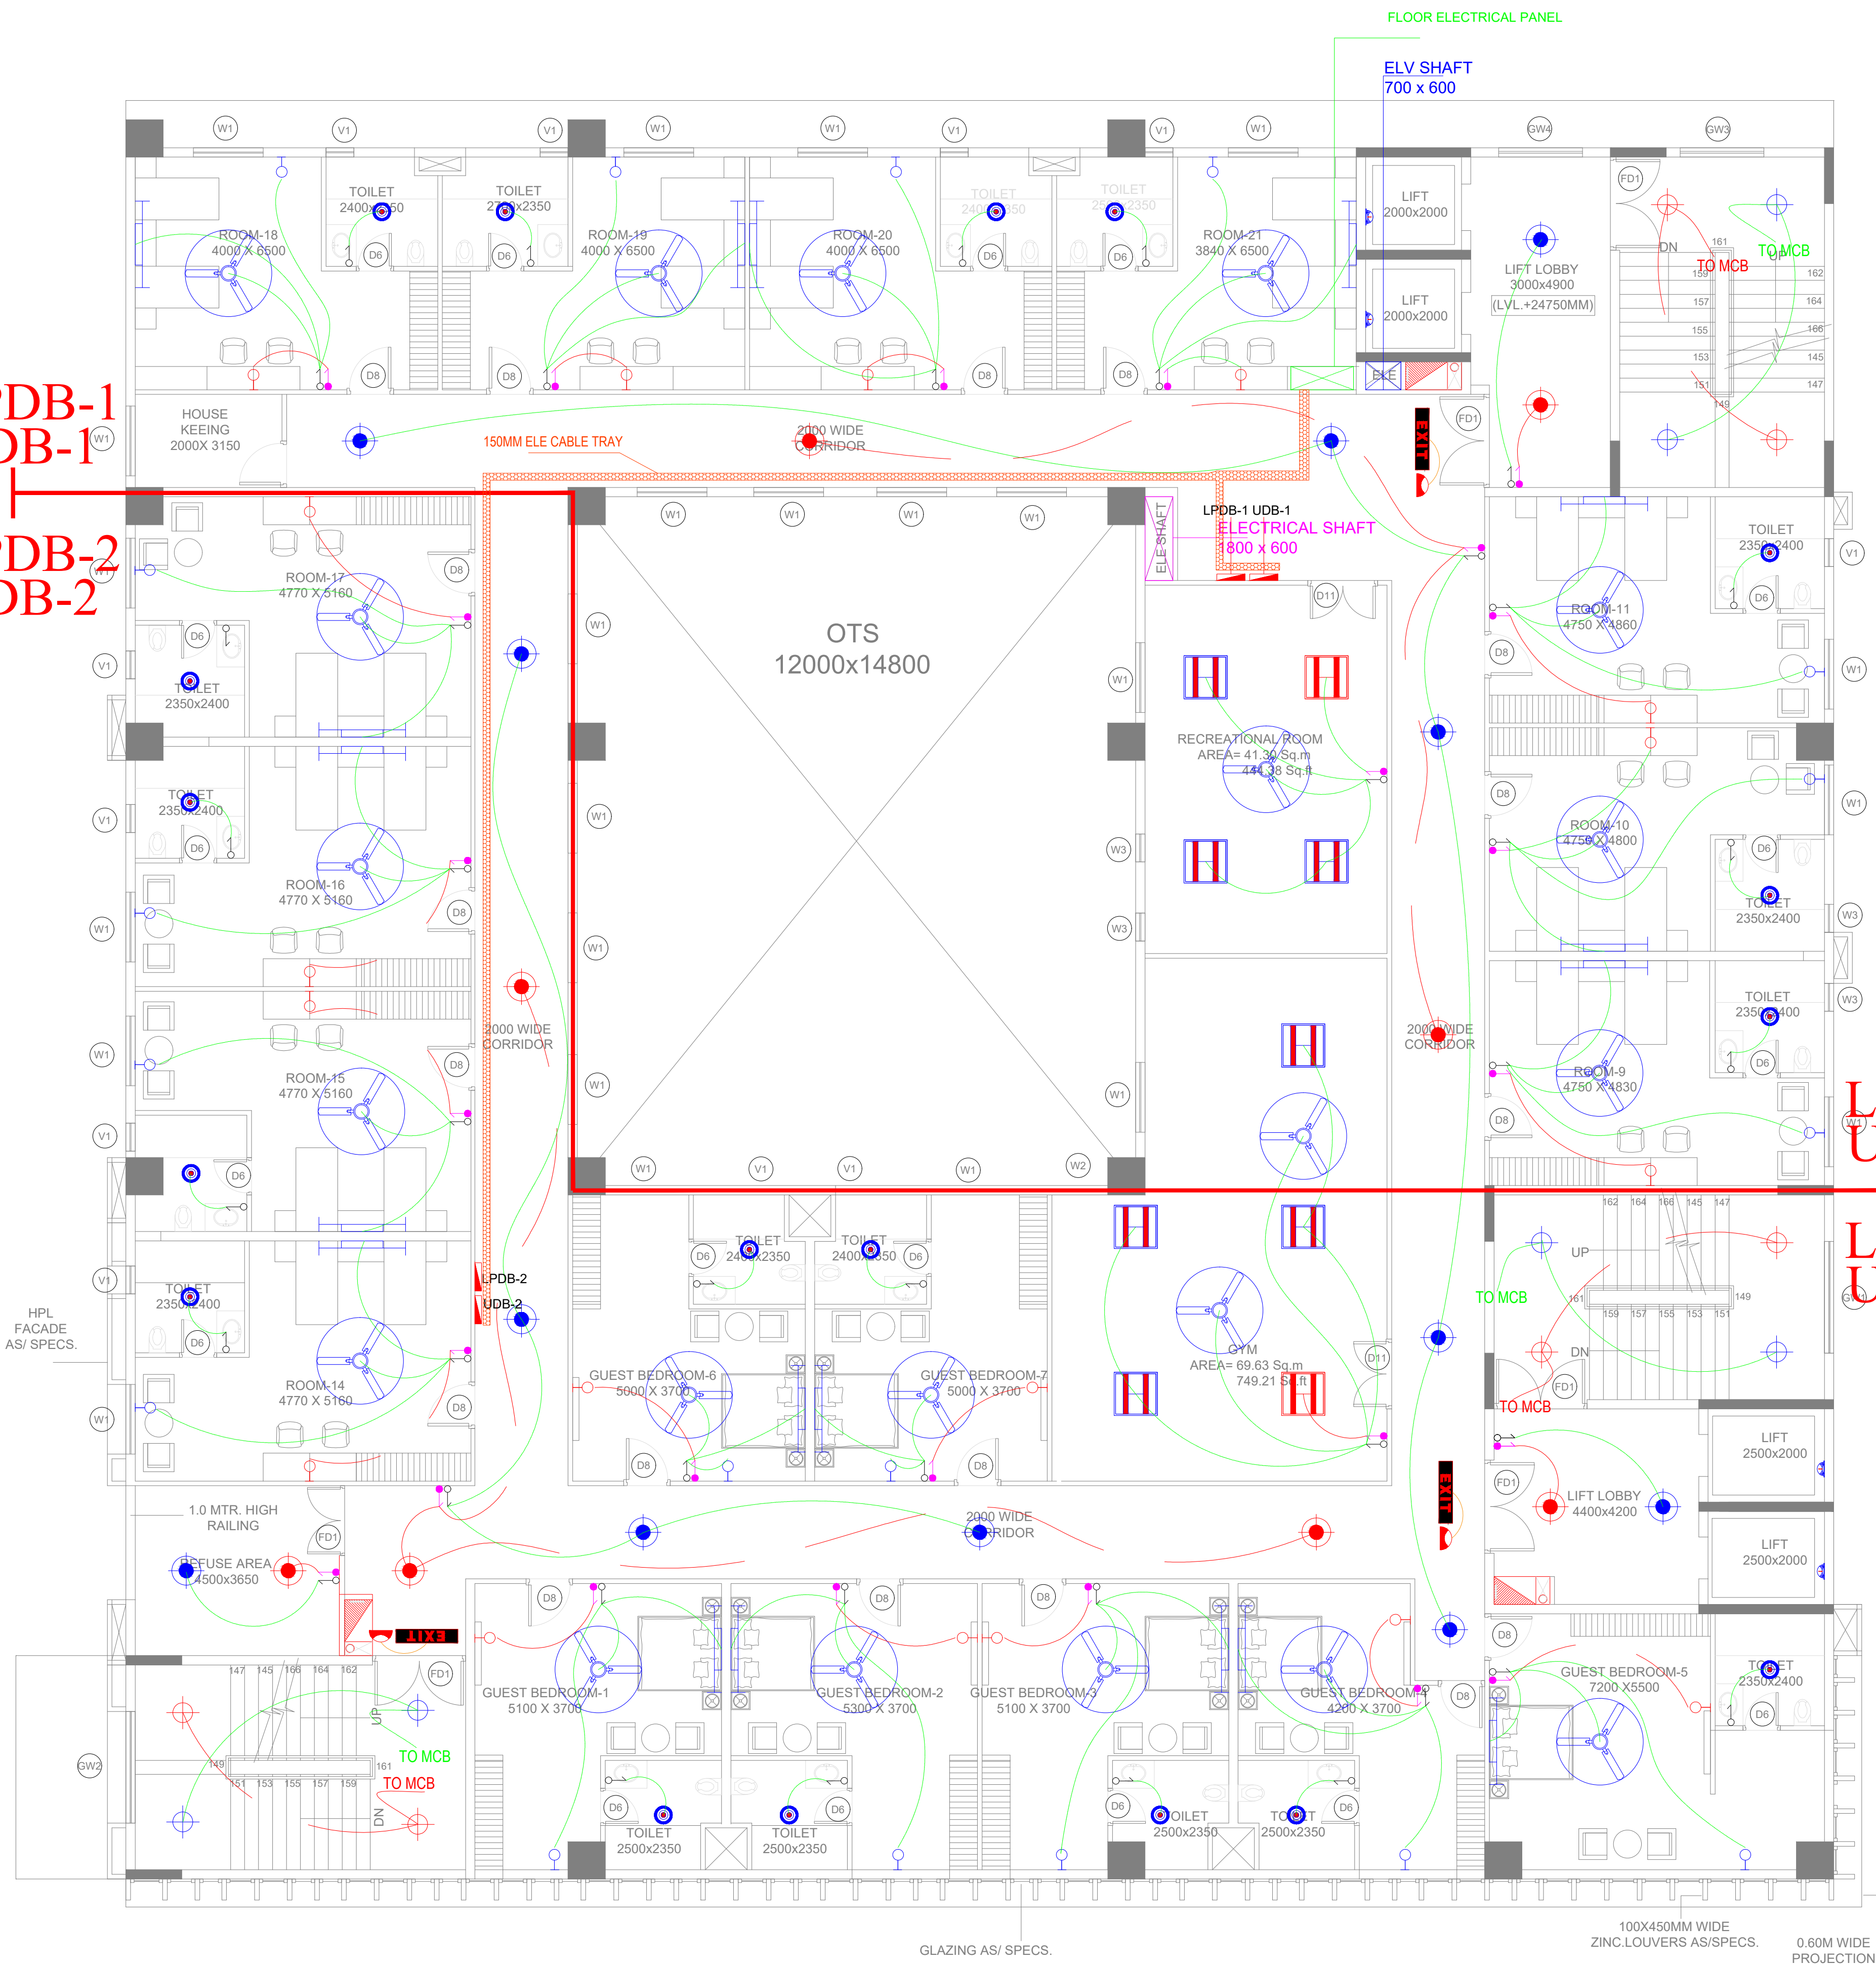

Key Plan :

Notes :

1. THIS DRAWING AND DESIGN IS THE PROPERTY OF THE DESIGNERS. NO PORTION MAY BE USED OR REPRODUCED WITHOUT THEIR WRITTEN PERMISSION.
2. THIS DRAWING IS TO BE READ IN CONJUNCTION WITH THE DESIGNERS SPECIFICATIONS AND CONDITIONS OF CONTRACT.
3. ALL DIMENSIONS ARE TO BE READ NOT SCALED.
4. ALL INDICATED LEVELS ARE FINISHED LEVELS UNLESS NOTED OTHERWISE.
5. ALL OUTER DIMENSIONS IN METER & INTERNAL DIMENSIONS IN MM.
6. PANEL LOCATION IS TENTATIVE IT MAYBE BE PLACE APPROPRIATE LOCATION AT THE TIME OF CONSTRUCTION.



PROJECT TITLE

PROPOSED CONSTRUCTION OF MULTI STOREY BUILDING FOR SBI BANK AT KALYANPUR NEAR CIRCUIT HOUSE, DEOGARH

CLIENT :-

STATE BANK OF INDIA PATNA

ARCHITECT:-

D K & ASSOCIATES
(ARCHITECTS & INTERIOR DESIGNERS)
A-385, DEFENCE COLONY, NEW DELHI - 110024.
Tel: 91-11-24333312/918 Email : dps200@gmail.com

DRAWING STAGE:-

TENDER DRAWING

MEP - CONSULTANT


AD CONSULTANTS
C-419, 4th Floor Vipul Plaza | Email: info@adconsultants.co.in
Sector-31 Faridabad-121002 | website: www.adconsultants.co.in
HARYANA INDIA | Ph: +91-9811-662885

drawn: **ATUL PANDEY** checked: **MOHAN SHARMA**

DRAWING TITLE:-

SEVENTH FLOOR PLAN
LIGHTING LAYOUT

SCALE	ARCH./ENGR.:	DATE	REV.
A1 SHEET:-	DRAWN KAMLESH CHECKED GURPREET	04-03-2025	R1
A2 SHEET:-		APPROVED	
A3 SHEET:-			
DRAWING NO. DKA/SBI/TD/EL/SEVENTH-01			

 



Key Plan :

Notes :

1. THIS DRAWING AND DESIGN IS THE PROPERTY OF THE DESIGNERS. NO PORTION MAY BE USED OR REPRODUCED WITHOUT THEIR WRITTEN PERMISSION.
2. THIS DRAWING IS TO BE READ IN CONJUNCTION WITH THE DESIGNERS SPECIFICATIONS AND CONDITIONS OF CONTRACT.
3. ALL DIMENSIONS ARE TO BE READ NOT SCALED.
4. ALL INDICATED LEVELS ARE FINISHED LEVELS UNLESS NOTED OTHERWISE.
5. ALL OUTER DIMENSIONS IN METER & INTERNAL DIMENSIONS IN MM.
6. PANEL LOCATION IS TENTATIVE IT MAYBE BE PLACE APPROPRIATE LOCATION AT THE TIME OF CONSTRUCTION.



PROJECT TITLE

PROPOSED CONSTRUCTION OF MULTI STOREY BUILDING FOR SBI BANK AT KALYANPUR NEAR CIRCUIT HOUSE,DEOGARH

CLIENT :-

SBI STATE BANK OF INDIA PATNA

ARCHITECT:-

D K & ASSOCIATES
(ARCHITECTS & INTERIOR DESIGNERS)
A-385, DEFENCE COLONY, NEW DELHI - 110024
Tel: 91-11-24333312/918 Email : dps200@gmail.com

DRAWING STAGE:-

TENDER DRAWING

MEP - CONSULTANT

AD CONSULTANTS
C-419, 4th Floor Vipul Plaza | Email: info@adconsultants.co.in
Sector-31 Faridabad-121002 | website: www.adconsultants.co.in
HARYANA INDIA | Ph: +91-9811-662885

drawn: **ATUL PANDEY** checked: **MOHAN SHARMA**


DRAWING TITLE:-

SEVENTH FLOOR PLAN
FIRE ALARM _ PA _ WIFI &
CCTV LAYOUT

SCALE	ARCH./ENGR.:	DATE	REV.
A1 SHEET:- A2 SHEET:- A3 SHEET:-	DRAWN KAMLESH CHECKED GURPREET	04-03-2025 APPROVED	R1

DRAWING NO.
DKA/SBI/TD/EL/SEVENTH-03



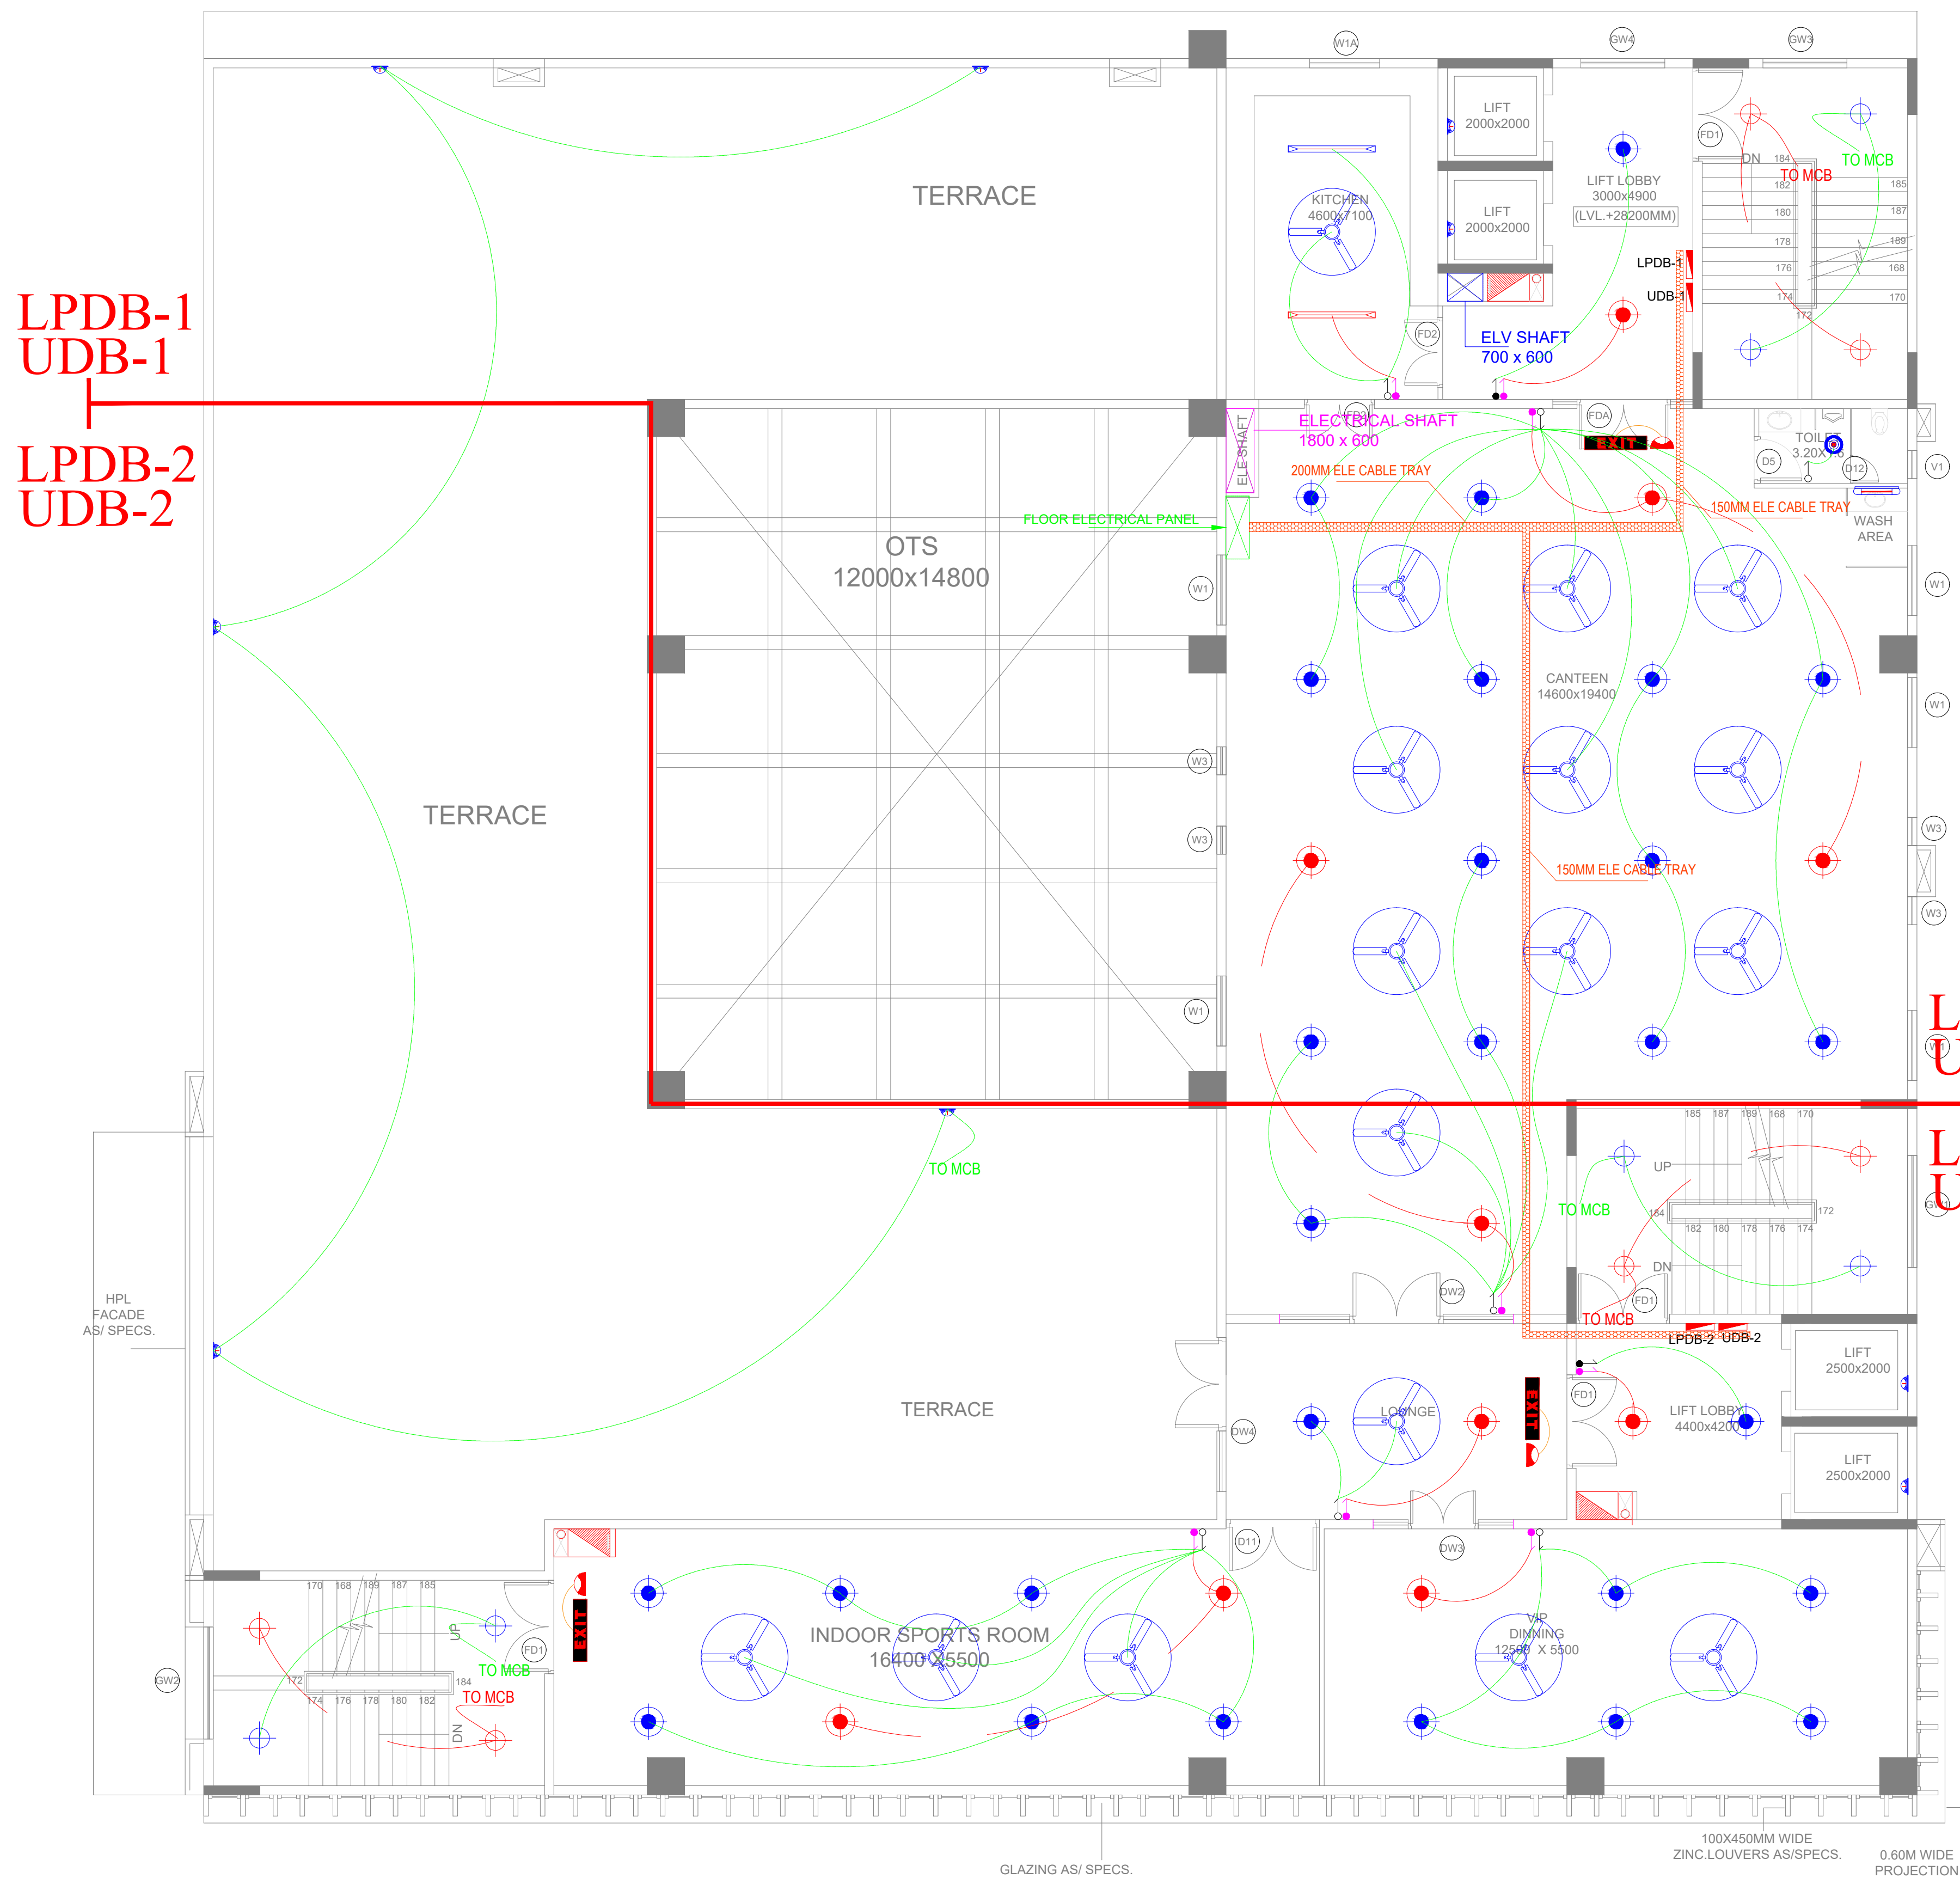

Key Plan :

Notes :

1. THIS DRAWING AND DESIGN IS THE PROPERTY OF THE DESIGNERS. NO PORTION MAY BE USED OR REPRODUCED WITHOUT THEIR WRITTEN PERMISSION.
2. THIS DRAWING IS TO BE READ IN CONJUNCTION WITH THE DESIGNERS SPECIFICATIONS AND CONDITIONS OF CONTRACT.
3. ALL DIMENSIONS ARE TO BE READ NOT SCALED.
4. ALL INDICATED LEVELS ARE FINISHED LEVELS UNLESS NOTED OTHERWISE.
5. ALL OUTER DIMENSIONS IN METER & INTERNAL DIMENSIONS IN MM.
6. PANEL LOCATION IS TENTATIVE IT MAYBE BE PLACE APPROPRIATE LOCATION AT THE TIME OF CONSTRUCTION.



PROJECT TITLE
PROPOSED CONSTRUCTION OF MULTI STOREY BUILDING FOR SBI BANK AT KALYANPUR NEAR CIRCUIT HOUSE, DEOGARH

CLIENT :-
 STATE BANK OF INDIA PATNA

ARCHITECT:-
 D K & ASSOCIATES
(ARCHITECTS & INTERIOR DESIGNERS)
A-385, DEFENCE COLONY, NEW DELHI - 110024.
Tel: 91-11-24333312/918 Email : dps200@gmail.com


DRAWING STAGE:-
TENDER DRAWING

MEP - CONSULTANT	
	AD CONSULTANTS
C-419, 4th Floor Vipul Plaza Sector-31 Faridabad-121002 HARYANA INDIA	Email: info@adconsultants.co.in website: www.adconsultants.co.in Ph: +91-9811-662885
Drawn: ATUL PANDEY	Checked: MOHAN SHARMA

DRAWING TITLE:-

**EIGHT FLOOR PLAN
LIGHTING LAYOUT**

SCALE A1 SHEET:- A2 SHEET:- A3 SHEET:-	ARCH./ENGR.: DRAWN KAMLESH CHECKED GURPREET	DATE 04-03-2025 APPROVED	REV. R1
DRAWING NO. DKA/SBI/TD/EL/EIGHTH-01			

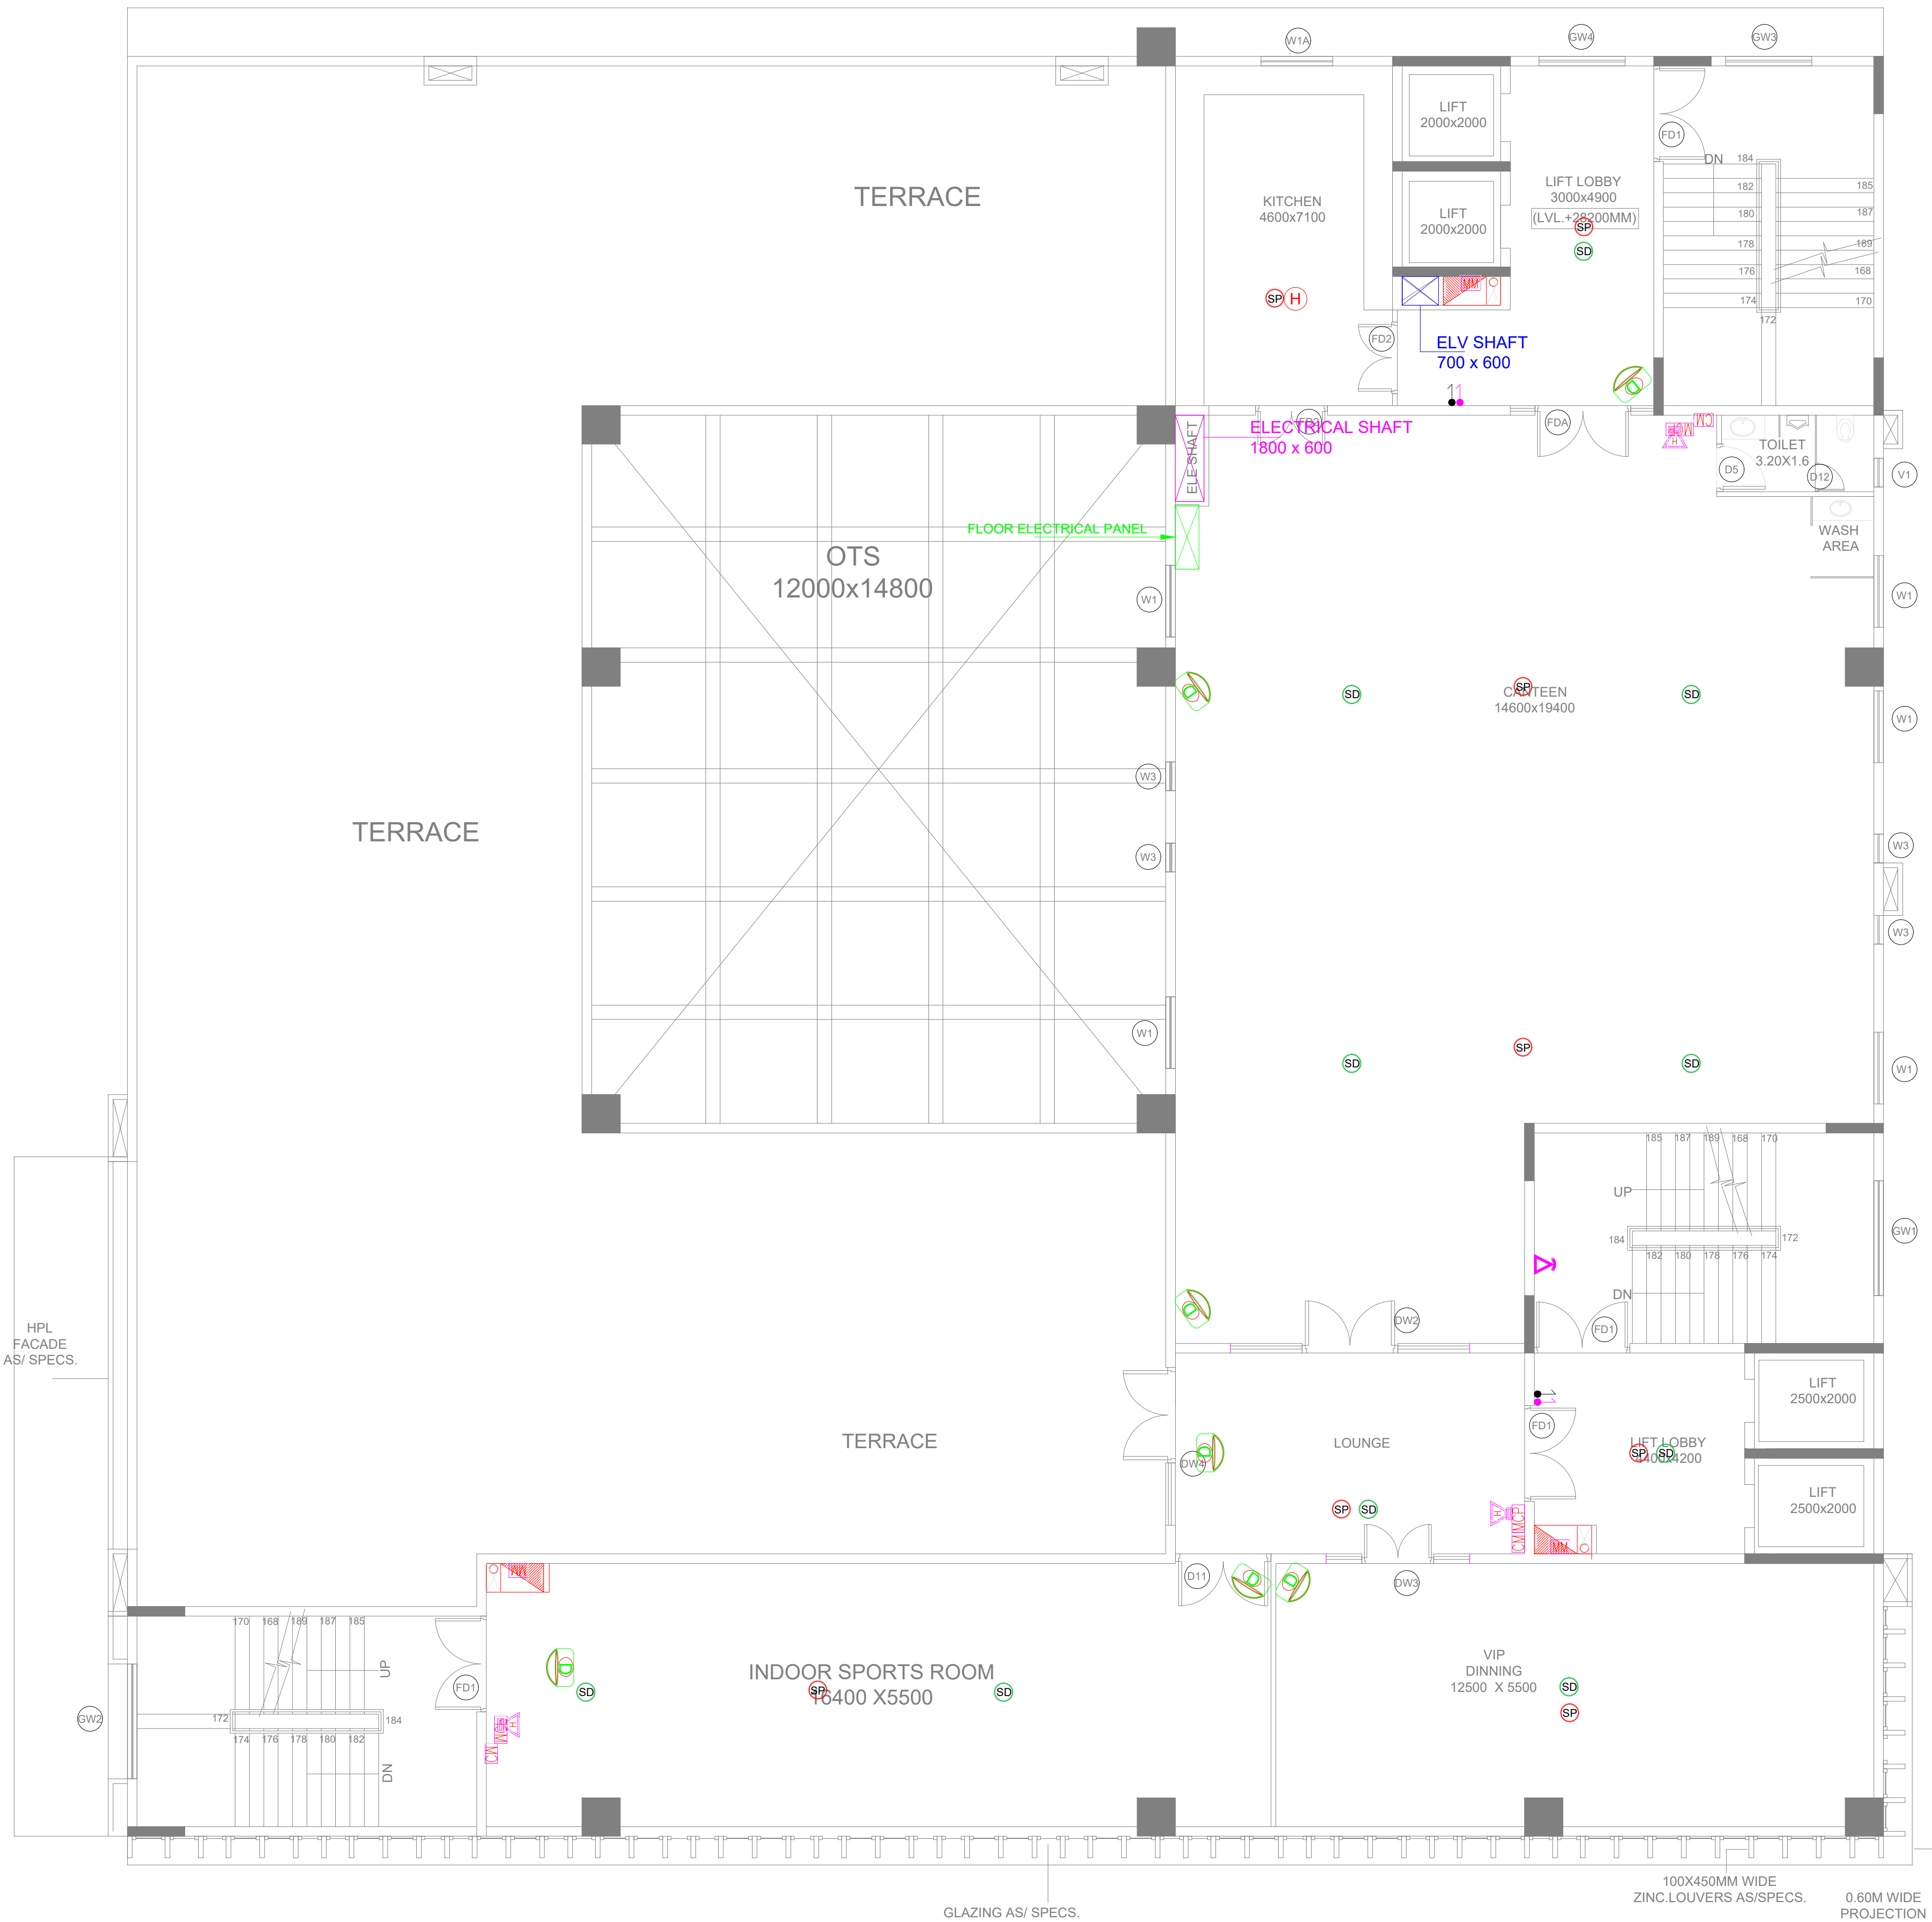

Key Plan :

Notes :

1. THIS DRAWING AND DESIGN IS THE PROPERTY OF THE DESIGNERS. NO PORTION MAY BE USED OR REPRODUCED WITHOUT THEIR WRITTEN PERMISSION.
2. THIS DRAWING IS TO BE READ IN CONJUNCTION WITH THE DESIGNERS SPECIFICATIONS AND CONDITIONS OF CONTRACT.
3. ALL DIMENSIONS ARE TO BE READ NOT SCALED.
4. ALL INDICATED LEVELS ARE FINISHED LEVELS UNLESS NOTED OTHERWISE.
5. ALL OUTER DIMENSIONS IN METER & INTERNAL DIMENSIONS IN MM.
6. PANEL LOCATION IS TENTATIVE IT MAYBE BE PLACE APPROPRIATE LOCATION AT THE TIME OF CONSTRUCTION.



PROJECT TITLE

PROPOSED CONSTRUCTION OF MULTI STOREY BUILDING FOR SBI BANK AT KALYANPUR NEAR CIRCUIT HOUSE,DEOGARH

CLIENT :-

 STATE BANK OF INDIA PATNA

ARCHITECT:-

 **D K & ASSOCIATES**
(ARCHITECTS & INTERIOR DESIGNERS)
A-385, DEFENCE COLONY, NEW DELHI - 110024.
Tel: 91-11-24333312/918 Email : dps200@gmail.com

DRAWING STAGE:-

TENDER DRAWING

MEP - CONSULTANT

 **AD CONSULTANTS**
C-419, 4th Floor Vipul Plaza | Email: info@adconsultants.co.in
Sector-31 Faridabad-121002 | website: www.adconsultants.co.in
HARYANA INDIA | Ph: +91-9811-662885

draff: **ATUL PANDEY**

checked: **MOHAN SHARMA**

DRAWING TITLE:-


**EIGHT FLOOR PLAN
FIRE ALARM _ PA _ WIFI &
CCTV LAYOUT**

SCALE	ARCH./ENGR.:	DATE	REV.
A1 SHEET:- A2 SHEET:- A3 SHEET:-	DRAWN KAMLESH CHECKED GURPREET	04-03-2025 APPROVED	R1

DRAWING NO.
DKA/SBI/TD/EL/EIGHTH-03



LPDB-1
UDB-1
LPDB-2
UDB-2

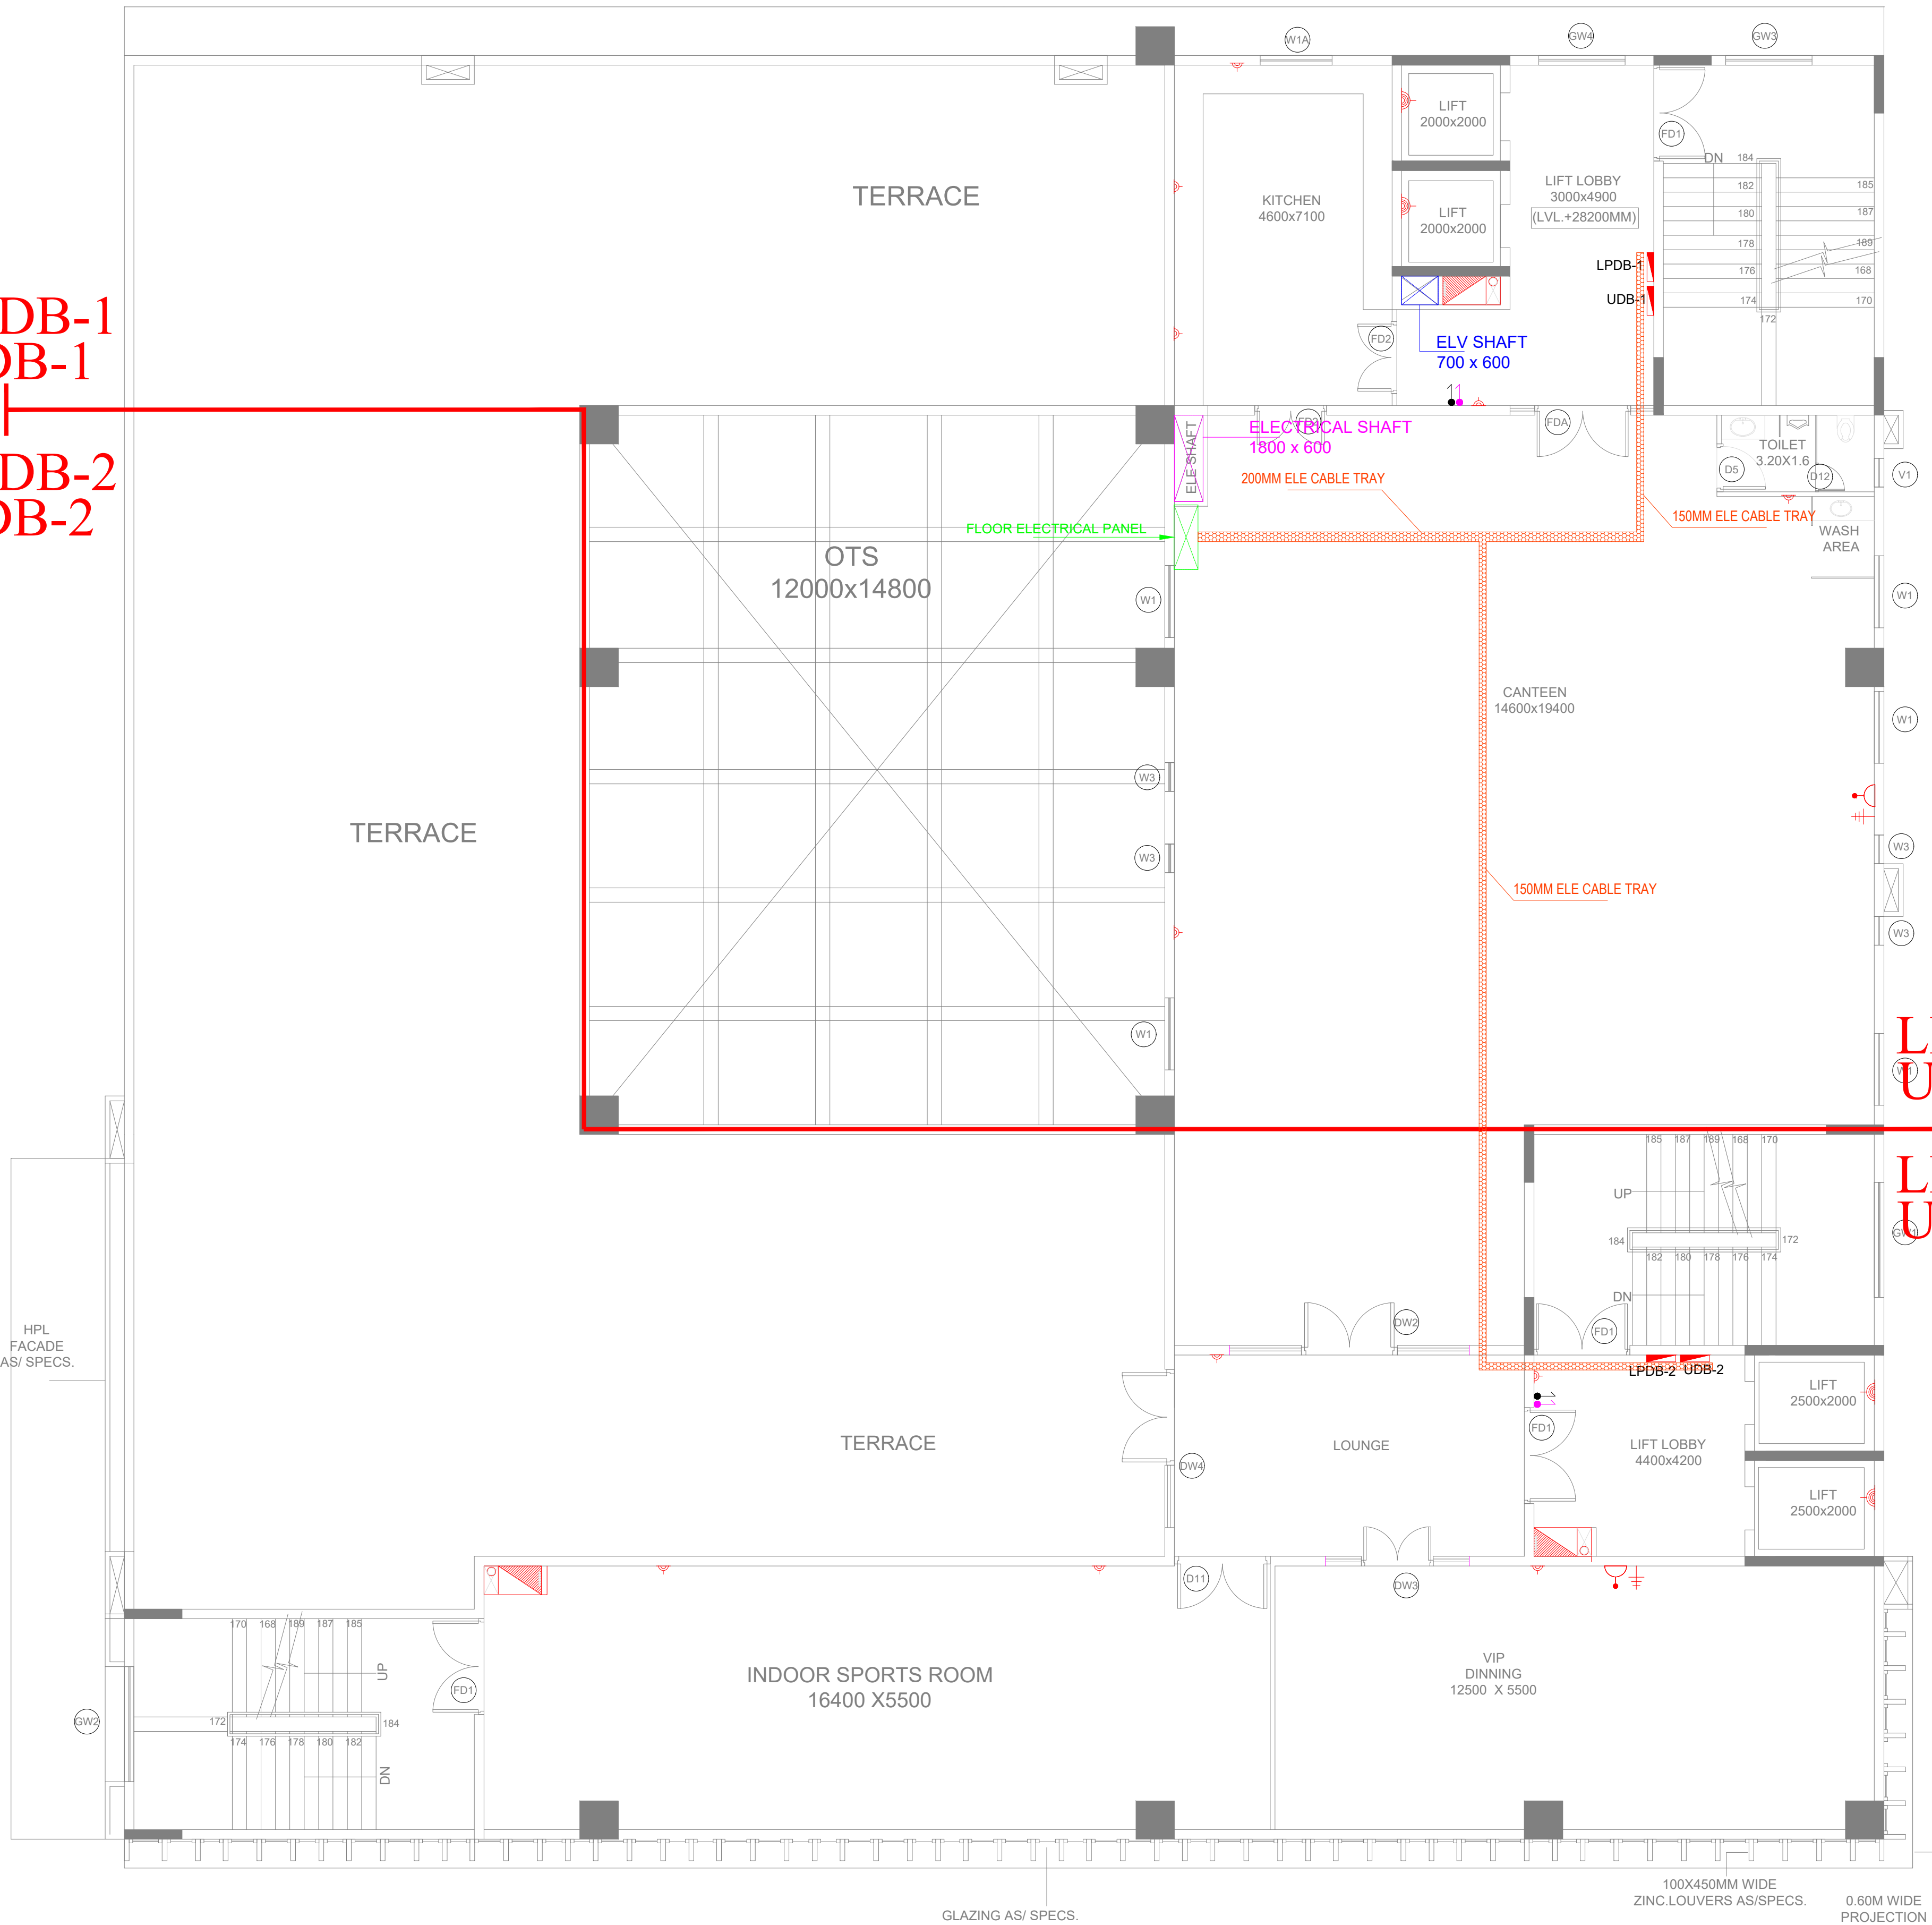

LPDB-1
UDB-1
LPDB-2
UDB-2

Key Plan :

Notes :

1. THIS DRAWING AND DESIGN IS THE PROPERTY OF THE DESIGNERS. NO PORTION MAY BE USED OR REPRODUCED WITHOUT THEIR WRITTEN PERMISSION.
2. THIS DRAWING IS TO BE READ IN CONJUNCTION WITH THE DESIGNERS SPECIFICATIONS AND CONDITIONS OF CONTRACT.
3. ALL DIMENSIONS ARE TO BE READ NOT SCALED.
4. ALL INDICATED LEVELS ARE FINISHED LEVELS UNLESS NOTED OTHERWISE.
5. ALL OUTER DIMENSIONS IN METER & INTERNAL DIMENSIONS IN MM.
6. PANEL LOCATION IS TENTATIVE IT MAYBE BE PLACE APPROPRIATE LOCATION AT THE TIME OF CONSTRUCTION.



PROJECT TITLE

PROPOSED CONSTRUCTION OF MULTI STOREY BUILDING FOR SBI BANK AT KALYANPUR NEAR CIRCUIT HOUSE, DEOGARH

CLIENT :-

SBI STATE BANK OF INDIA PATNA

ARCHITECT:-

D K & ASSOCIATES
(ARCHITECTS & INTERIOR DESIGNERS)
A-385, DEFENCE COLONY, NEW DELHI - 110024
Tel: 91-11-24333312/918 Email : dps200@gmail.com

DRAWING STAGE:-

TENDER DRAWING

MEP - CONSULTANT

AD CONSULTANTS
C-419, 4th Floor Vipul Plaza | Email: info@adconsultants.co.in
Sector-31 Faridabad-121002 | website: www.adconsultants.co.in
HARYANA INDIA | Ph. +91-9811-662885

draff: **ATUL PANDEY**

checked: **MOHAN SHARMA**



DRAWING TITLE:-

EIGHT FLOOR PLAN
POWER LAYOUT


SCALE	ARCH./ENGR.:	DATE	REV.
A1 SHEET:- A2 SHEET:- A3 SHEET:-	DRAWN KAMLESH CHECKED GURPREET	04-03-2025 APPROVED	R1

 DRAWING NO.
DKA/SBI/TD/EL/EIGHTH-02

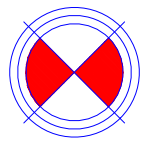

SYMBOL	L E G E N D – E L E C T R I C A L
	DESCRIPTION
	30W LED STREET LIGHT 7 METER HIGH POLE
	30W GATE LIGHT
	FEEDER PILLAR

 POWER LEGEND:-

SYMBOL	DESCRIPTION	HEIGHT FROM F.F.L.
	6A SWITCH WITH SOCKET ON RAW POWER	1050 MM
	16A SWITCH WITH SOCKET ON RAW POWER	400 MM
	16A SOCKET ON RAW POWER FOR LIFT	AS PER SITE
	2NO 6A SWITCH WITH SOCKET ON RAW POWER	900 MM
	TV OUTLET + DATA OUTLET	900 MM
	SINGLE PHASE INDUSTRIAL SOCKET ON RAW POWER	AS PER SITE
	6/16A SWITCH WITH SOCKET ON UPS	CEILING
	TELEPHONE OUTLET	AS PER SITE
	6A SWITCH WITH SOCKET ON UPS	600
	DATA OUTLET	AS PER SITE
	PROJECTOR POINT	CEILING
	HDMI POINT	CEILING
	2 NOS. 6A SWITCH WITH SOCKET ON UPS 1 NOS. 6A SWITCH WITH SOCKET ON RAW 1 NOS. DATA OUTLET	600 MM / AS PER SITE
	DISTRIBUTION BOARD	1800 MM

LIGHTING LEGEND:-

SYMBOL	DESCRIPTION	HEIGHT FROM F.F.L.
	NORMAL LIGHT SWITCH BOARD	1050 MM
	EMERGENCY LIGHT SWITCH BOARD	1050 MM
	2X2 36W EMERGENCY LED LIGHT	CEILING
	2X2 36W LED LIGHT	CEILING
	10W LED DOWN LIGHT	CEILING
	1200MM CEILING FAN	CEILING
	18W LED DOWN LIGHT	CEILING
	11W MIRROR LIGHT	2100 MM
	20W BATTEN TUBE LIGHT	CEILING
	20W WALL MOUNTED TUBE LIGHT	2100 MM
	18W WALL BRACKET LIGHT	2100 MM
	BULKHEAD LIGHT	AS PER SITE
	12W LED DOWN LIGHT	CEILING
	EXIT LIGHT	CEILING
	DISTRIBUTION BOARD	1800MM

FIRE ALARM _ PA _ WIFI & CCTV LEGEND:-

SYMBOL	DESCRIPTION	HEIGHT FROM F.F.L.
	SMOKE DETECTOR	CEILING
	HEAT DETECTOR	CEILING
	CEILING SPEAKER	CEILING
	SOUND SPEAKER	2100MM
	HOOTER	2100 MM
	CONTROL MODULE	1050 MM
	MANUAL CALL POINT	1050 MM
	MONITOR MODULE	AS PER SITE
	DATA POINT FOR WIFI	CEILING
	DOME CAMERA	CEILING
	BULLET CAMERA	AS PER SITE
	TELEPHONE OUTLET	AS PER SITE
	DATA OUTLET	CEILING
	PROJECTOR POINT	CEILING
	HDMI POINT	CEILING
	EXIT LIGHT	CEILING
	FIRE ALARM CONTROL PANEL	
	AMPLIFIER	

LEGEND:-

	25 MM ø CONDUIT FOR DATA & TELEPHONE IN FLOOR
	25 MM ø CONDUIT FOR RAW POWER IN FLOOR
	RACEWAY IN FLOOR FOR DATA & VOICE
	RACEWAY IN FLOOR FOR RAW & UPS P.
	JUNCTION BOX FOR DATA & VOICE
	JUNCTION BOX FOR RAW & UPS POWER
	CABLE TRAY IN CEILING FOR POWER

Key Plan :

Notes :

1. THIS DRAWING AND DESIGN IS THE PROPERTY OF THE DESIGNERS. NO PORTION MAY BE USED OR REPRODUCED WITHOUT THEIR WRITTEN PERMISSION.
2. THIS DRAWING IS TO BE READ IN CONJUNCTION WITH THE DESIGNERS SPECIFICATIONS AND CONDITIONS OF CONTRACT.
3. ALL DIMENSIONS ARE TO BE READ NOT SCALED.
4. ALL INDICATED LEVELS ARE FINISHED LEVELS UNLESS NOTED OTHERWISE.
5. ALL OUTER DIMENSIONS IN METER & INTERNAL DIMENSIONS IN MM.
6. PANEL LOCATION IS TENTATIVE IT MAYBE BE PLACE APPROPRIATE LOCATION AT THE TIME OF CONSTRUCTION.



PROJECT TITLE

PROPOSED CONSTRUCTION OF MULTI STOREY BUILDING FOR SBI BANK AT KALYANPUR NEAR CIRCUIT HOUSE,DEOGARH

CLIENT :-

 STATE BANK OF INDIA PATNA

ARCHITECT:-

 **D K & ASSOCIATES**
(ARCHITECTS & INTERIOR DESIGNERS)
A-385, DEFENCE COLONY, NEW DELHI - 110024
Tel: 91-11-24333312/918 Email : dps200@gmail.com

DRAWING STAGE:-

TENDER DRAWING

MEP - CONSULTANT

 **AD CONSULTANTS**
C-419, 4th Floor Vipul Plaza | Email: info@adconsultants.co.in
Sector-31 Faridabad-121002 | website: www.adconsultants.co.in
HARYANA INDIA | Ph. +91-9811-662885

drawn: **ATUL PANDEY**

checked: **MOHAN SHARMA**


DRAWING TITLE:-

ELECTRICAL LEGEND

SCALE	ARCH./ENGR.:	DATE	REV.
A1 SHEET:- A2 SHEET:- A3 SHEET:-	DRAWN KAMLESH CHECKED GURPREET	04-03-2025 APPROVED	R1

DRAWING NO.
DKA/SBI/TD/EL/ELEGEND-01



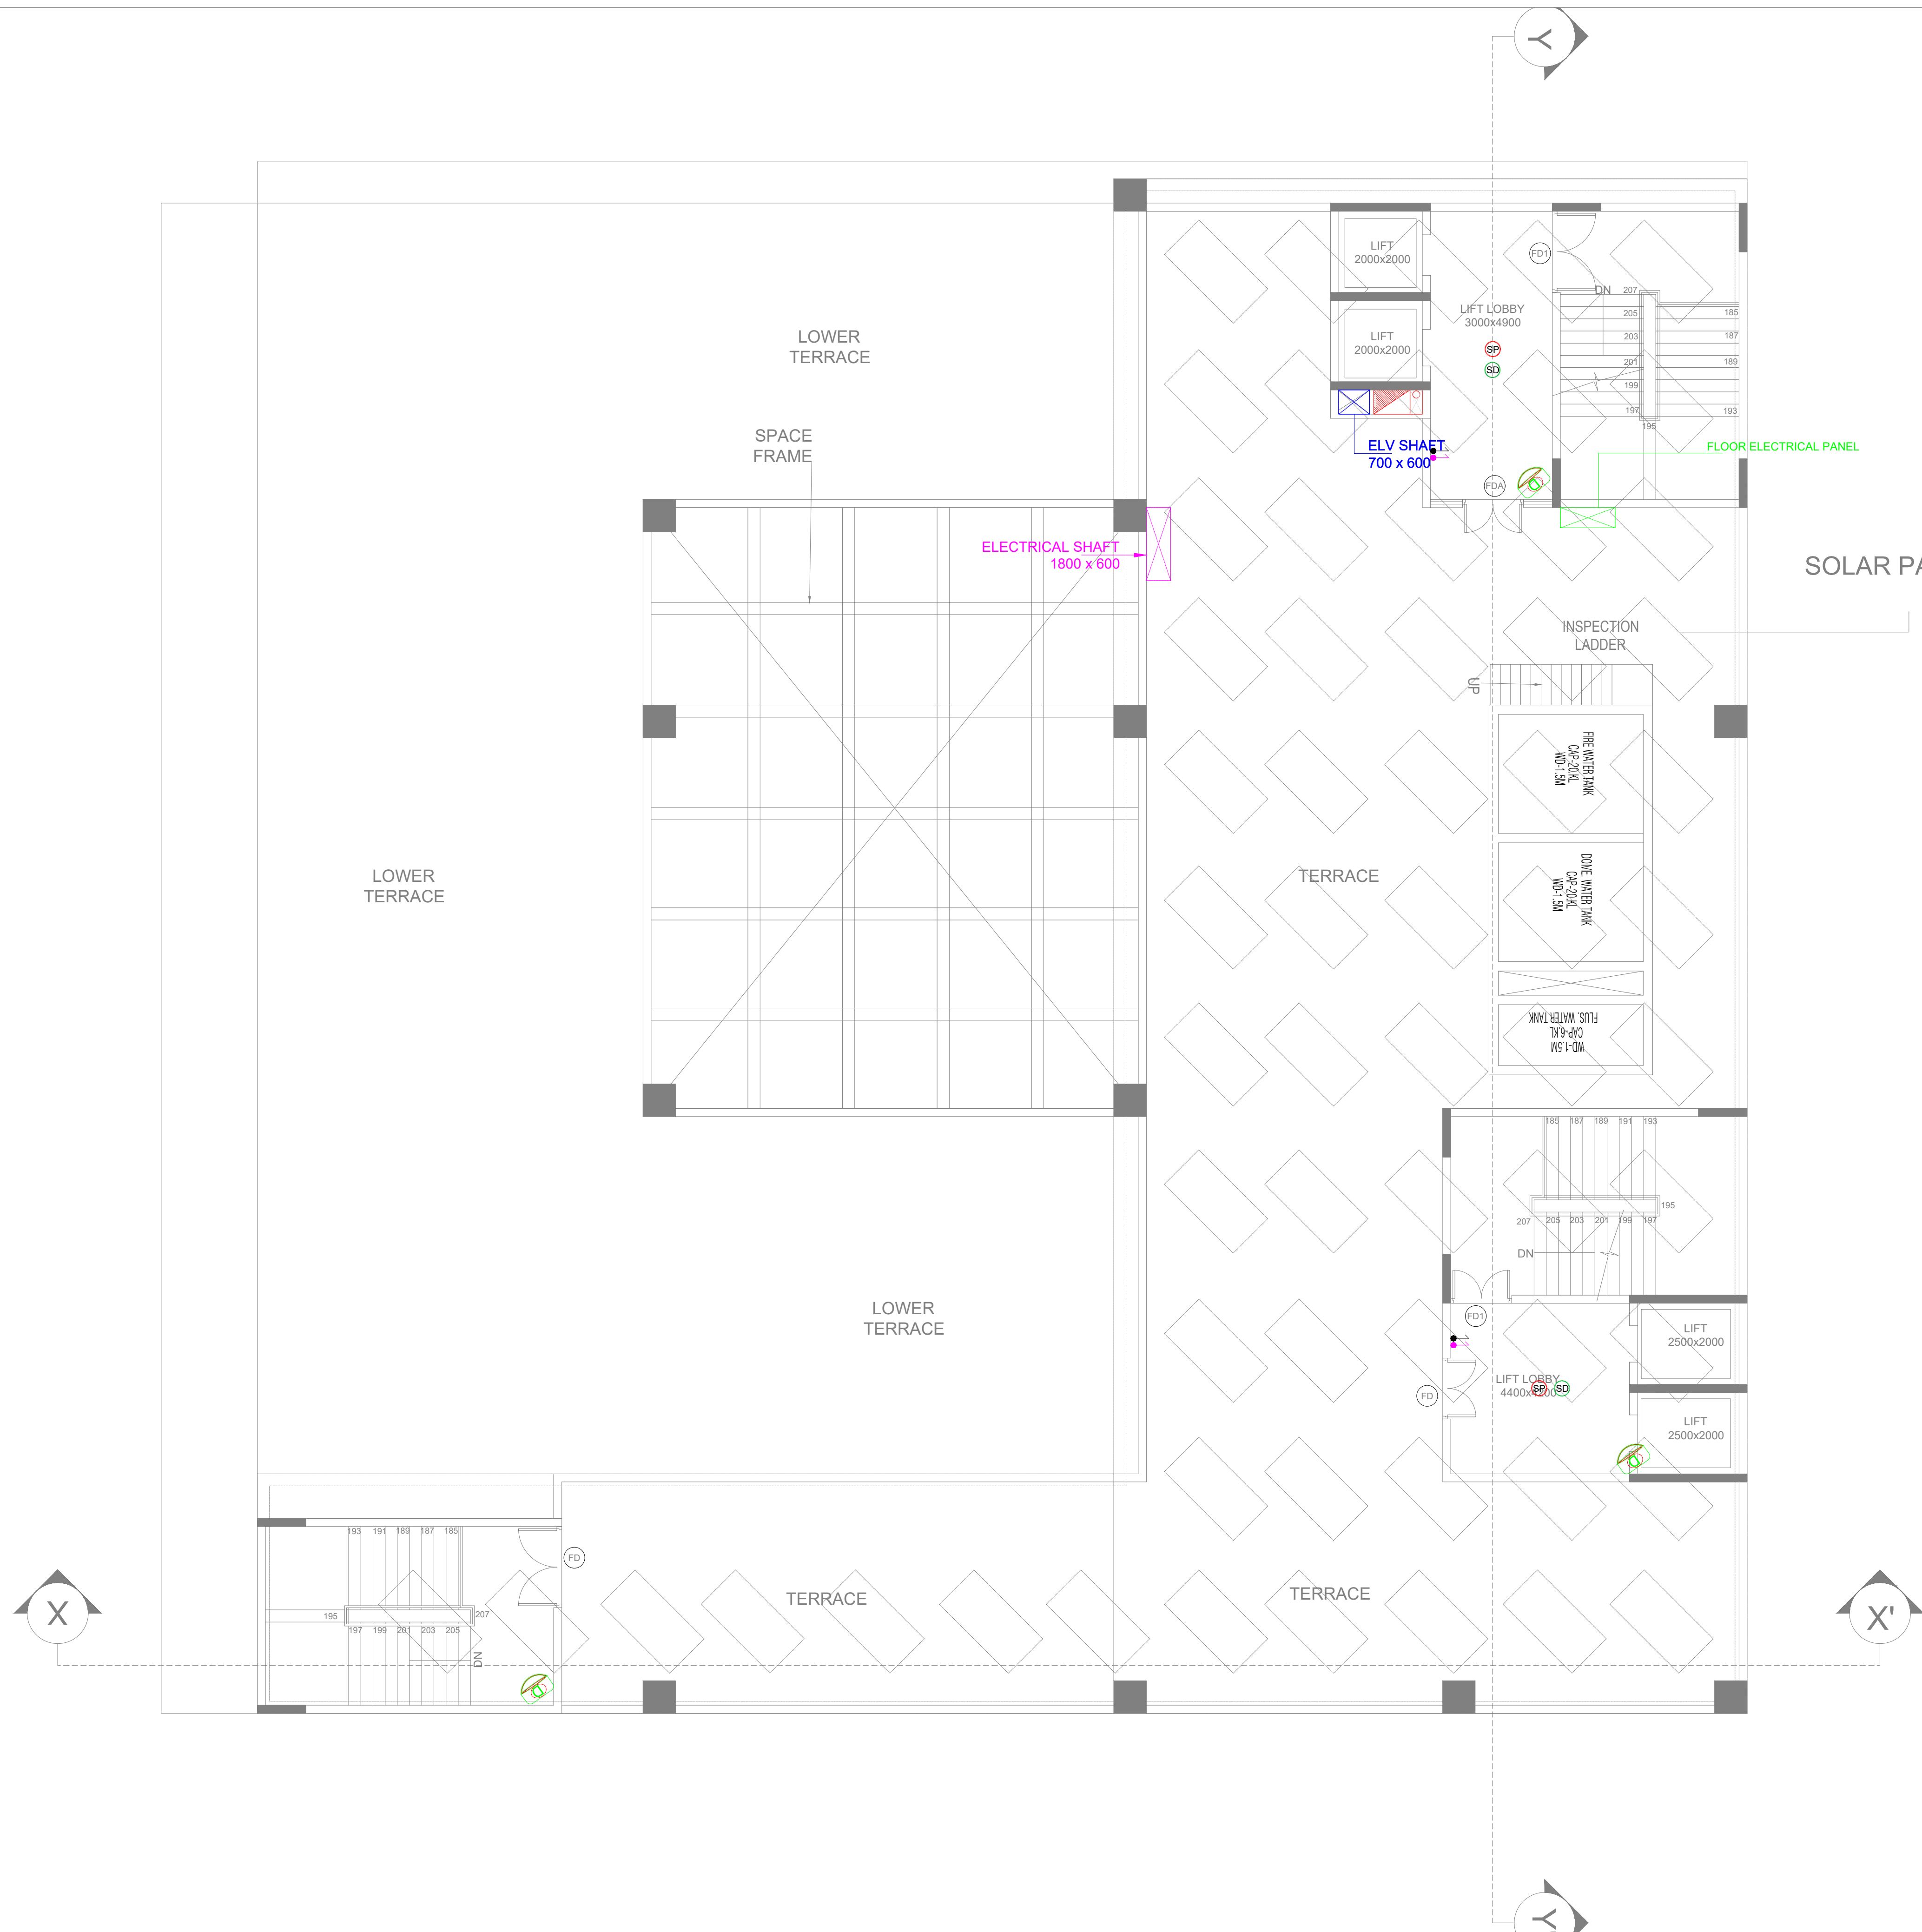

Key Plan :

Notes :

1. THIS DRAWING AND DESIGN IS THE PROPERTY OF THE DESIGNERS. NO PORTION MAY BE USED OR REPRODUCED WITHOUT THEIR WRITTEN PERMISSION.
2. THIS DRAWING IS TO BE READ IN CONJUNCTION WITH THE DESIGNERS SPECIFICATIONS AND CONDITIONS OF CONTRACT.
3. ALL DIMENSIONS ARE TO BE READ NOT SCALED.
4. ALL INDICATED LEVELS ARE FINISHED LEVELS UNLESS NOTED OTHERWISE.
5. ALL OUTER DIMENSIONS IN METER & INTERNAL DIMENSIONS IN MM.
6. PANEL LOCATION IS TENTATIVE IT MAYBE BE PLACE APPROPRIATE LOCATION AT THE TIME OF CONSTRUCTION.



PROJECT TITLE

PROPOSED CONSTRUCTION OF MULTI STOREY BUILDING FOR SBI BANK AT KALYANPUR NEAR CIRCUIT HOUSE,DEOGARH

CLIENT :-

SBI STATE BANK OF INDIA PATNA

ARCHITECT:-

D K & ASSOCIATES
(ARCHITECTS & INTERIOR DESIGNERS)
A-385, DEFENCE COLONY, NEW DELHI - 110024.
Tel: 91-11-24333312/918 Email : dps200@gmail.com

DRAWING STAGE:-

TENDER DRAWING

MEP - CONSULTANT

AD CONSULTANTS
C-419, 4th Floor Vipul Plaza | Email: info@adconsultants.co.in
Sector-31 Faridabad-121002 | website: www.adconsultants.co.in
HARYANA INDIA | Ph: +91-9811-662885

drawn: ATUL PANDEY

checked: MOHAN SHARMA


DRAWING TITLE:-

TERRACE FLOOR PLAN
FIRE ALARM _ PA _ WIFI &
CCTV LAYOUT

SCALE	ARCH./ENGR.:	DATE	REV.
A1 SHEET:- A2 SHEET:- A3 SHEET:-	DRAWN KAMLESH CHECKED GURPREET	04-03-2025 APPROVED	R1

DRAWING NO.
DKA/SBI/TD/EL/TERRACE-03



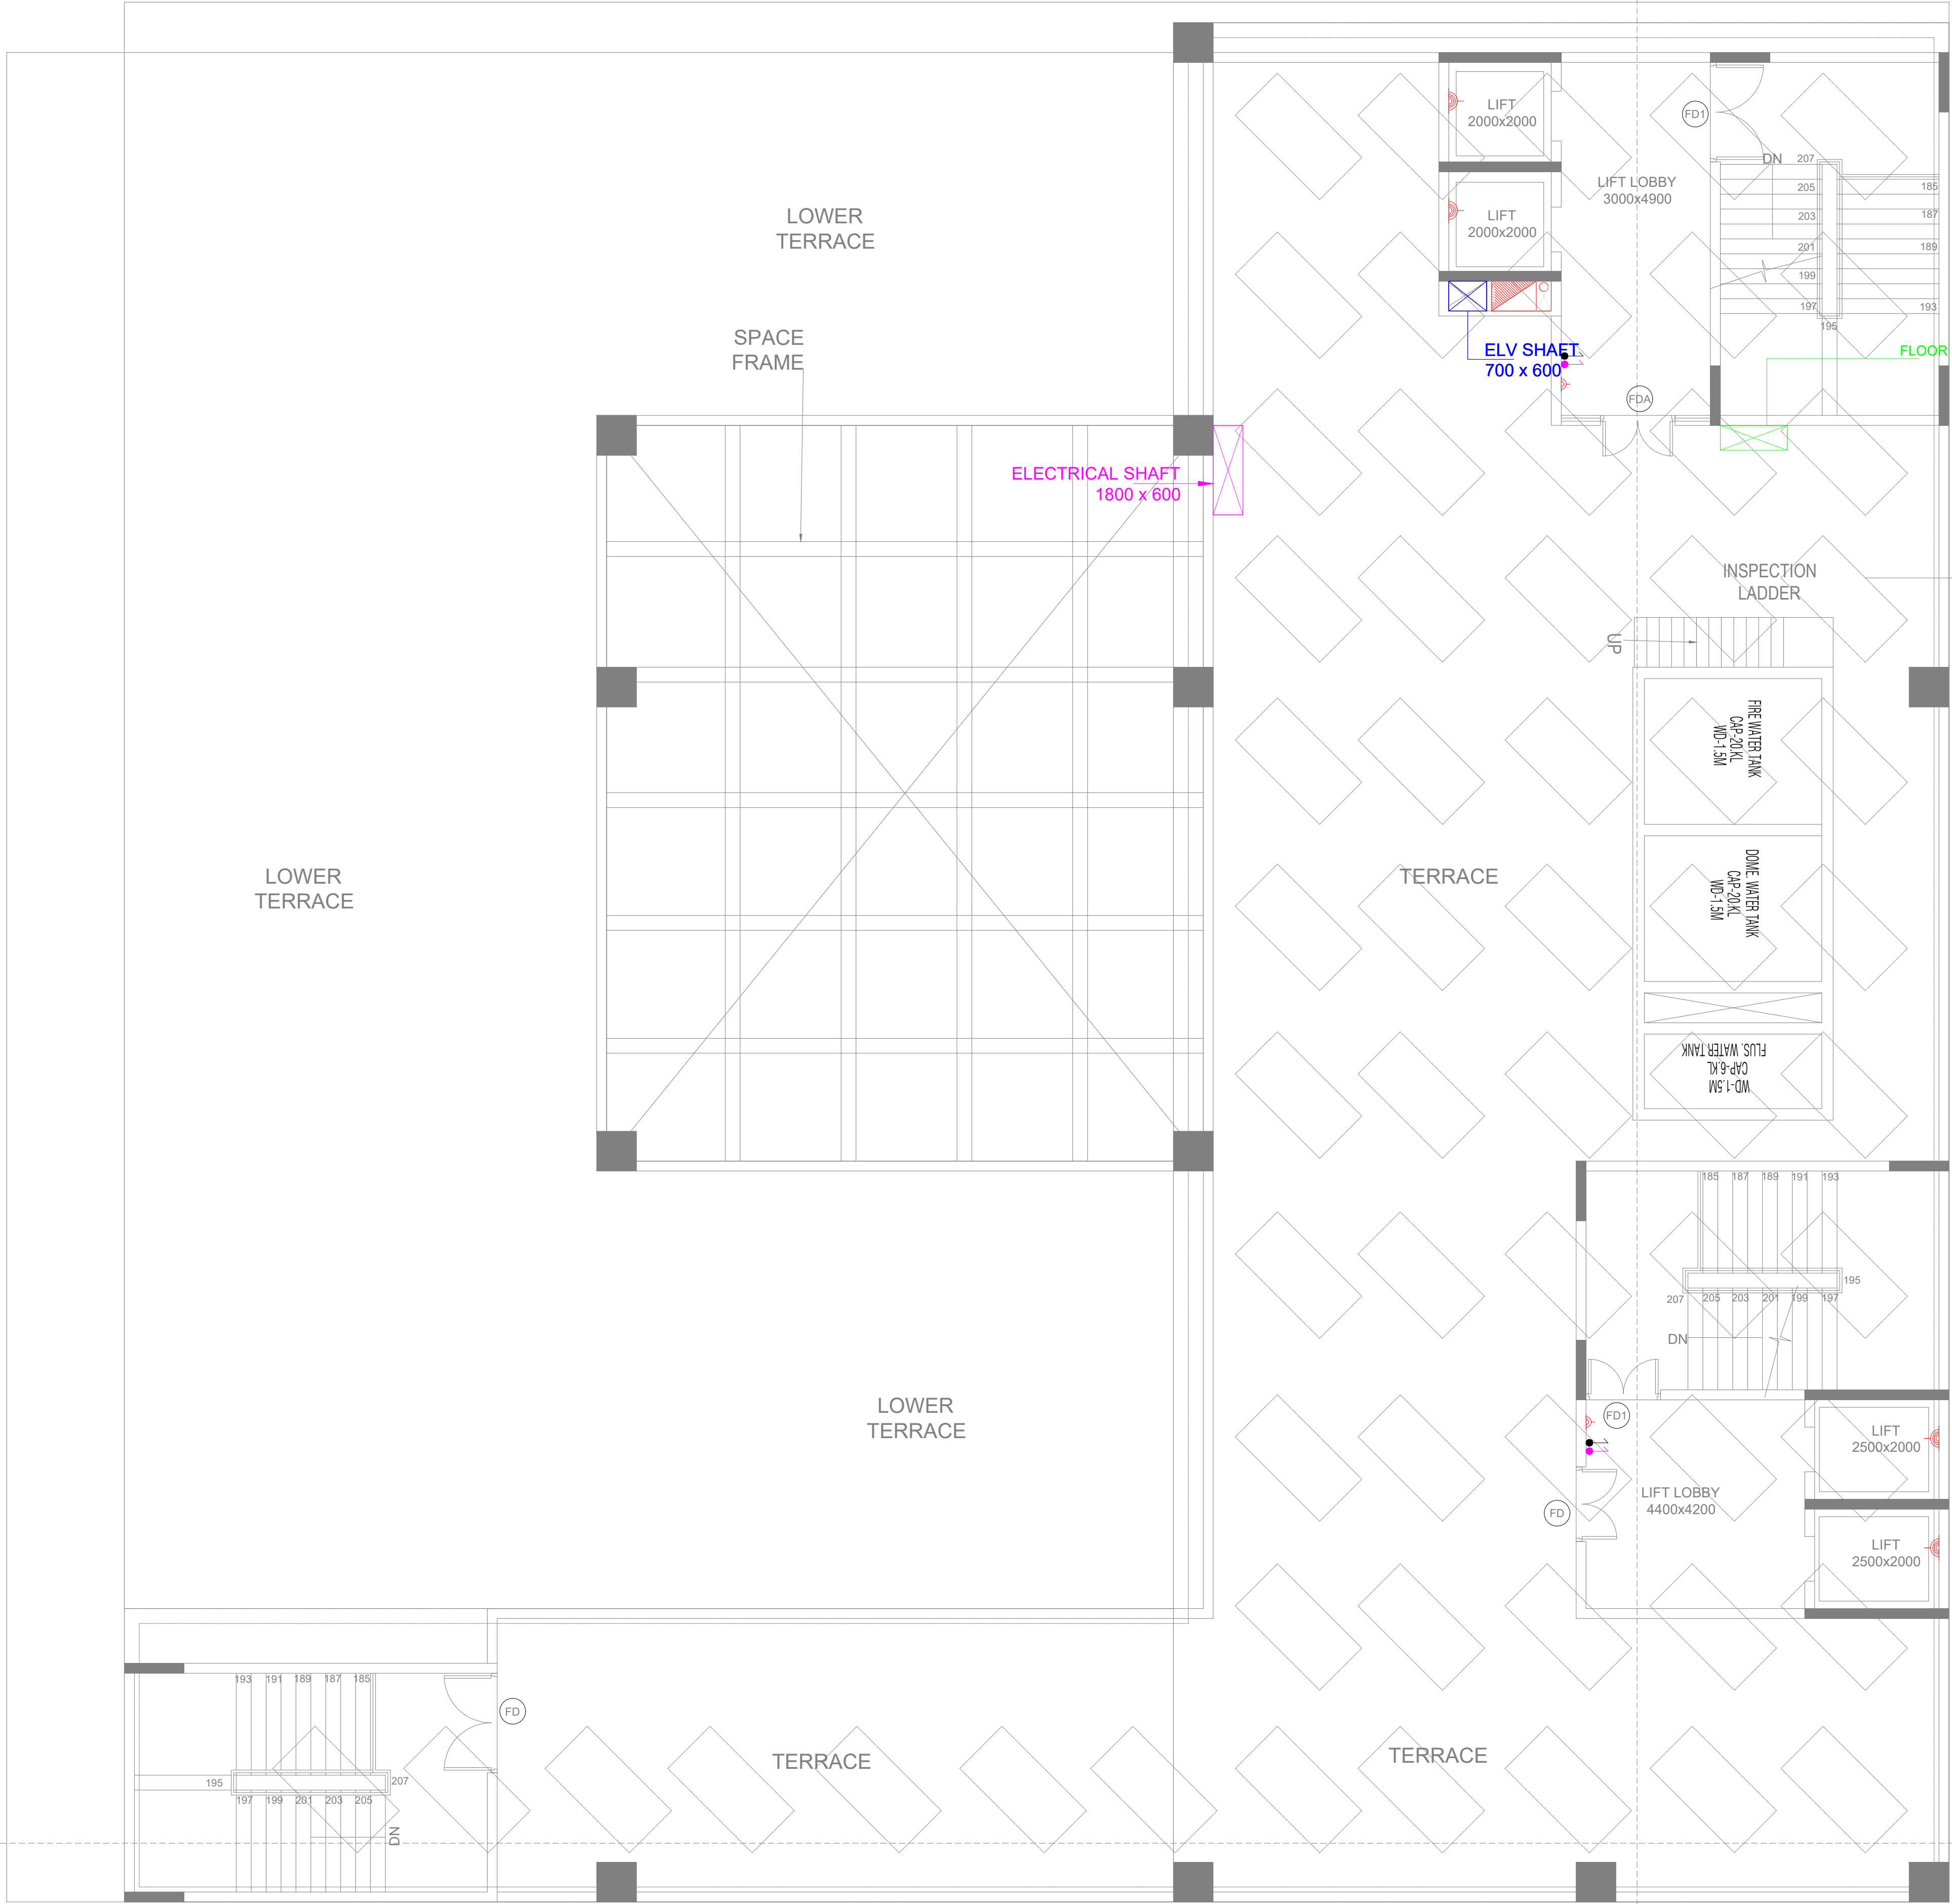

Key Plan :

Notes :

1. THIS DRAWING AND DESIGN IS THE PROPERTY OF THE DESIGNERS. NO PORTION MAY BE USED OR REPRODUCED WITHOUT THEIR WRITTEN PERMISSION.
2. THIS DRAWING IS TO BE READ IN CONJUNCTION WITH THE DESIGNERS SPECIFICATIONS AND CONDITIONS OF CONTRACT.
3. ALL DIMENSIONS ARE TO BE READ NOT SCALED.
4. ALL INDICATED LEVELS ARE FINISHED LEVELS UNLESS NOTED OTHERWISE.
5. ALL OUTER DIMENSIONS IN METER & INTERNAL DIMENSIONS IN MM.
6. PANEL LOCATION IS TENTATIVE IT MAYBE BE PLACE APPROPRIATE LOCATION AT THE TIME OF CONSTRUCTION.



PROJECT TITLE

PROPOSED CONSTRUCTION OF MULTI STOREY BUILDING FOR SBI BANK AT KALYANPUR NEAR CIRCUIT HOUSE,DEOGARH

CLIENT :-

STATE BANK OF INDIA PATNA

ARCHITECT:-

D K & ASSOCIATES
(ARCHITECTS & INTERIOR DESIGNERS)
A-385, DEFENCE COLONY, NEW DELHI - 110024
Tel: 91-11-24333312/918 Email : dps200@gmail.com

DRAWING STAGE:-

TENDER DRAWING

MEP - CONSULTANT

AD CONSULTANTS
C-419, 4th Floor Vipul Plaza | Email: info@adconsultants.co.in
Sector-31 Faridabad-121002 | Website: www.adconsultants.co.in
HARYANA INDIA | Ph: +91-9811-662885

draff: **ATUL PANDEY**

checked: **MOHAN SHARMA**

DRAWING TITLE:-

TERRACE FLOOR PLAN
POWER LAYOUT

SCALE	ARCH./ENGR.:	DATE	REV.
A1 SHEET:- A2 SHEET:- A3 SHEET:-	DRAWN KAMLESH CHECKED GURPREET	04-03-2025 APPROVED	R1

DRAWING NO.
DKA/SBI/TD/EL/TERRACE-02



