






GROUND FLOOR PLAN
SBILD(HOSTEL BLOCK)
(BLOCK-C)

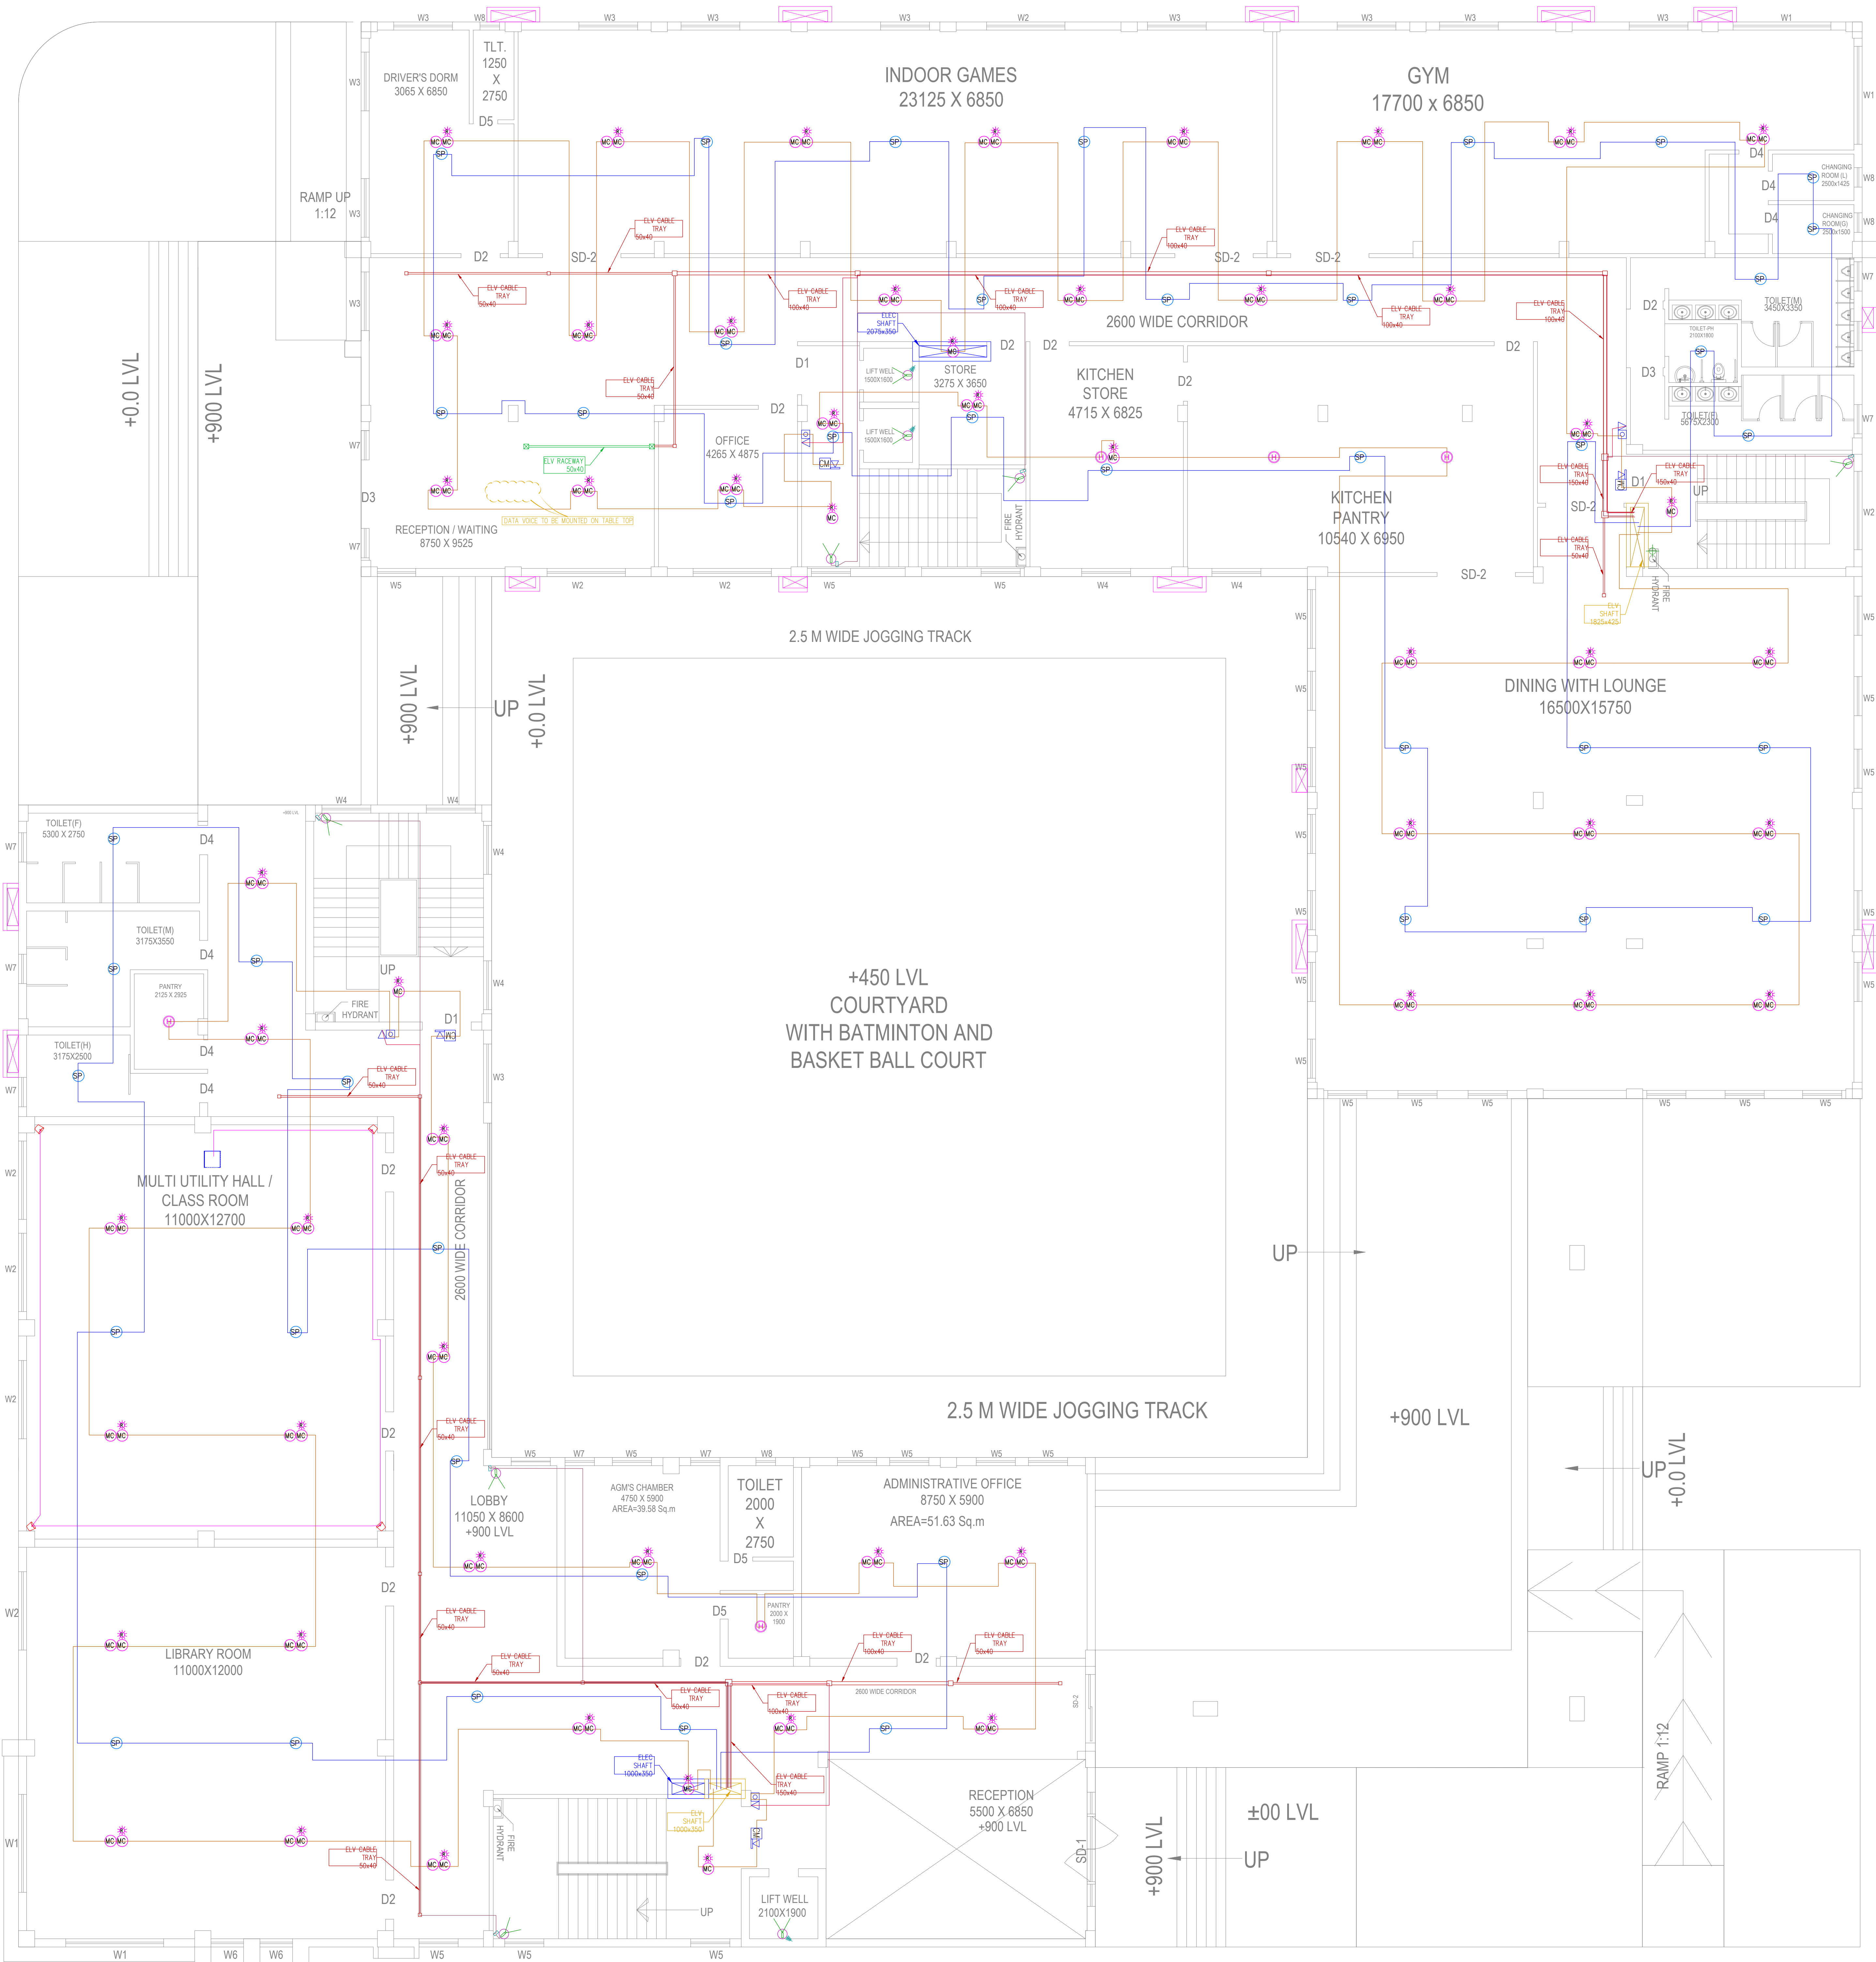

GROUND FLOOR PLAN
SBILD(ADMINISTRATIVE BLOCK)
(BLOCK-B)

LEGEND:-

01.	MC	MULTI-CRITERIA DETECTOR ABOVE FALSE CEILING
02.	MC	MULTI-CRITERIA DETECTOR BELOW FALSE CEILING
03.	SP	CEILING SPEAKER
04.	HO	HOOTER
05.	MC	MANUAL CALL POINT
06.	TV	TALK BACK UNIT
07.	CM	CONTROL MODULE FOR HOOTER
08.	SP	SURFACE MOUNT SPEAKER
09.	SP	INDOOR FIXED DOME CCTV
10.	SP	WIRELESS CCTV
11.	SP	CABLE TRAY
12.	SP	RACE WAY
13.	SP	84" DIAGONAL MOTORISED SCREEN
14.	SP	PROJECTOR
15.	SP	AV EQUIPMENT STORAGE
16.	SP	FLOOR BOX
17.	SP	HEAT DETECTOR
18.	SP	SMOKE DETECTOR
19.	SP	CONTROL RELAY MODULE
20.	SP	MONITOR MODULE

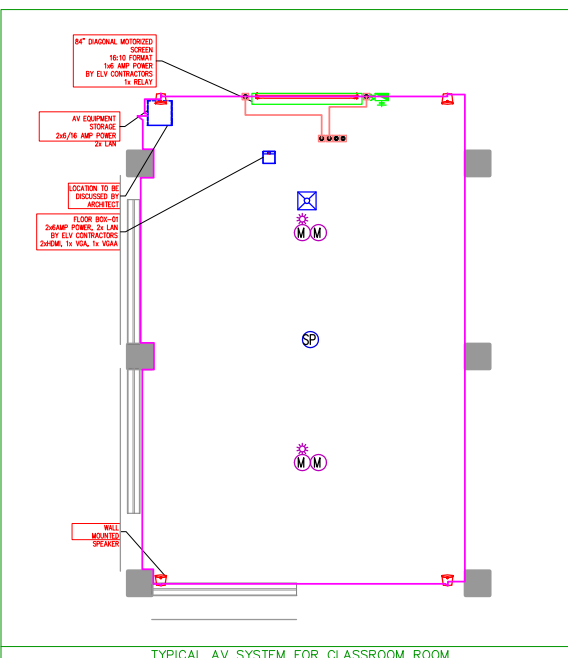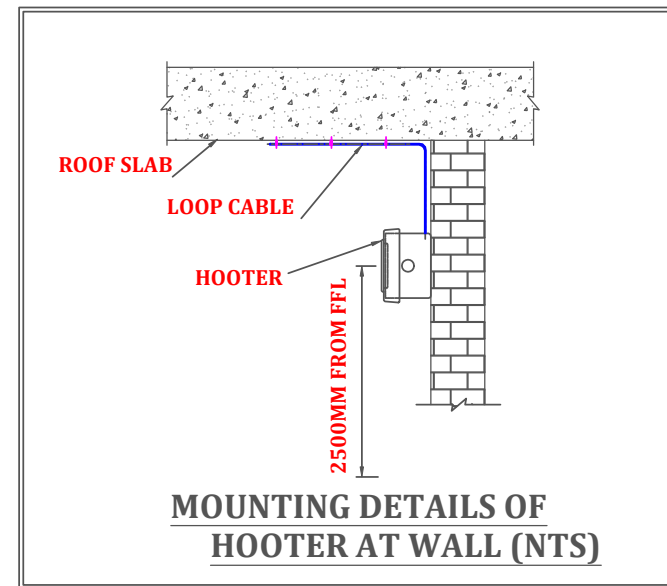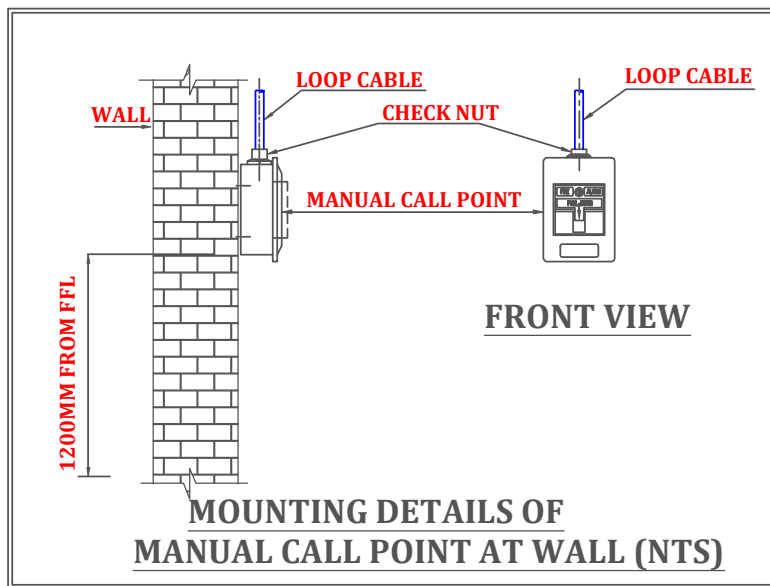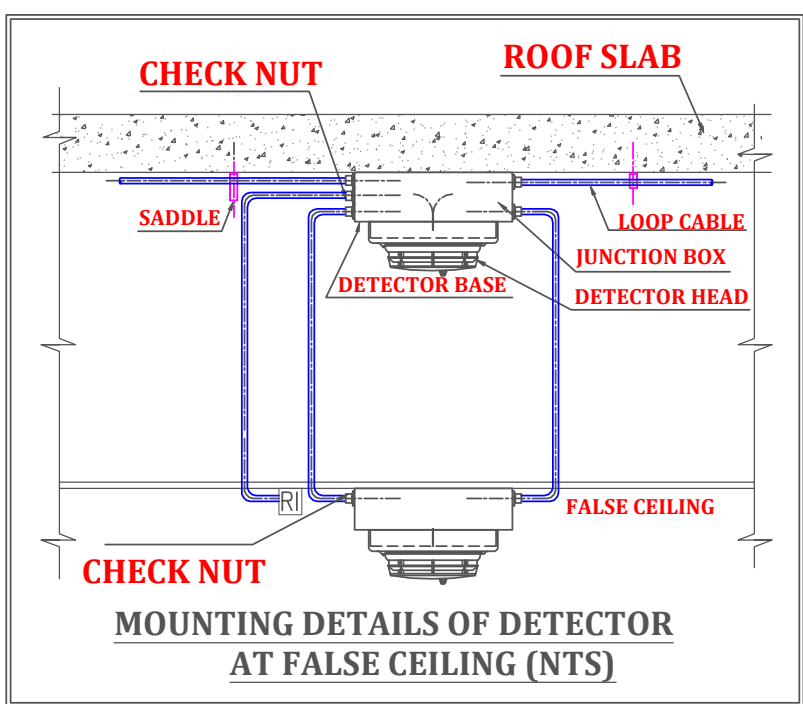

CABLE LEGEND:-

01.	FAS CABLE (FIRE ALARM ARMoured CABLE 2 CORE 2X1.5 SQMM)
02.	FAS CABLE (SPEAKER CABLE SINGLE PAIR, 2 CORE, 1.5 SQMM)
03.	CCTV CABLE (CAT16A)
04.	TALK BACK UNIT CABLE (SPEAKER CABLE SINGLE PAIR, 2 CORE, 1.5 SQMM)
05.	BOM CABLE (LOUDSPEAKER CABLE SINGLE PAIR, 2 CORE, 1.5 SQMM)

ARCHITECT:
MISHRA & MISHRA CONSULTANCY
SERVICES PVT. LTD.
FD-396, SECTOR - III, SALT LAKE CITY, KOLKATA-700106
PH: 4004 5307, email : umes_nmcs_2006@yahoo.co.in
website : www.mnmcdesign.co

PROJECT :
PROPOSED TWO STORIED AO & RBO AND THREE STORIED SBILD BANK'S BUILDING OF
STATE BANK OF INDIA AT MAHATMA GANDHI AVENUE, KHATIAN NO-44, L.R PLOT
NO-18(P), C.S PLOT NO:-272(P), 340(P), 341(P), 342(P), 343, 344, 345(P), 346, 347, 348, 349,
350(P), 352, 353(P), 354(P), 355(P), 356(P), 357(P), 501(P), OF MOUZA - FARIDPUR, P.S
-DURGAPUR, J.L NO-74, DIST-PASCHIM BARDHAMAN, WEST BENGAL, PIN-713216.

CLIENT :
STATE BANK OF INDIA



04		
03		
02		
01		
REV. NO.	DESCRIPTION	DATE
REVISIONS		
DATE	02.01.2026	DRAWING TITLE:
DRAWN	RP	ELV LAYOUT FOR GROUND FLOOR
CHECKED	SD	BLOCK B & C
APPRD.	JD	Drawing No.
JOB NO	468	SAN 468/ELV-02
SCALE	1:75	REV. SHEET
STATUS	DESIGN	NO. SIZE
		R0 1/1 A0