
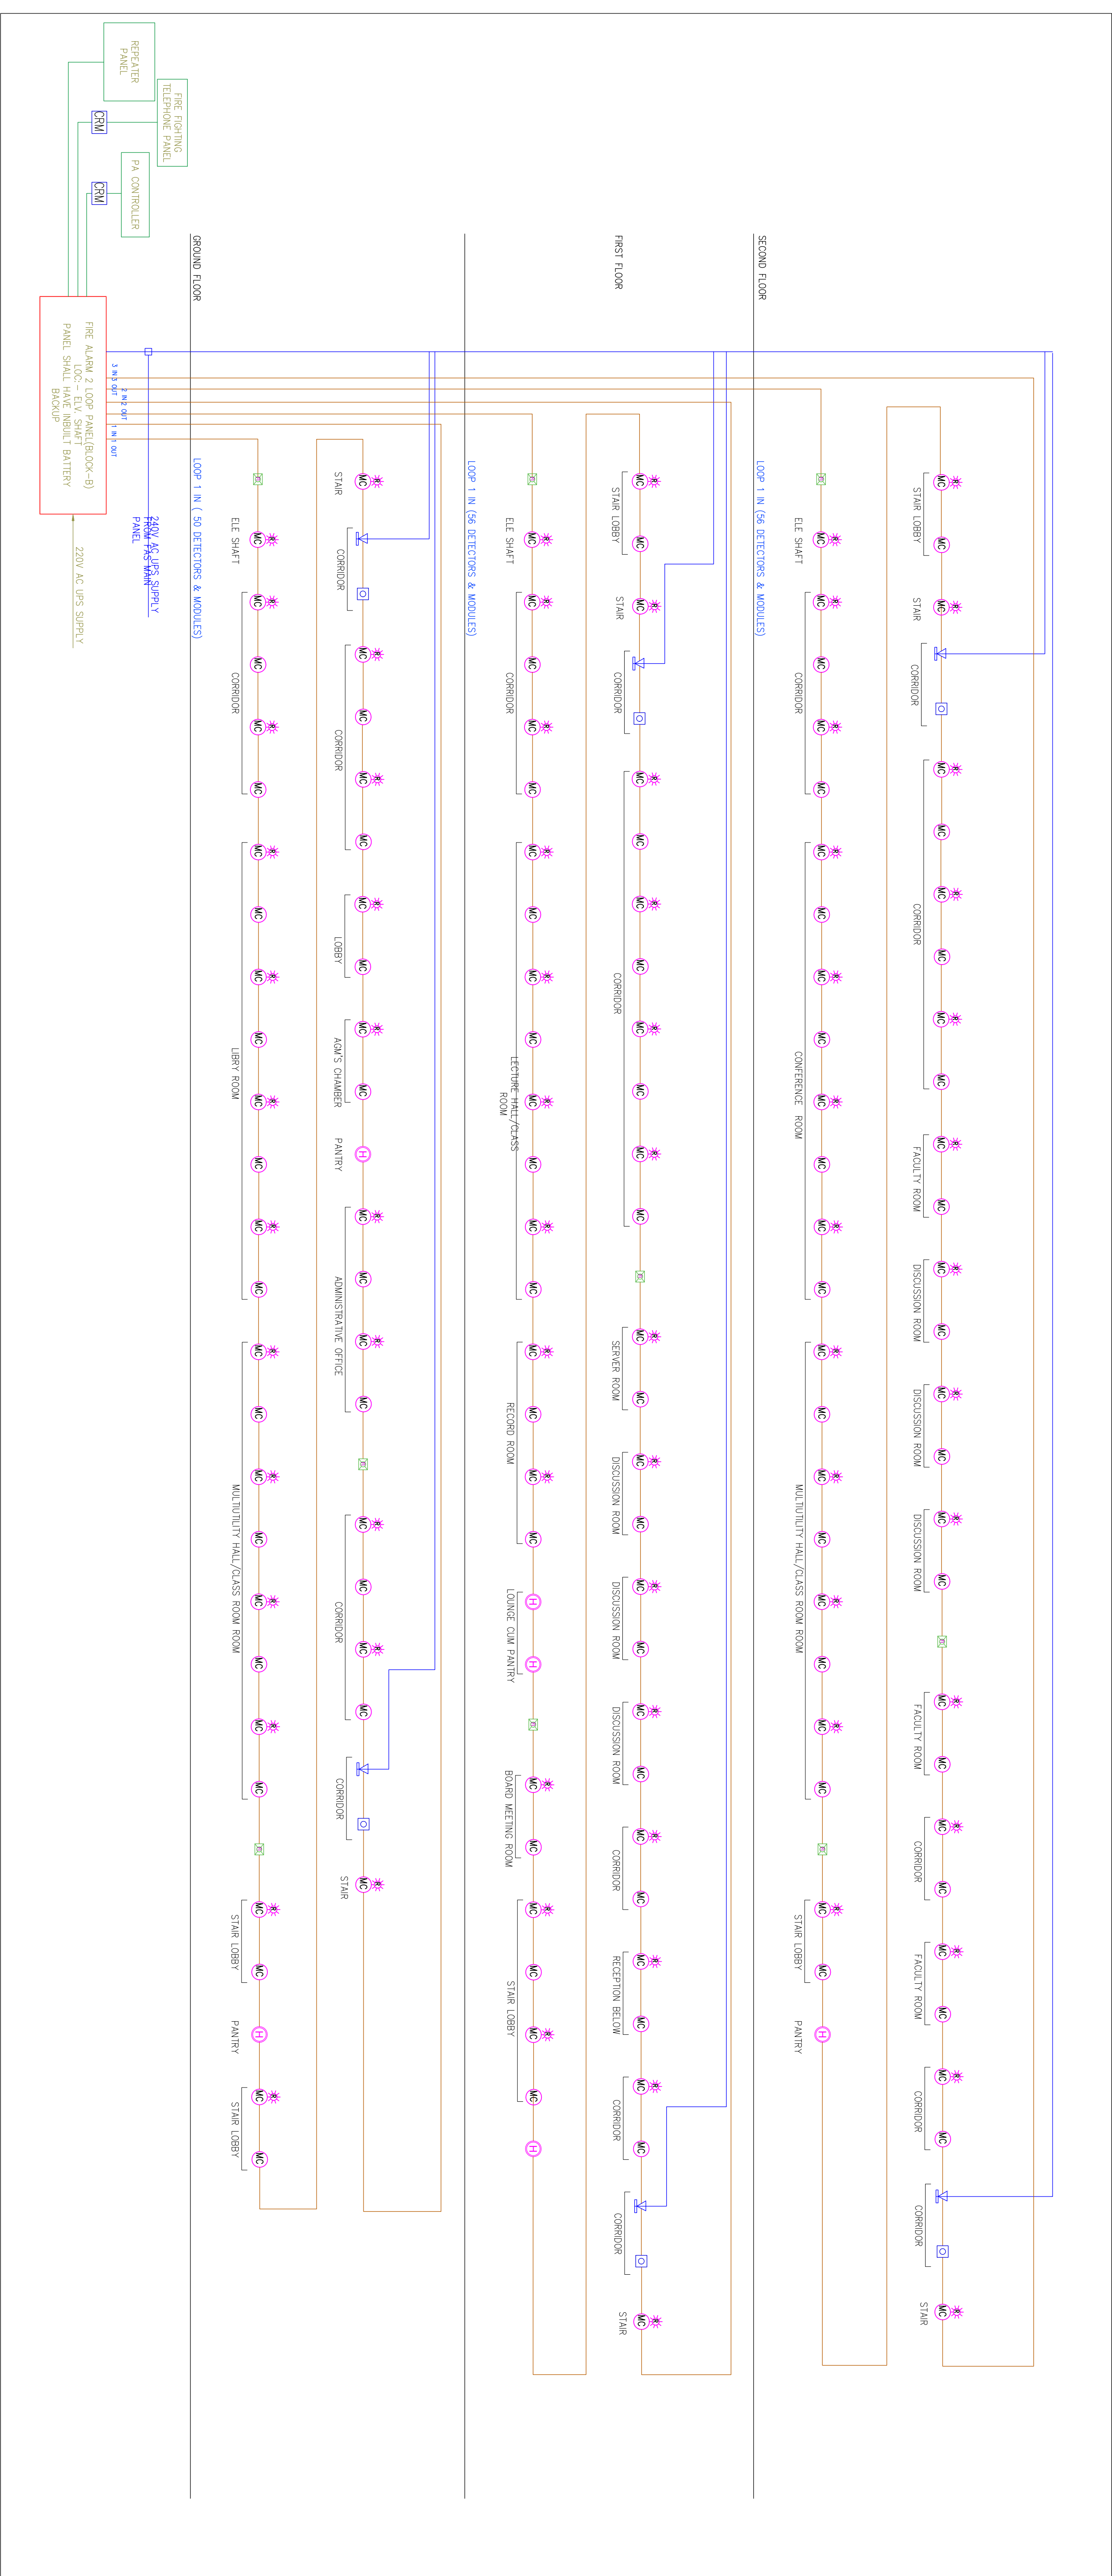


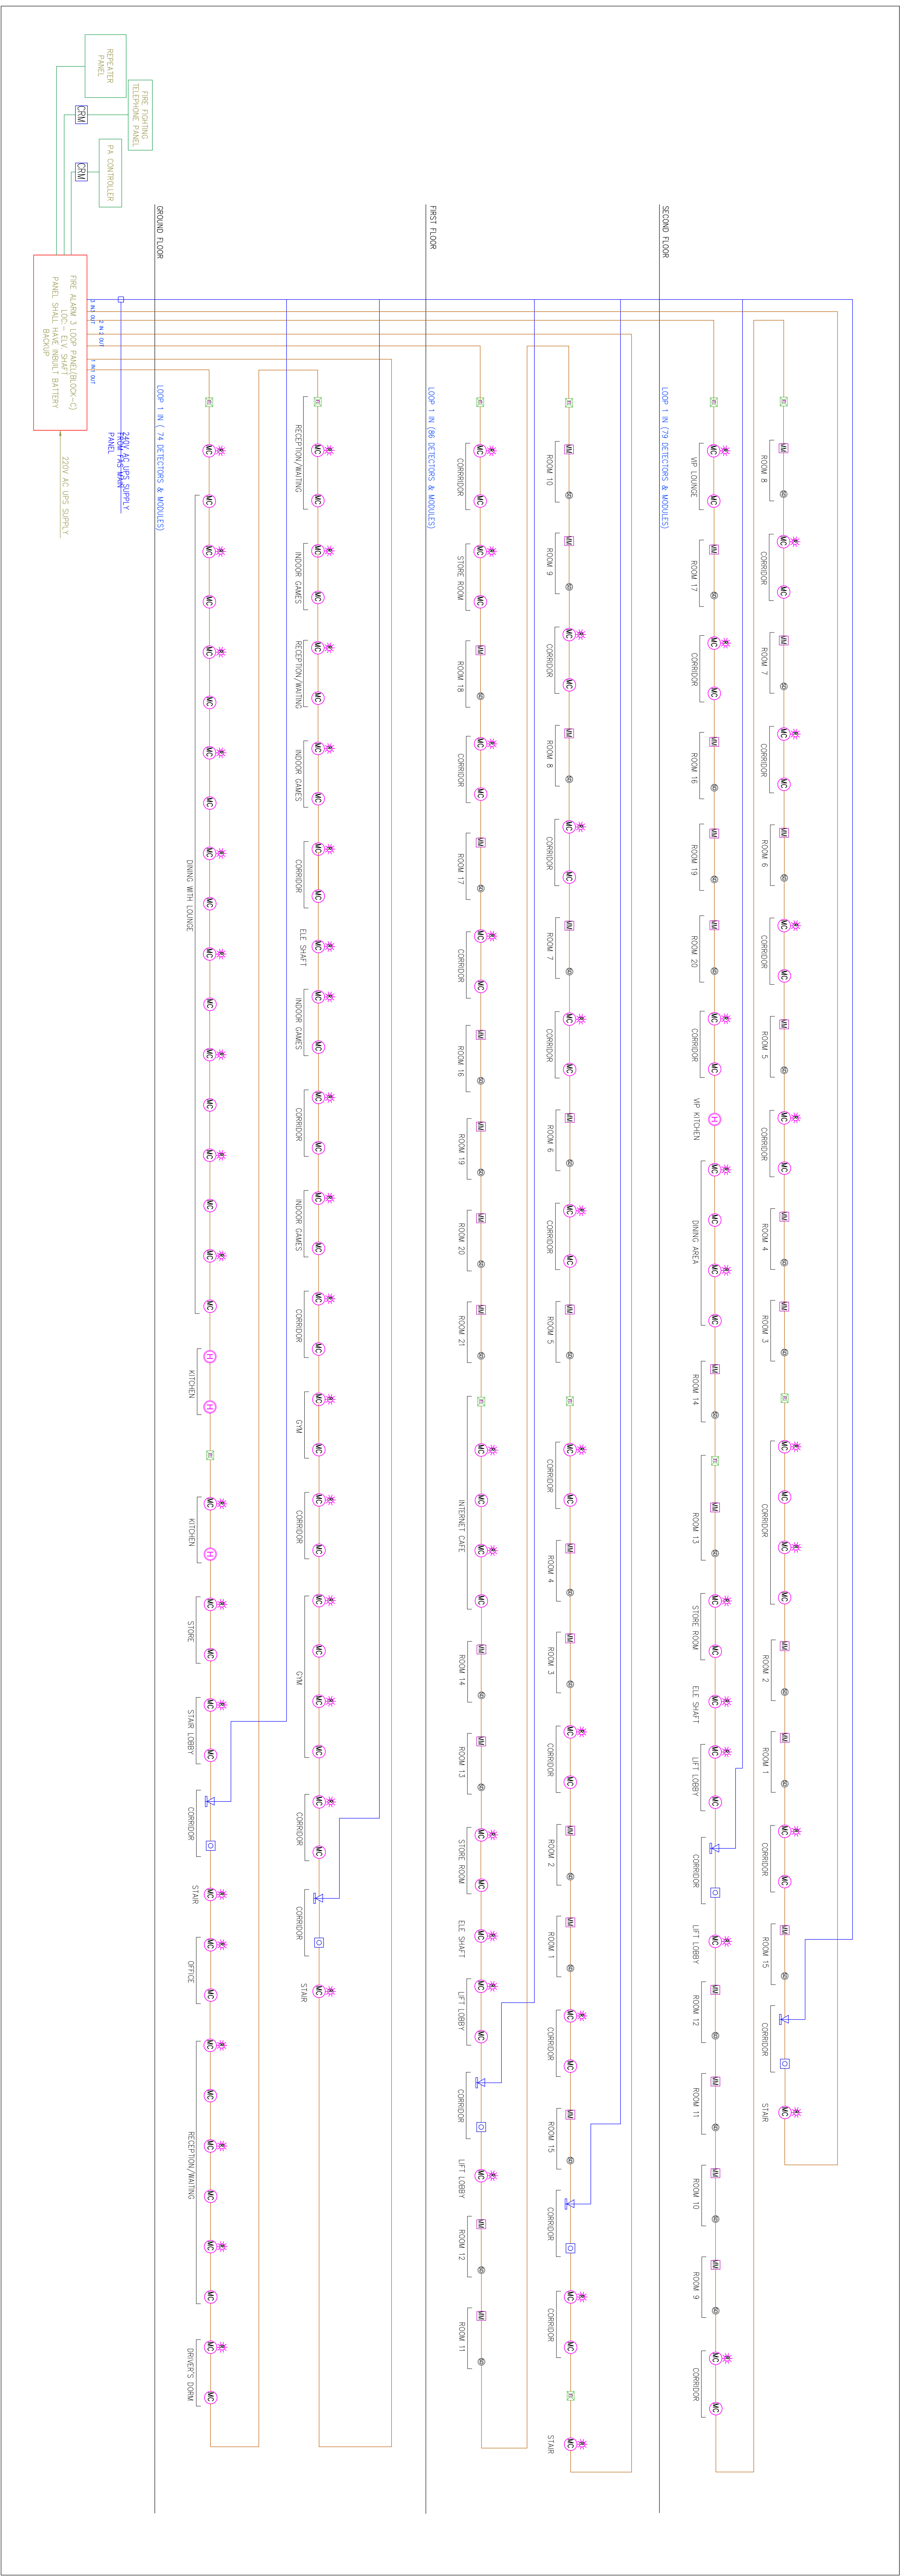

LEGEND:—

01.		MC DETECTOR ABOVE FALSE CEILING
02.		MC DETECTOR BELOW FALSE CEILING
03.		HOOTER
04.		MANUAL CALL POINT
05.		MONTING MODULE FOR FLOW SWITCH
06.		FAULT ISOLATOR

04									
03									
02									
01									
REV. NO.		DESCRIPTION						DATE	
REVISIONS									
DATE	07.09.2026	DRAWING TITLE:							
DRAWN	AP	ELEVATION LINE DIAGRAM OF FIRE ALARM SYSTEM(BLOCK-B,C)							
CHECKED	SD								
APPRO.	JD	Drawing No.							
JOB NO	468	SAN /468ELEV-10							
SCALE	1/75	REV.	SHEET NO.	SHEET SIZE					
STATUS	DESIGN	R/O	1/1	A0					