



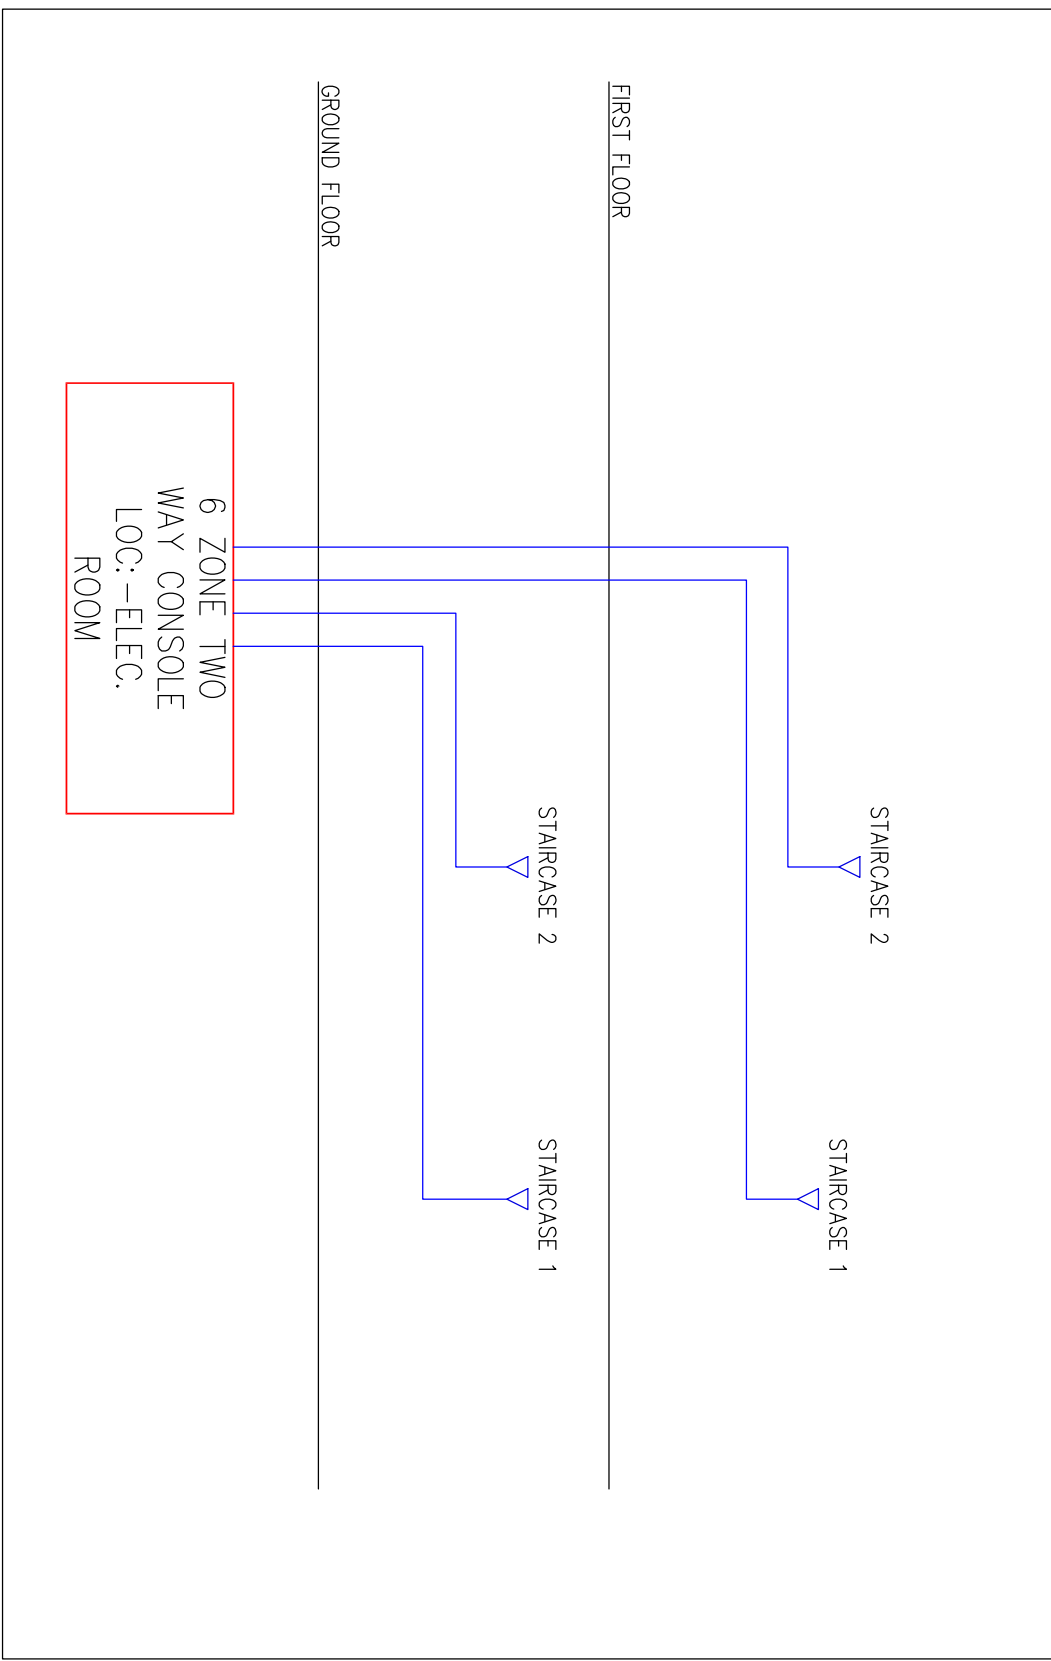

TALK BACK SYSTEM SINGLE LINE DIAGRAM (BLOCK-A)

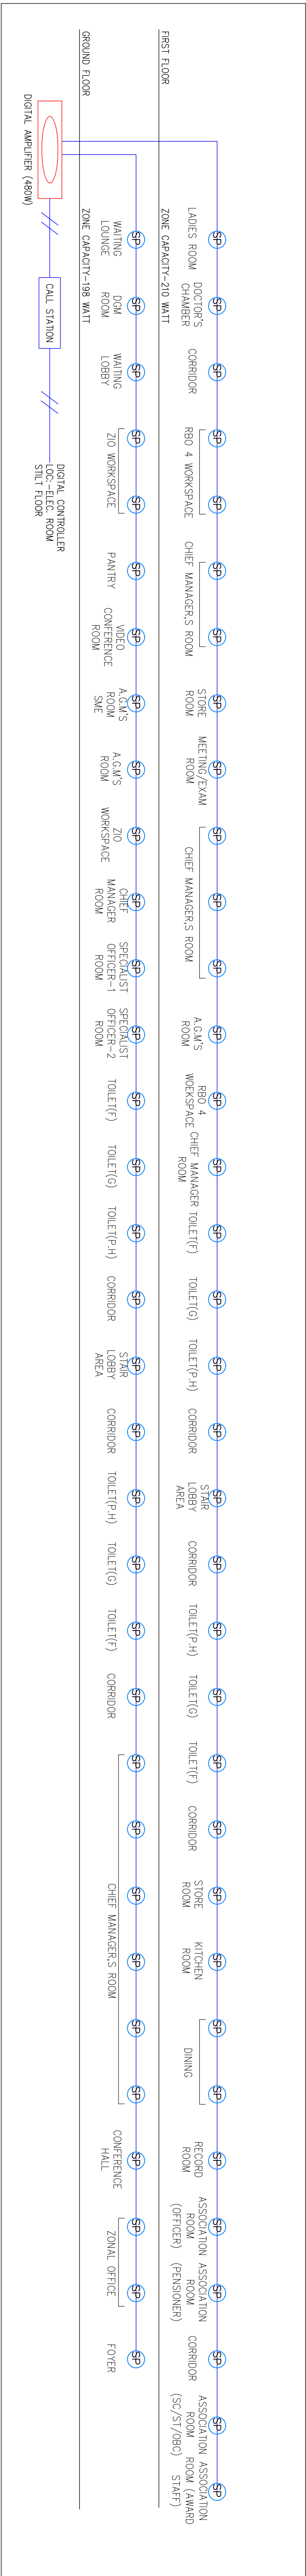

PUBLIC ADDRESS SYSTEM SINGLE LINE DIAGRAM (BLOCK-A)

ARCHITECT: MISHRA & MISHRA CONSULTANCY SERVICES PVT. LTD. FD-396, SECTOR - III, SALT LAKE CITY, KOLKATA-700106 PH: 4004 5307, email : umes_mmscs_2006@yahoo.co.in Website : www.mmscsdesign.co			PROJECT : PROPOSED TWO STORED AO & RBO AND THREE STORED SBILD BANKS BUILDING OF STATE BANK OF INDIA AT MAHATMA GANDHI AVENUE, KHATTIAN NO-441, L.R.PLOT NO-18(P) C.S.PLOT NO-272(P), 340(P), 341(P), 342(P), 343, 344, 345(P), 346, 347, 348, 349, 350(P), 352, 353(P), 354(P), 355(P), 356(P), 357(P), 501(P), OF MOUZA FARIDPUR, P.S.-DURGAPUR, JI NO-74, DIST-PASCHIM BARDHAMAN, WEST BENGAL, PIN-713216.		
CLIENT : STATE BANK OF INDIA 					

LEGEND: –		
01.		TALK BACK UNIT
LEGEND: –		
01.		CEILING SPEAKER

04		
03		
02		
01		
REV. NO.	DESCRIPTION	DATE
REVISIONS		
DATE	DRAWING TITLE:	
DRAWN	SP	ELEV SINGLE LINE DIAGRAM OF TALK BACK & PUBLIC ADDRESS SYSTEM (BLOCK-A)
CHECKED	SD	
APPRD.	JD	Drawing No.
JOB NO	488	SAN/488/ELEV-11
SCALE	NTS	REV. SHEET
STATUS	DESIGN	NO. SHEET
		1/1 A1