


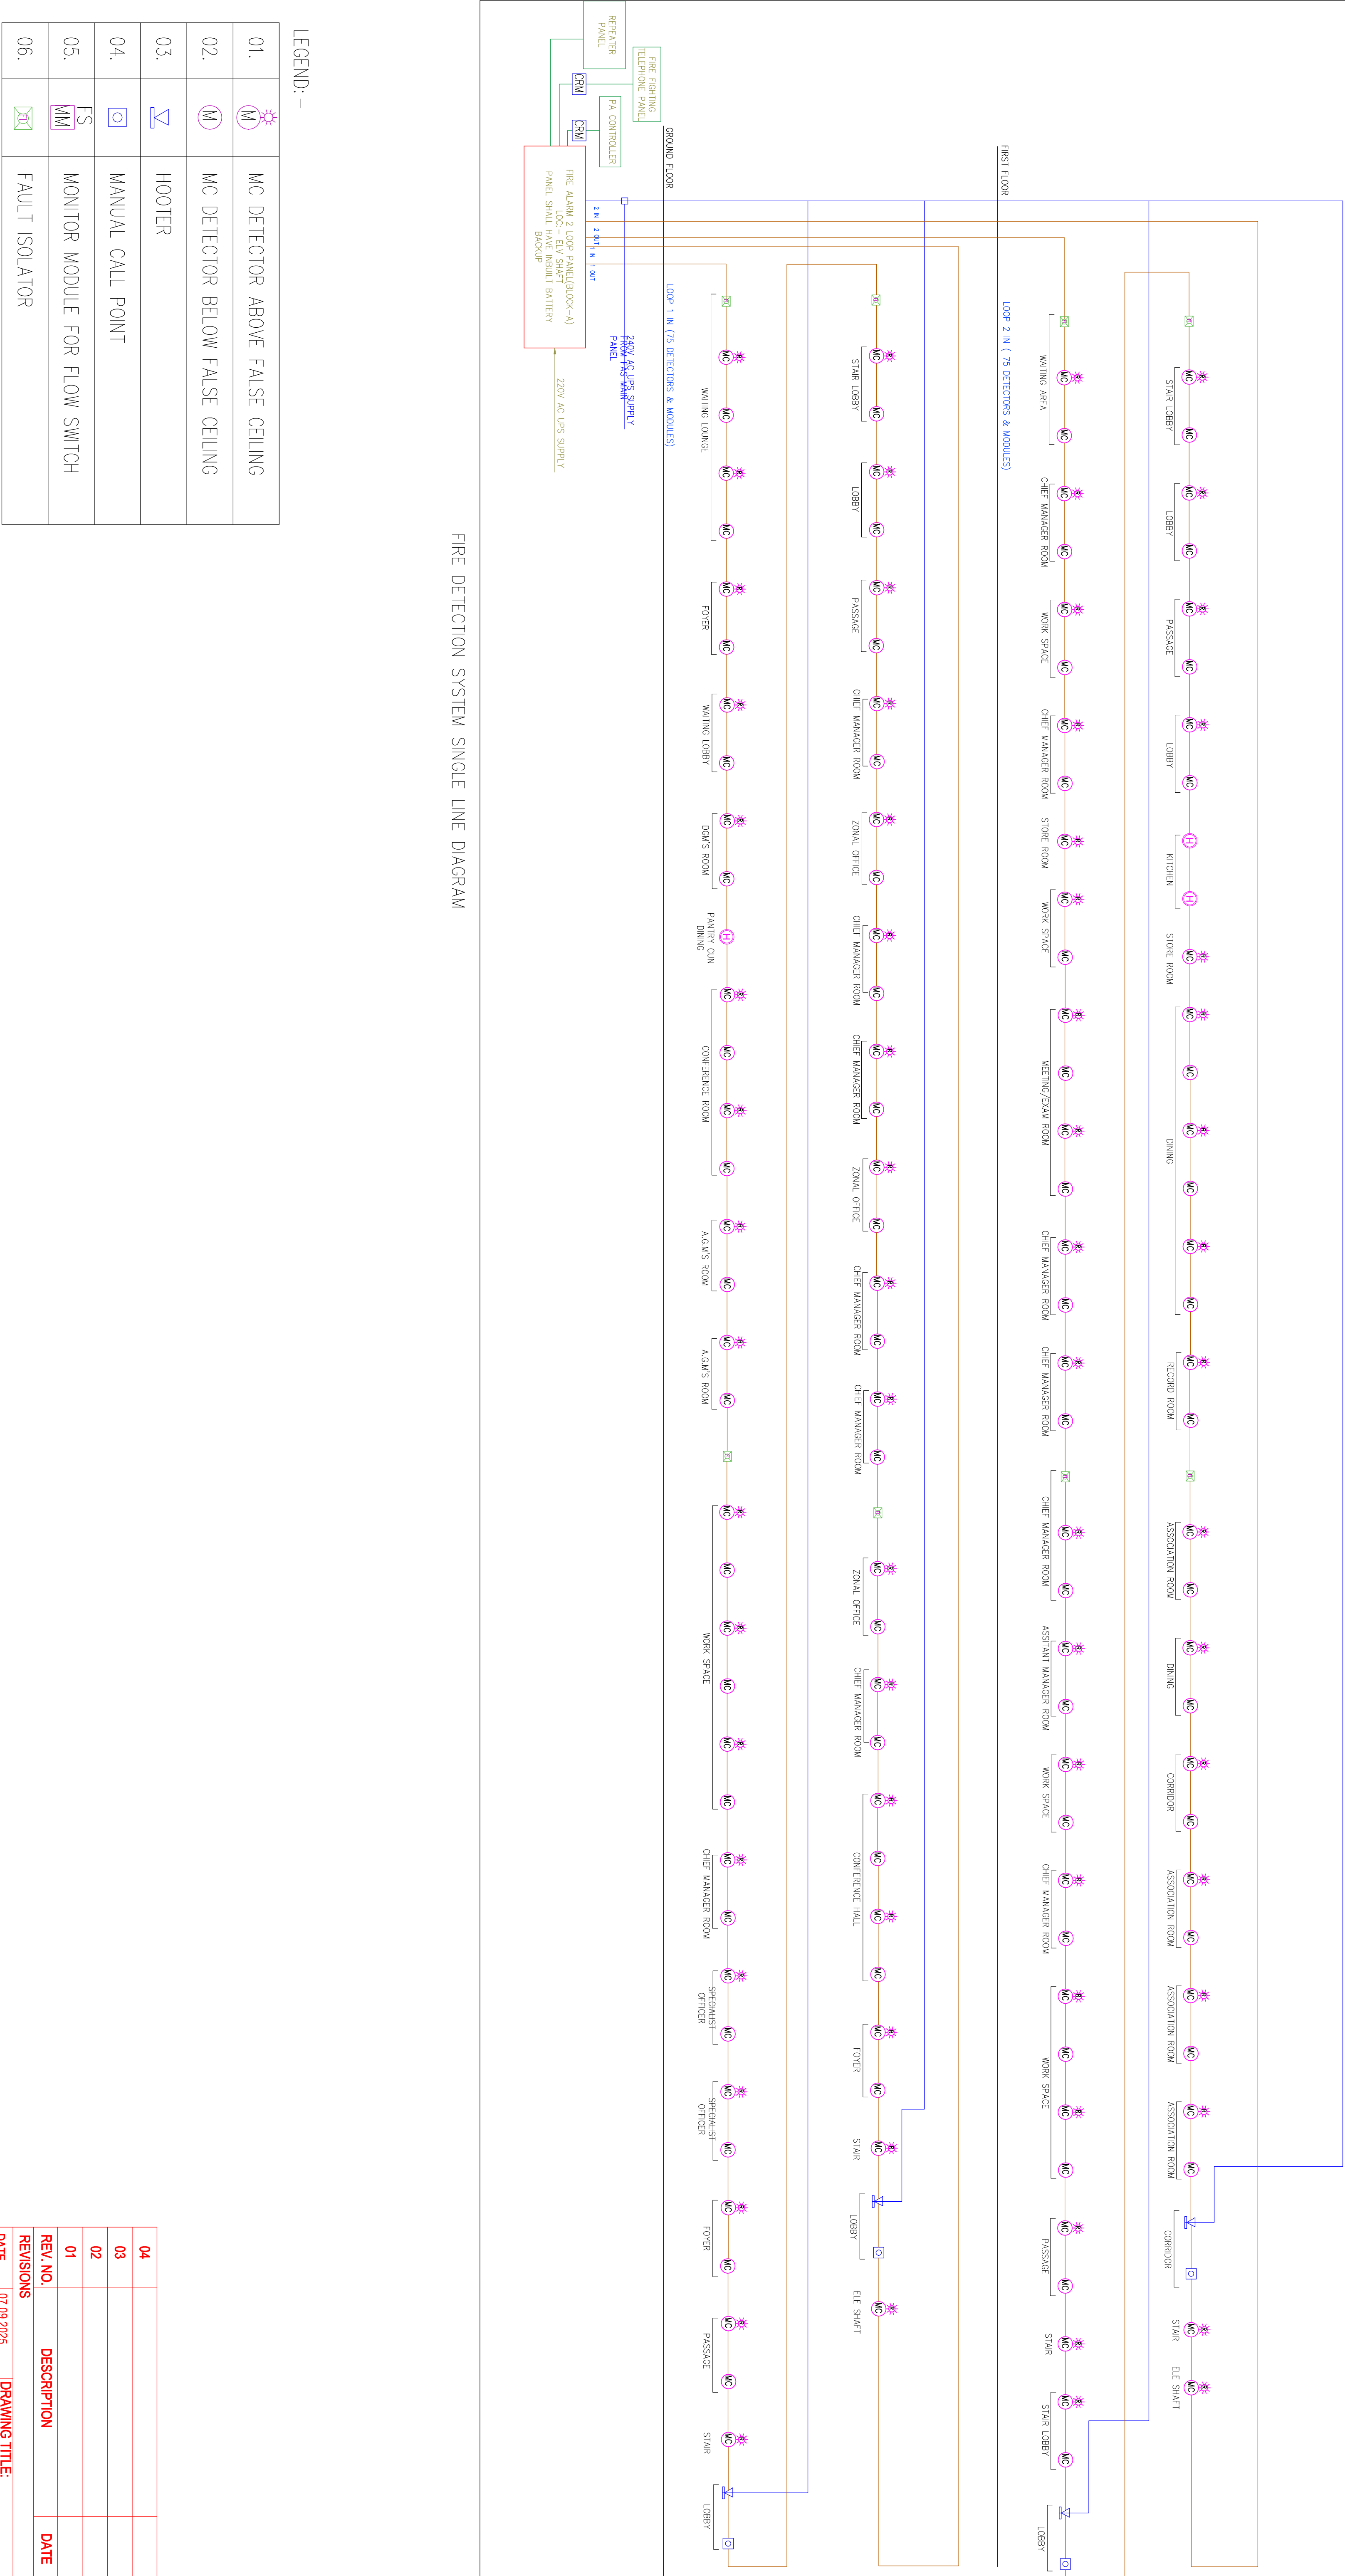

FIRE DETECTION SYSTEM SINGLE LINE DIAGRAM

ARCHITECT:

MISHRA & MISHRA CONSULTANCY SERVICES PVT. LTD.
FD-396, SECTOR - III, SALT LAKE CITY, KOLKATA-700106
PH: 4004 5307, email: umes_mmsc_2006@yahoo.co.in
Website : www.mmscdesign.co

PROJECT :

PROPOSED TWO STORED AO & RBO AND THREE STORED SBILD BANKS BUILDING OF STATE BANK OF INDIA AT MAHATMA GANDHI AVENUE, KHATTIAN NO-441, L.R PLOT NO-18(P), C.S PLOT NO-272(P), 340(P), 341(P), 342(P), 343, 344, 345(P), 346, 347, 348, 349, 350(P), 352, 353(P), 354(P), 355(P), 356(P), 357(P), 501(P), OF MOUZA FARIDPUR, P.S. DURGAPUR, JL NO-74, DIST-PASCHIM BARDHAMAN, WEST BENGAL, PIN-713216.

CLIENT :

STATE BANK OF INDIA

04		
03		
02		
01		
REV. NO.	DESCRIPTION	DATE
REVISIONS		
DATE	07.09.2025	DRAWING TITLE:
DRAWN	AP	ELEV SINGLE LINE DIAGRAM OF FIRE ALARM SYSTEM (BLOCK-A)
CHECKED	SD	
APPRD.	JD	Drawing No.
JOB NO	488	SN/488/ELEV-08
SCALE	1/75	REV. SHEET
STATUS	DESIGN	NO. SHEET
		1/1
		A1