


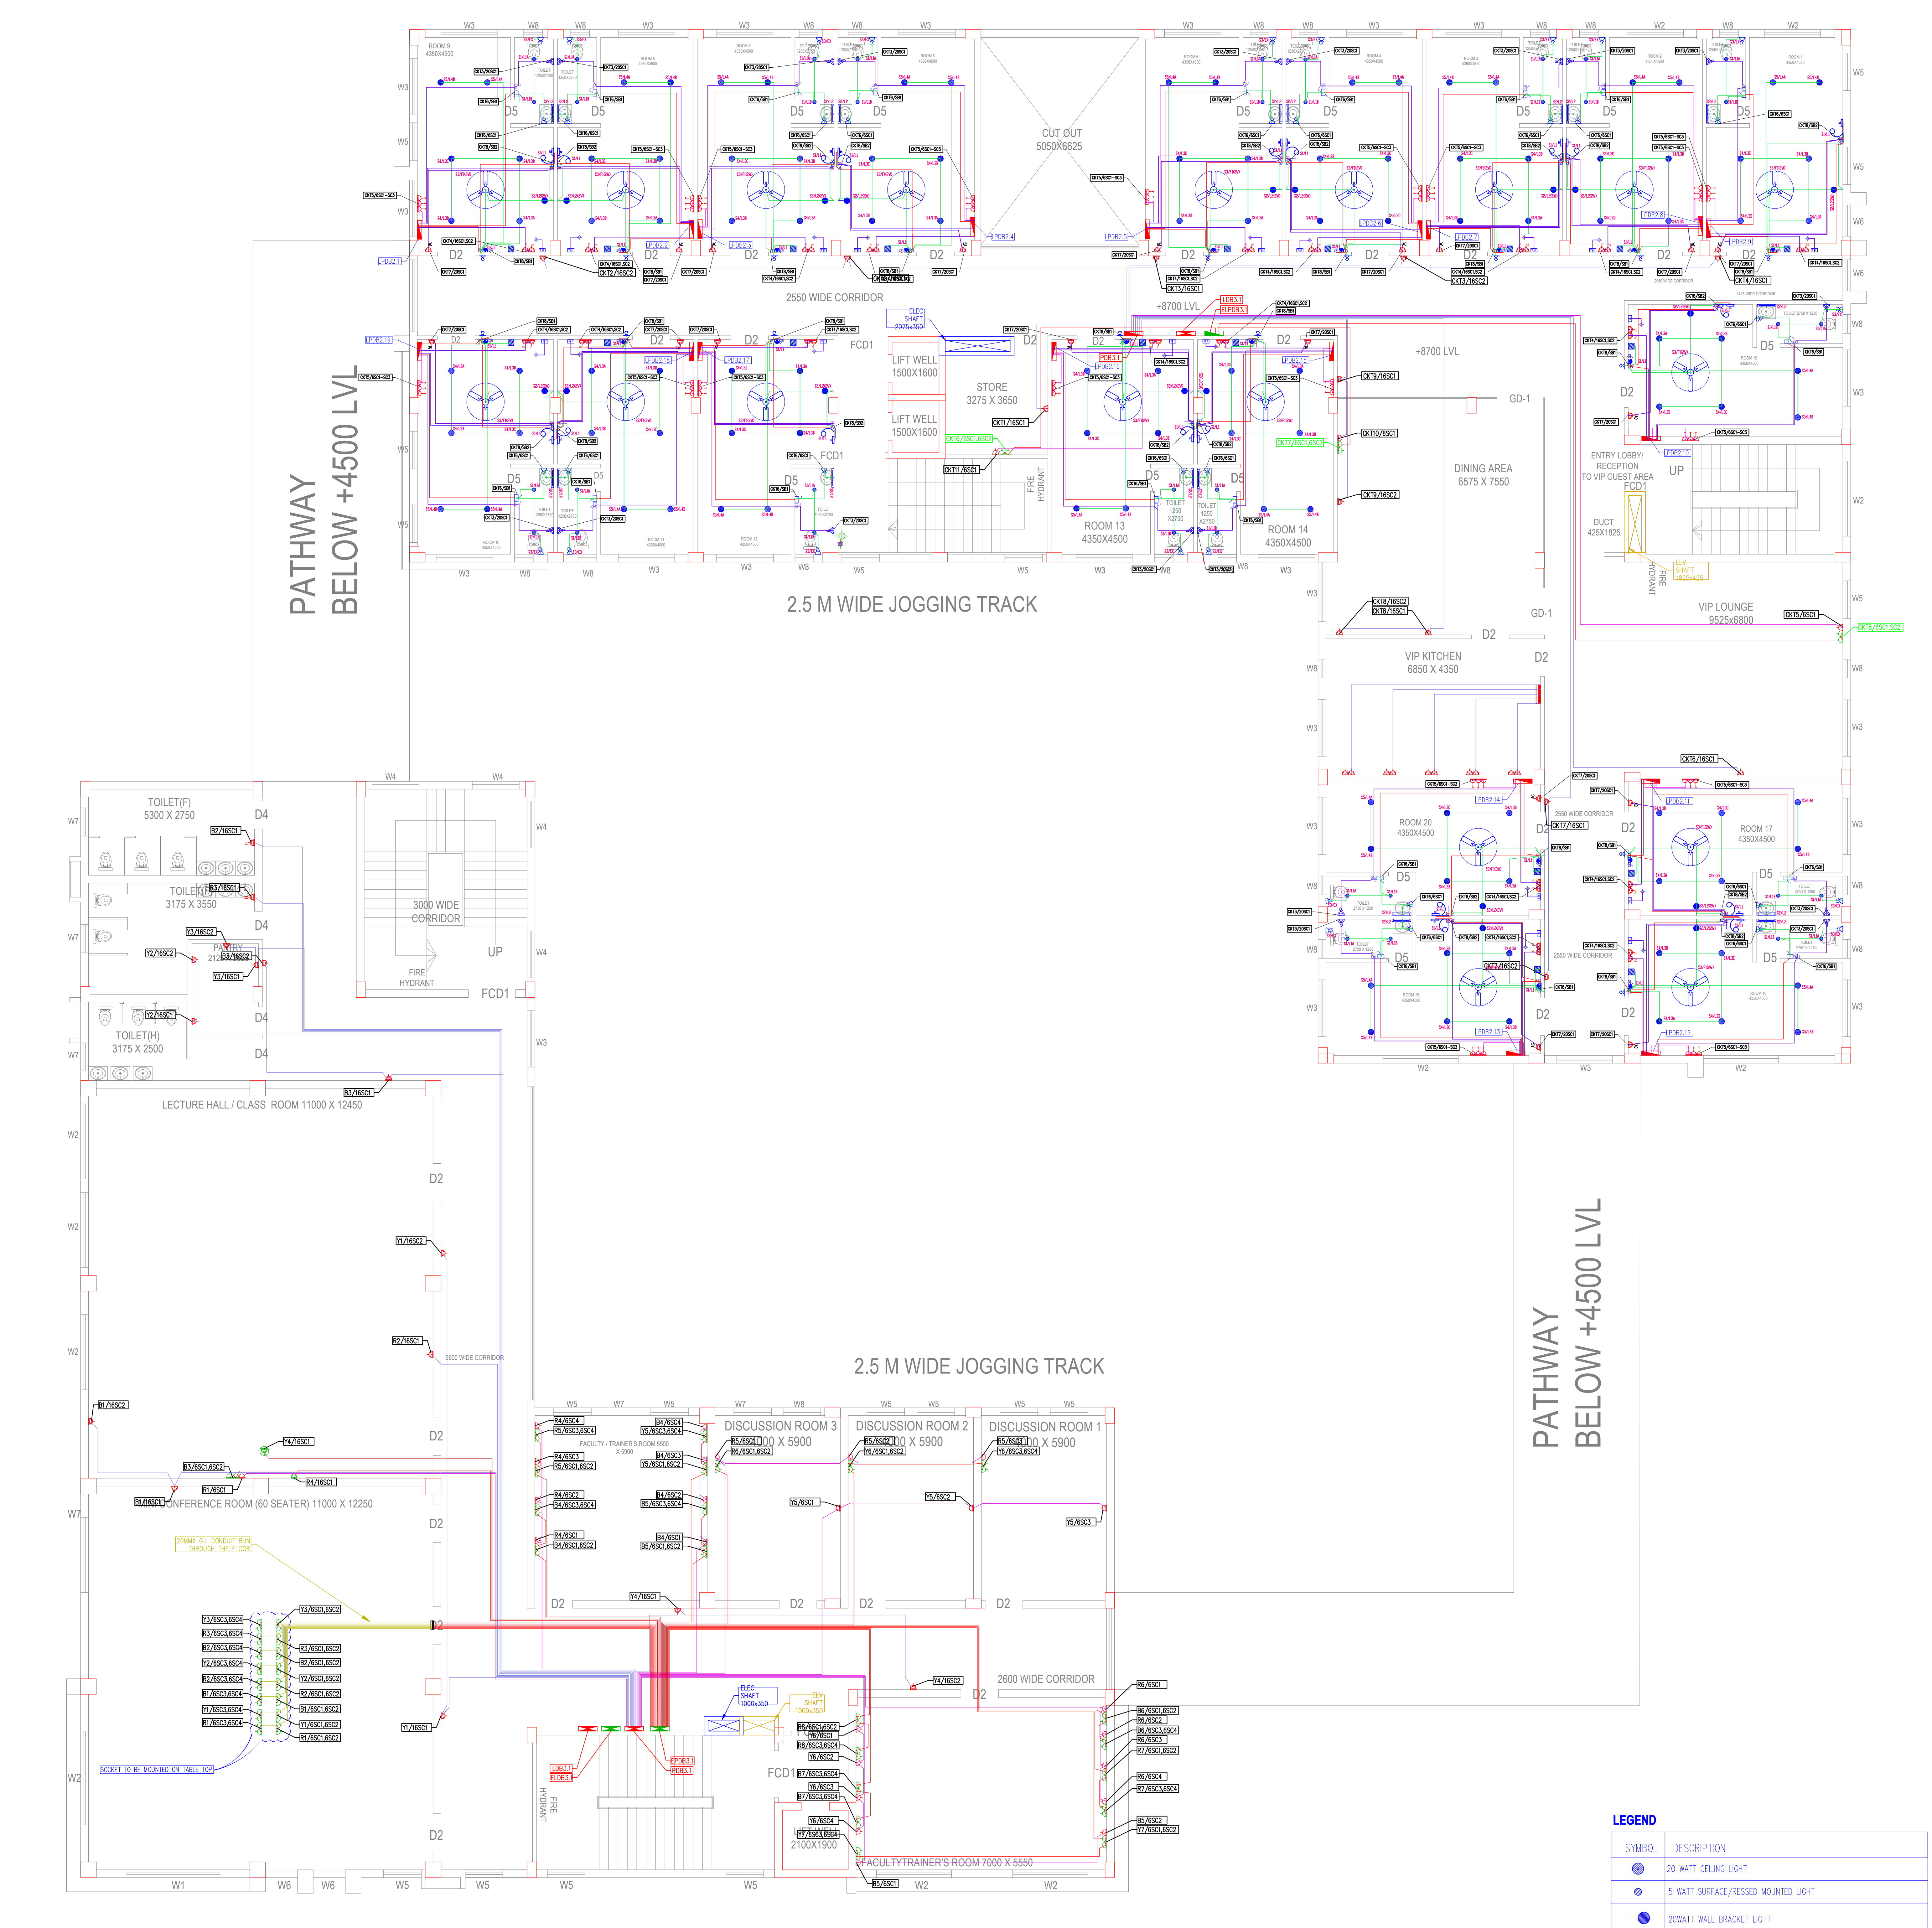


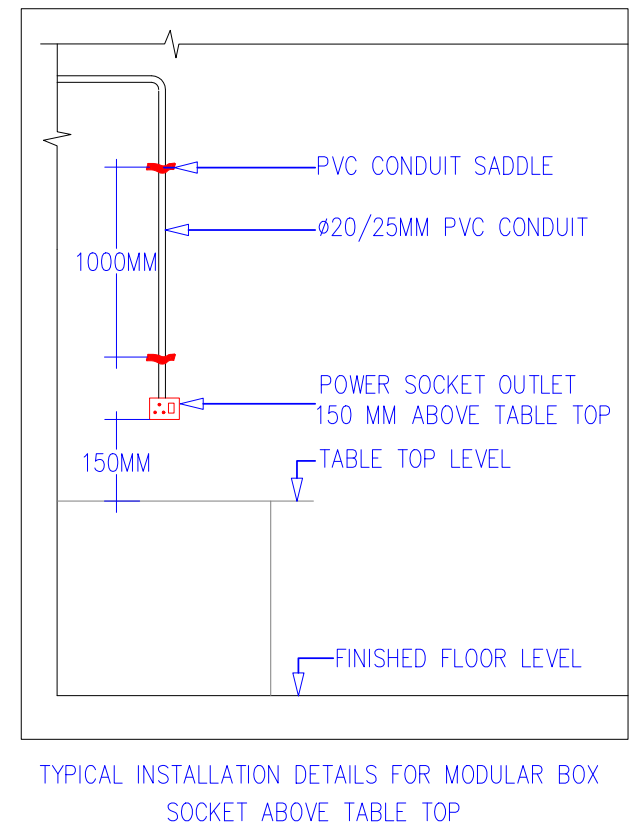

2ND. FLOOR PLAN
SBILD(ADMINISTRATIVE BLOCK)
(BLOCK-B)

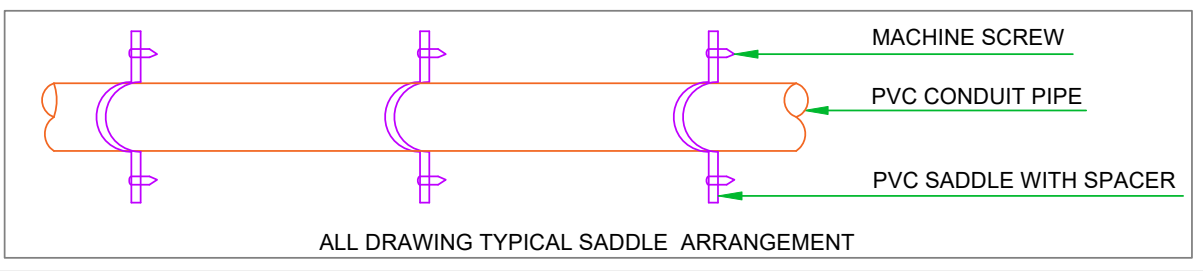


- GENERAL NOTES FOR ELECTRICAL WIRING:**
- 1.PRIMARY CIRCUITS FOR LIGHTING (DB TO SB) SHALL BE OF 2 RUNS OF 2500MM CU (PHASE & NEUTRAL) & RUN OF 2500MM FOR EARTH. EARTH WIRE SHALL BE OF GREEN COLOUR. DB TO SWITCH BOX ARE PRIMARY CIRCUITS & SWITCH BOXES TO VARIOUS POINTS ARE SECONDARY CIRCUITS.
 - 2.SWITCH BOARD TO ALL POINT (LIGHT/FAN/CALL BELL ETC) SHALL BE OF 2X2.5 SOLID MM CU WIRE.
 - 3.LIGHTING CIRCUITS FROM DB TO SWITCHBOX SHALL BE INDEPENDENT AND SHALL NOT BE ROUTED THROUGH POINTS. FOR POINT WIRING SEPARATE CONDUIT PIPE FROM SWITCHBOX TO VARIOUS POINTS TO BE TAKEN.
 - 4.EARTH CONTINUOUS WIRE SHALL BE OF 2.500MM CU FOR PRIMARY CIRCUITS AND SECONDARY WIRING. ALL POINTS SHALL HAVE ONE EARTH WIRE AND SHALL BE INDEPENDENT FOR EACH CIRCUIT.
 - 5.POWER WIRING TO 10A OUTLETS SHALL BE INDEPENDENT AND SHALL BE TAKEN THROUGH SEPARATE PIPE. THE WIRING SIZE SHALL BE 2.500MM CU + 180X 450MM CU FOR EARTH.
 - 6.ALL CONDUIT PIPES SHALL BE OF HEAVY DUTY PIPES / AS PER DOB.
 - 7.THE LIGHT FITTING SHOWN ON WALL TO BE MOUNTED AT 2400MM OR AS PER PROJECT INSTRUCTION.
 - 8.FOR CONDUIT AND WIRE SIZE FOR LDB & PDB'S REFER RESPECTIVE SCHEMATIC DIAGRAM.
 - 9.CEILING FANS SHALL HAVE INDEPENDENT CONTROL. NOT SHOWN IN THE LAYOUT FOR CLARITY.
 - 10.ROUTING OF CONDUIT PIPES, ESPECIALLY IN STAIRCASE AREAS, TOILET AREAS FLOORS, ETC.
 - 11.THE FINAL LOAD BALANCING IN RESPECTIVE DB TO BE CARRIEDOUT BEFORE NEGOTIATION.
 - 12.CONDUIT PIPES MOUNT FOR WALLS & SUB-WALLS EXCEEDS MORE THAN 10-12MM. THE CONDUIT PIPES ARE TO BE NEGOTIATED THROUGH JIB CONNECTION BOX GENERAL/CONCRETE IN WALL TO SUIT SITE CONDITION.
 - 13.DAILY CALCULATION SHEET SHALL BE SUBMITTED FOR ILLUMINATION DESIGN FINALIZATION. LIGHTING LAYOUT SHALL BE SUBJECT TO THE FINAL ILLUMINATION LEVELS AS PER DAILY.
 - 14.BOTH SIDE FERRULING AT EACH POINT / SUB-CIRCUIT SHALL BE MENTIONED.

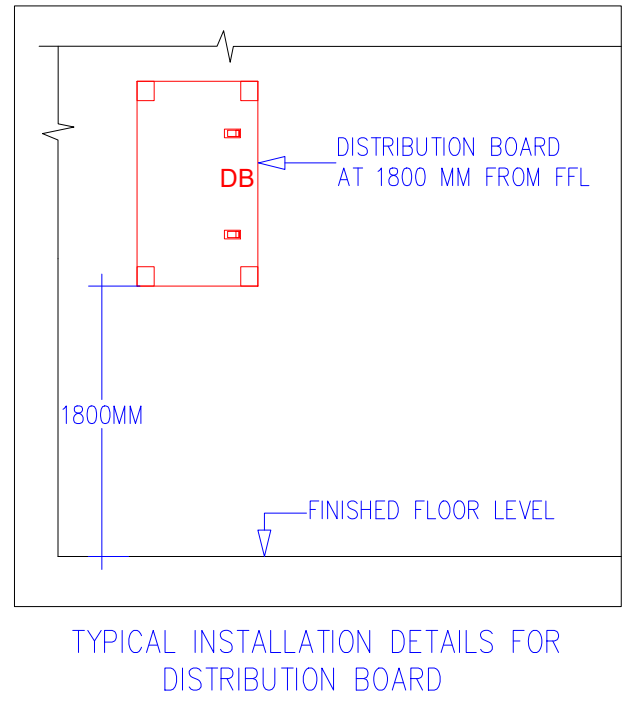

ELECTRICAL POWER FIXTURE LEGEND		
SYMBOL	RAW	UPS
6/16A SOCKET AT +450MM FROM FTL		
6/16A SOCKET CEILING MOUNTED		
6/16A SOCKET FOR HAND DRYER		
6A SOCKET FOR UTILITY AT +450MM FROM FTL		

GENERAL ELECTRICAL LEGEND	
SYMBOL DESCRIPTION	
TPN DB (NORMAL)	
TPN DB (UPS)	
SPN DB (UPS)	
MAIN VTPN DB (NORMAL)	

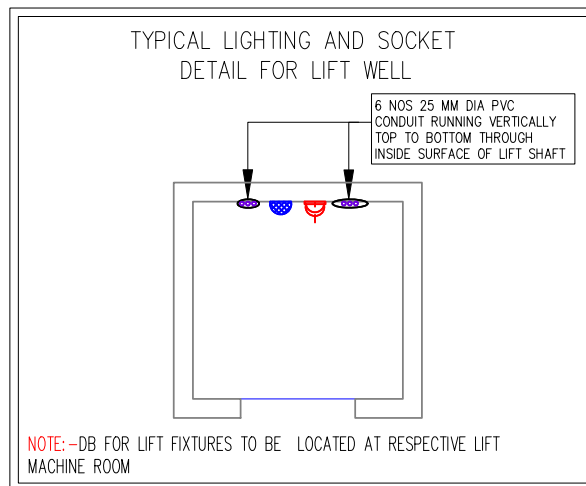

CONDUIT LEGEND	
SYMBOL DESCRIPTION	
20MM PVC CONDUIT FOR POWER (RAW)	
25MM PVC CONDUIT FOR POWER (RAW)	
20MM PVC CONDUIT FOR POWER (UPS)	
25MM PVC CONDUIT FOR POWER (UPS)	

LEGEND

SYMBOL	DESCRIPTION
	20 WATT CEILING LIGHT
	5 WATT SURFACE/PRESSED MOUNTED LIGHT
	20WATT WALL BRACKET LIGHT
	READING LIGHT(AT 1200MM HT.)
	CEILING FAN WITH 1200 MM SWEEP
	FOOT LAMP AT 150 MM HEIGHT
	10WATT MIRROR LIGHT AT +150MM FROM MIRROR
	6AMP SOCKET AT +150MM FROM TABLE TOP
	MASTER CONTROL SWITCH AT 550 MM HT.
	6/16AMP SOCKET AT +150MM FROM TABLE TOP
	6AMP SOCKET FOR EXHAUST FAN AT +150MM FROM LINTEL
	INTERNATIONAL PLUG POINT FOR SHAVING PURPOSE AT 1200 MM HEIGHT
	6AMP SOCKET FOR TV AT +150MM FROM TV CABINET
	6/16 AMP. PLUG PT. FOR MINIBAR AT 450 MM HEIGHT
	6/16 AMP. PLUG PT. FOR ELECTRIC KETTLE AT 850 MM HEIGHT
	20A AC SOCKET AT +450MM FROM LINTEL LVL
	CARD HOLDER ABOVE SWITCH BOARD
	BUIZZER AT +150MM FROM LINTEL LVL
	16 AMP. PLUG PT. FOR GEYSER (ABOVE FALSE CEILING)
	GEYSER SWITCH
	CIRCUAR BOX AT CEILING FOR THERMOSTAT WIRE CONNECTION
	A.C. THERMOSTAT AT 1200 MM HT.
	SWITCH BOARD WITHOUT SOCKET AT+1250MM FROM FFL OR AT +150MM FROM TABLE TOP
	SWITCH BOARD WITH 6A SOCKET AT+1250MM FROM FFL OR AT +150MM FROM TABLE TOP
	CALLING BELL SWITCH AT 1050MM HT.
	FLXLI. DB (ABOVE FALSE CEILING)

03		
04		
01	CHANGES AS PER CLIENT REQUIREMENT	23.09.2025
REV. NO.	DESCRIPTION	DATE
01		
02		
03		
100		

ARCHITECT: MISHRA & MISHRA CONSULTANCY SERVICES PVT. LTD.
FD-306, SECTOR - III, SALT LAKE CITY, KOLKATA-700106
PH: 4004 5307 email: umes_mishra_2006@yahoo.co.in
website: www.mimcdesign.com

PROJECT :

CLIENT :

STATE BANK OF INDIA



DATE	28.08.2025	DRAWING TITLE:
DRAWN	SBAP,SM	ELECTRICAL POWER LAYOUT FOR 2ND FLOOR (BLOCK B & C)
CHECKED	SD	
APPROD.	JD	
JOB NO	468	Drawing No. SAN/H8/EL/EPWR-04
SCALE	1/75	REV. SHEET NO. SHEET SIZE
STATUS	DESIGN	R1 1/1 A0