


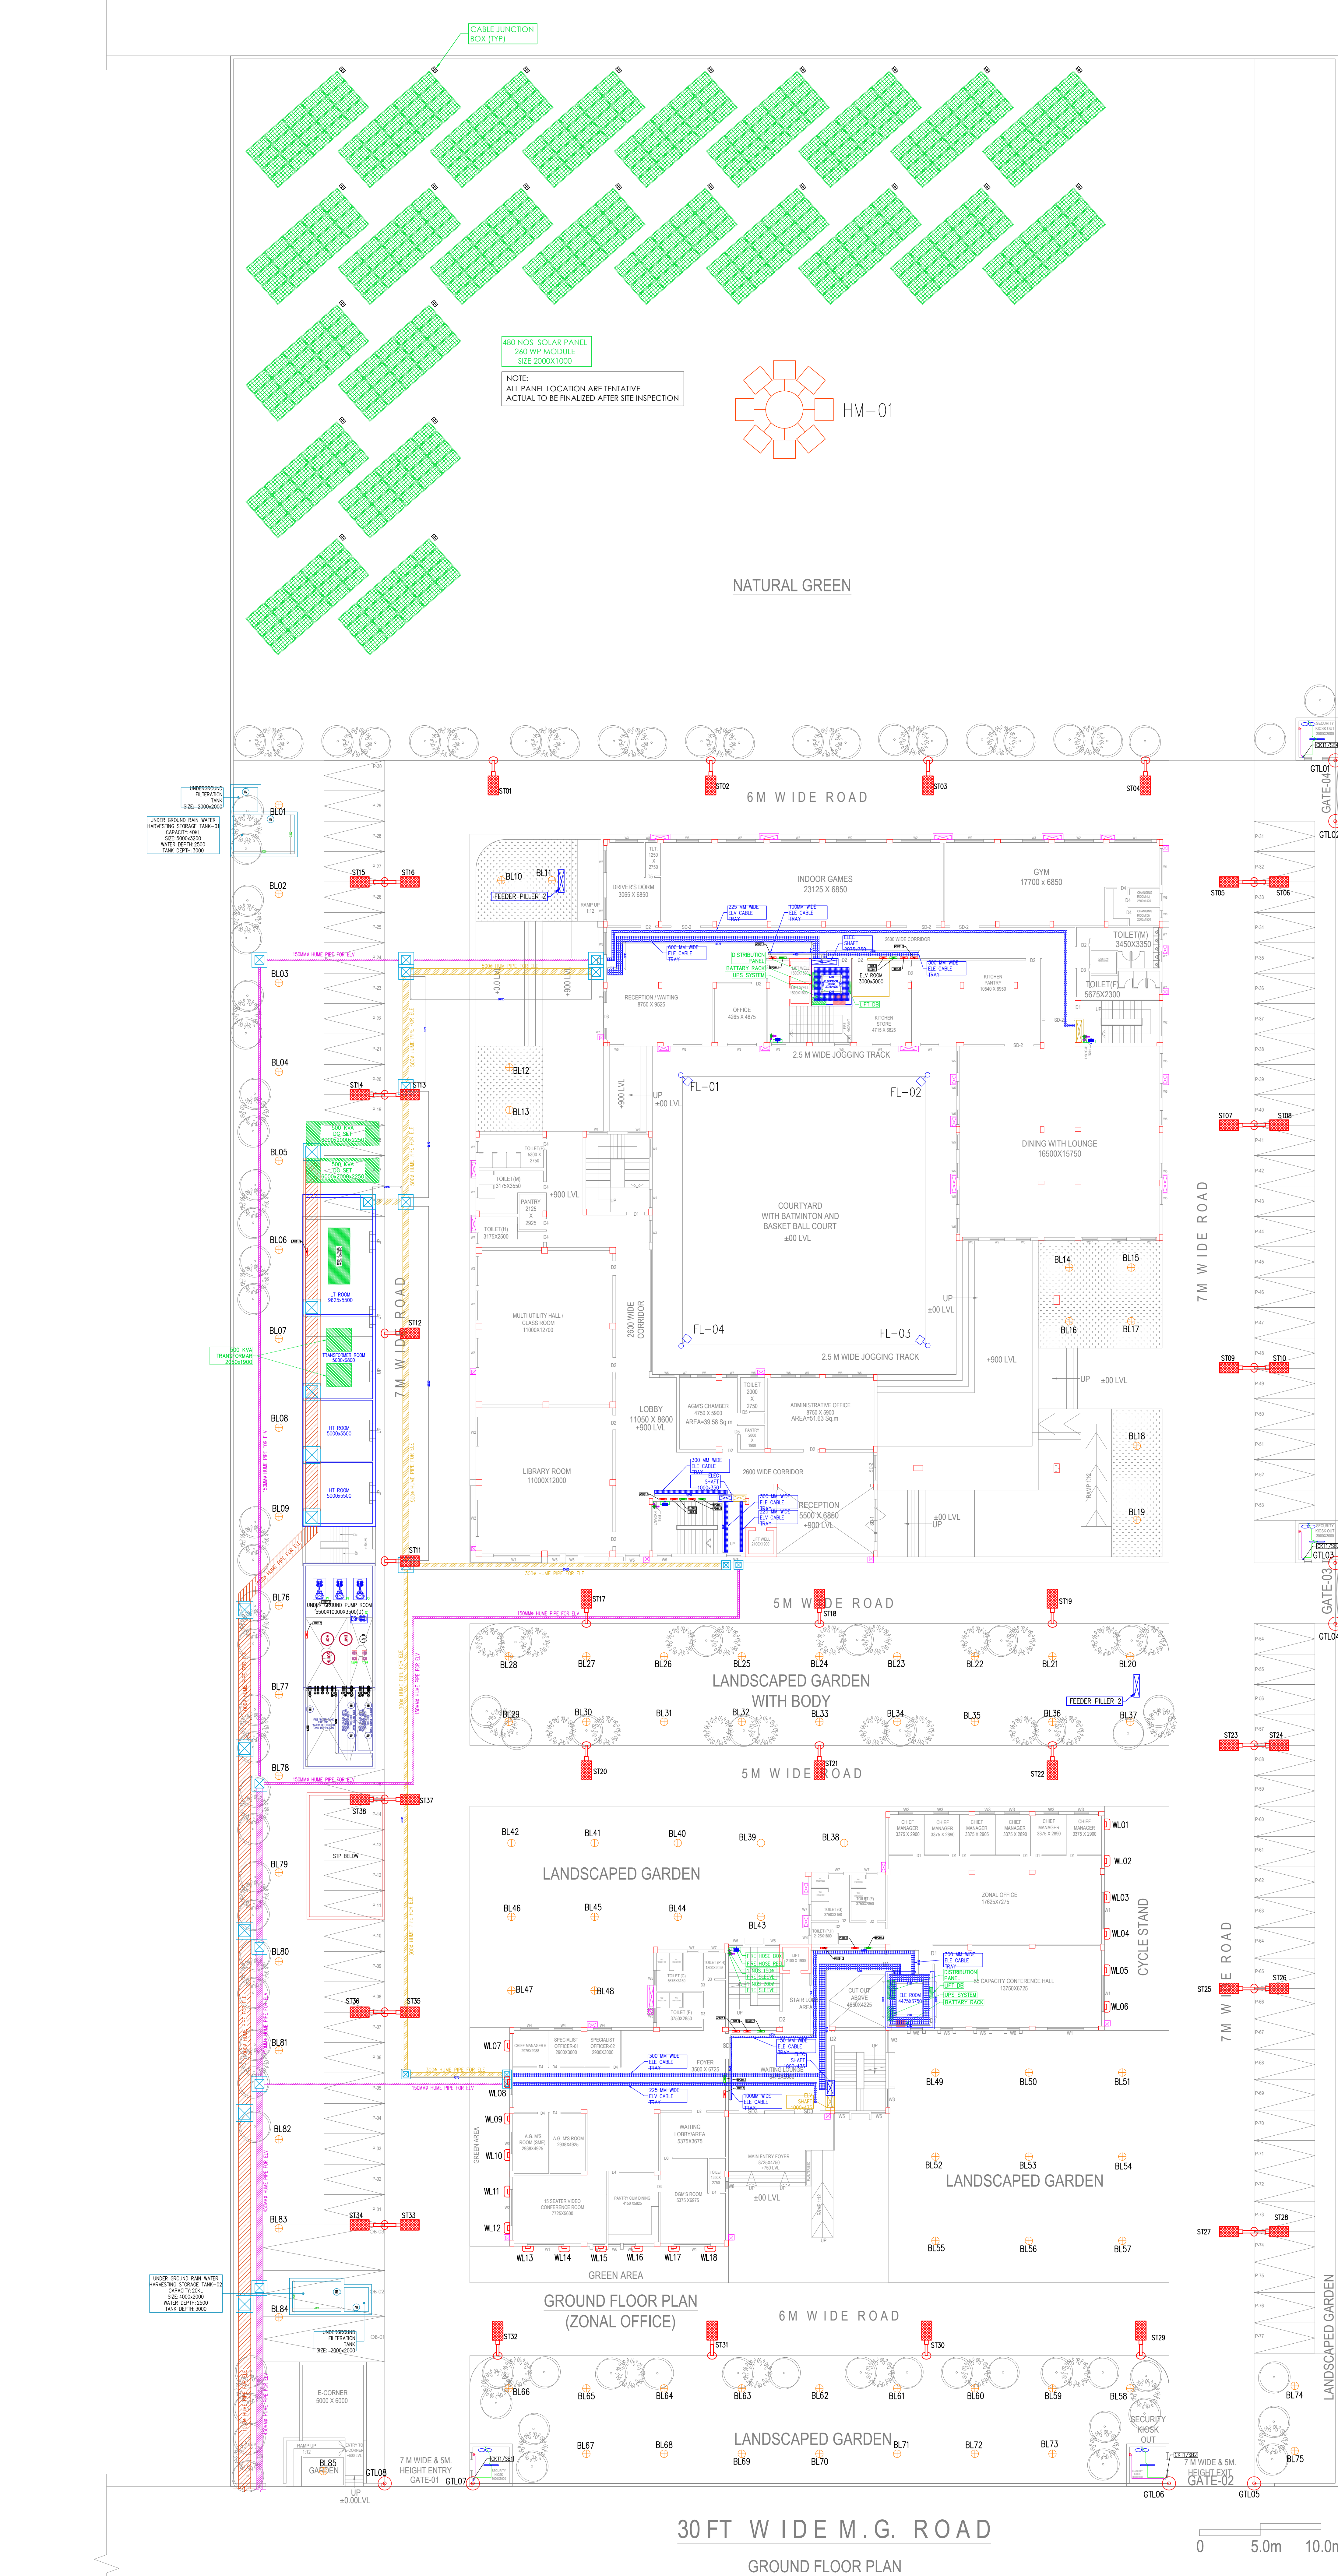



SYMBOL	DESCRIPTION
	SINGLE ARM BRACKET STREET LIGHT WITH 1 NO. 45 WATT LUMINAIRE AT 7 METER HEIGHT
	DOUBLE ARM BRACKET STREET LIGHT WITH 2 NOS 45 WATT LUMINAIRE AT 7 METER HEIGHT
	10 WATT BOLLARD
	10 WATT OUTDOOR WALL LIGHT UP DOWN TYPE
	35 WATT GATE TOP LIGHT
	400 WATT FLOOD LIGHT
	LUMINAIRE: 4200W HIGH MAST LIGHT NO. OF LUMINAIRE: 8 MAST HEIGHT: 22 METER

GENERAL ELECTRICAL LEGEND	
SYMBOL	DESCRIPTION
	TPN DB (NORMAL)
	TPN DB (UPS)
	SPN DB (UPS)
	MAIN VTPN DB (NORMAL)

SHAFT LEGEND: -		
SL	TYPE	DESCRIPTION
1.		ELECTRICAL SHAFT
2.		ELV SHAFT
3.		PHE SHAFT

SYMBOL	DESCRIPTION
	TYPICAL CABLE CHAMBER
	CABLE TRENCH PIT
	HT TRENCH
	ELE HUME PIPE
	ELV HUME PIPE

GENERAL ELECTRICAL LEGEND	
SYMBOL	DESCRIPTION
	ELECTRICAL CABLE TRAY

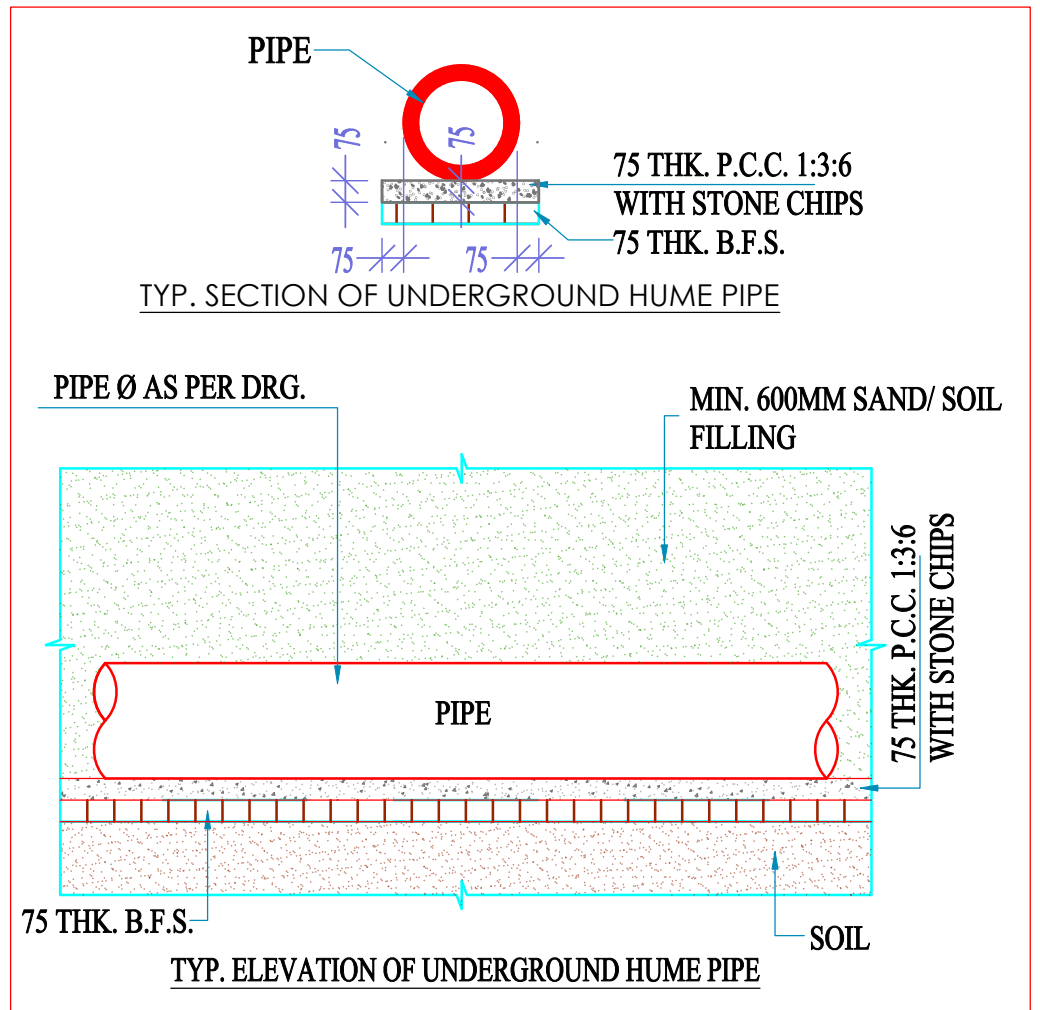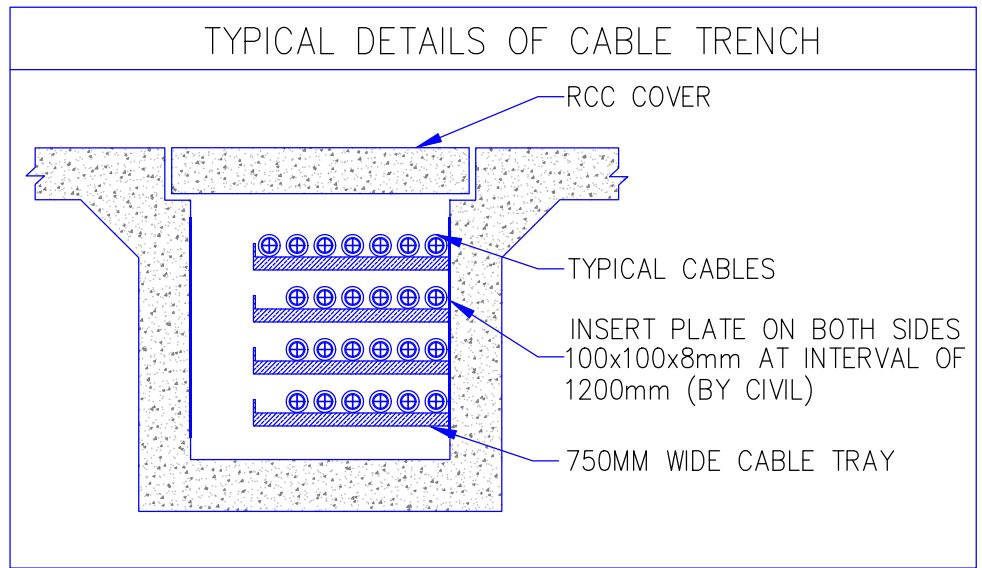

REV. NO.	DESCRIPTION	DATE
04		
03		
02		
01		

REVISIONS		
DATE	BY	DESCRIPTION
31.08.2025	RD/SR	DRAWING TITLE: ELECTRICAL SCHEMATIC LAYOUT FOR GROUND FLOOR WITH EXTERNAL PLAN
CHECKED	SD	
APPROD.	JD	Drawing No. SAN/68/ELE-SCH-01
JOB NO	468	REV. NO.
SCALE	1:150	SHEET NO.
STATUS	DESIGN	SHEET SIZE

ARCHITECT:
MISHRA & MISHRA CONSULTANCY
SERVICES PVT. LTD.
FD-396, SECTOR - III, SALT LAKE CITY, KOLKATA-700106
PH: 4004 5307, email : umes_mmcs_2006@yahoo.co.in
website : www.mmcsdesign.co

PROJECT :
PROPOSED TWO STORED AO & RBO AND THREE STORED SBILD BANK'S BUILDING OF
STATE BANK OF INDIA AT MAHATMA GANDHI AVENUE, KHATIAN NO-41, L.R PLOT
NO-18(P), C.S PLOT NO-272(P), 340(P), 341(P), 342(P), 343, 344, 345(P), 346, 347, 348, 349,
350(P), 352, 353(P), 354(P), 355(P), 356(P), 357(P), 501(P), OF MOUZA -FARIDPUR, P.S
-DURGAPUR, J.L NO-74, DIST-PASCHIM BARDHAMAN, WEST BENGAL, PIN-713216.

CLIENT : STATE BANK OF INDIA

