

ARCHITECT:

MISHRA & MISHRA CONSULTANCY

SERVICES PVT. LTD.

FD-396, SECTOR - III, SALT LAKE CITY, KOLKATA-700106

PH- 4004 5307, email : umes_mms_2006@jahno.co.in

Website : www.mmscdesign.co

PROJECT :

PROPOSED TWO STORED AO & RBO AND THREE STORED SBILD BANK'S BUILDING OF STATE BANK OF INDIA AT MAHATMA GANDHI AVENUE, KHATIAN NO-441, L,R PLOT NO-18(P), C S PLOT NO:-272(P), 340(P), 341(P), 342(P), 343, 344, 345(P), 346, 347, 348, 349, 350(P), 352, 353(P), 354(P), 355(P), 356(P), 357(P), 501(P), OF MOUZA -FARIDPUR, P.S -DURGAPUR, J.L.NO-74, DIST-PASCHIM BARDHAMAN, WEST BENGAL, PIN-713216.

CLIENT :

STATE BANK OF INDIA

SHAFT LEGEND:-

SL	TYPE	DESCRIPTION
1.		ELECTRICAL SHAFT
2.		ELV SHAFT
3.		PHE SHAFT

GENERAL ELECTRICAL LEGEND

SYMBOL	DESCRIPTION
	IPN DB (NORMAL)
	IPN DB (UPS)
	SPN DB (UPS)
	MAIN VTN DB (NORMAL)

REVISIONS

REV. NO.	DESCRIPTION	DATE
01		
02		
03		
04		

DRAWING TITLE:

ELECTRICAL SCHEMATIC LAYOUT FOR FIRST FLOOR (BLOCK-A)

DATE

31.08.2025

DRAWN

RD/SR

CHECKED

SD

APPRD.

JD

JOB NO

488

SCALE

1:75

STATUS

DESIGN

Drawing No.

SAN/488ELE-SCH-05

SHEET NO.


REV.

SHEET SIZE

RO

1/1

AT

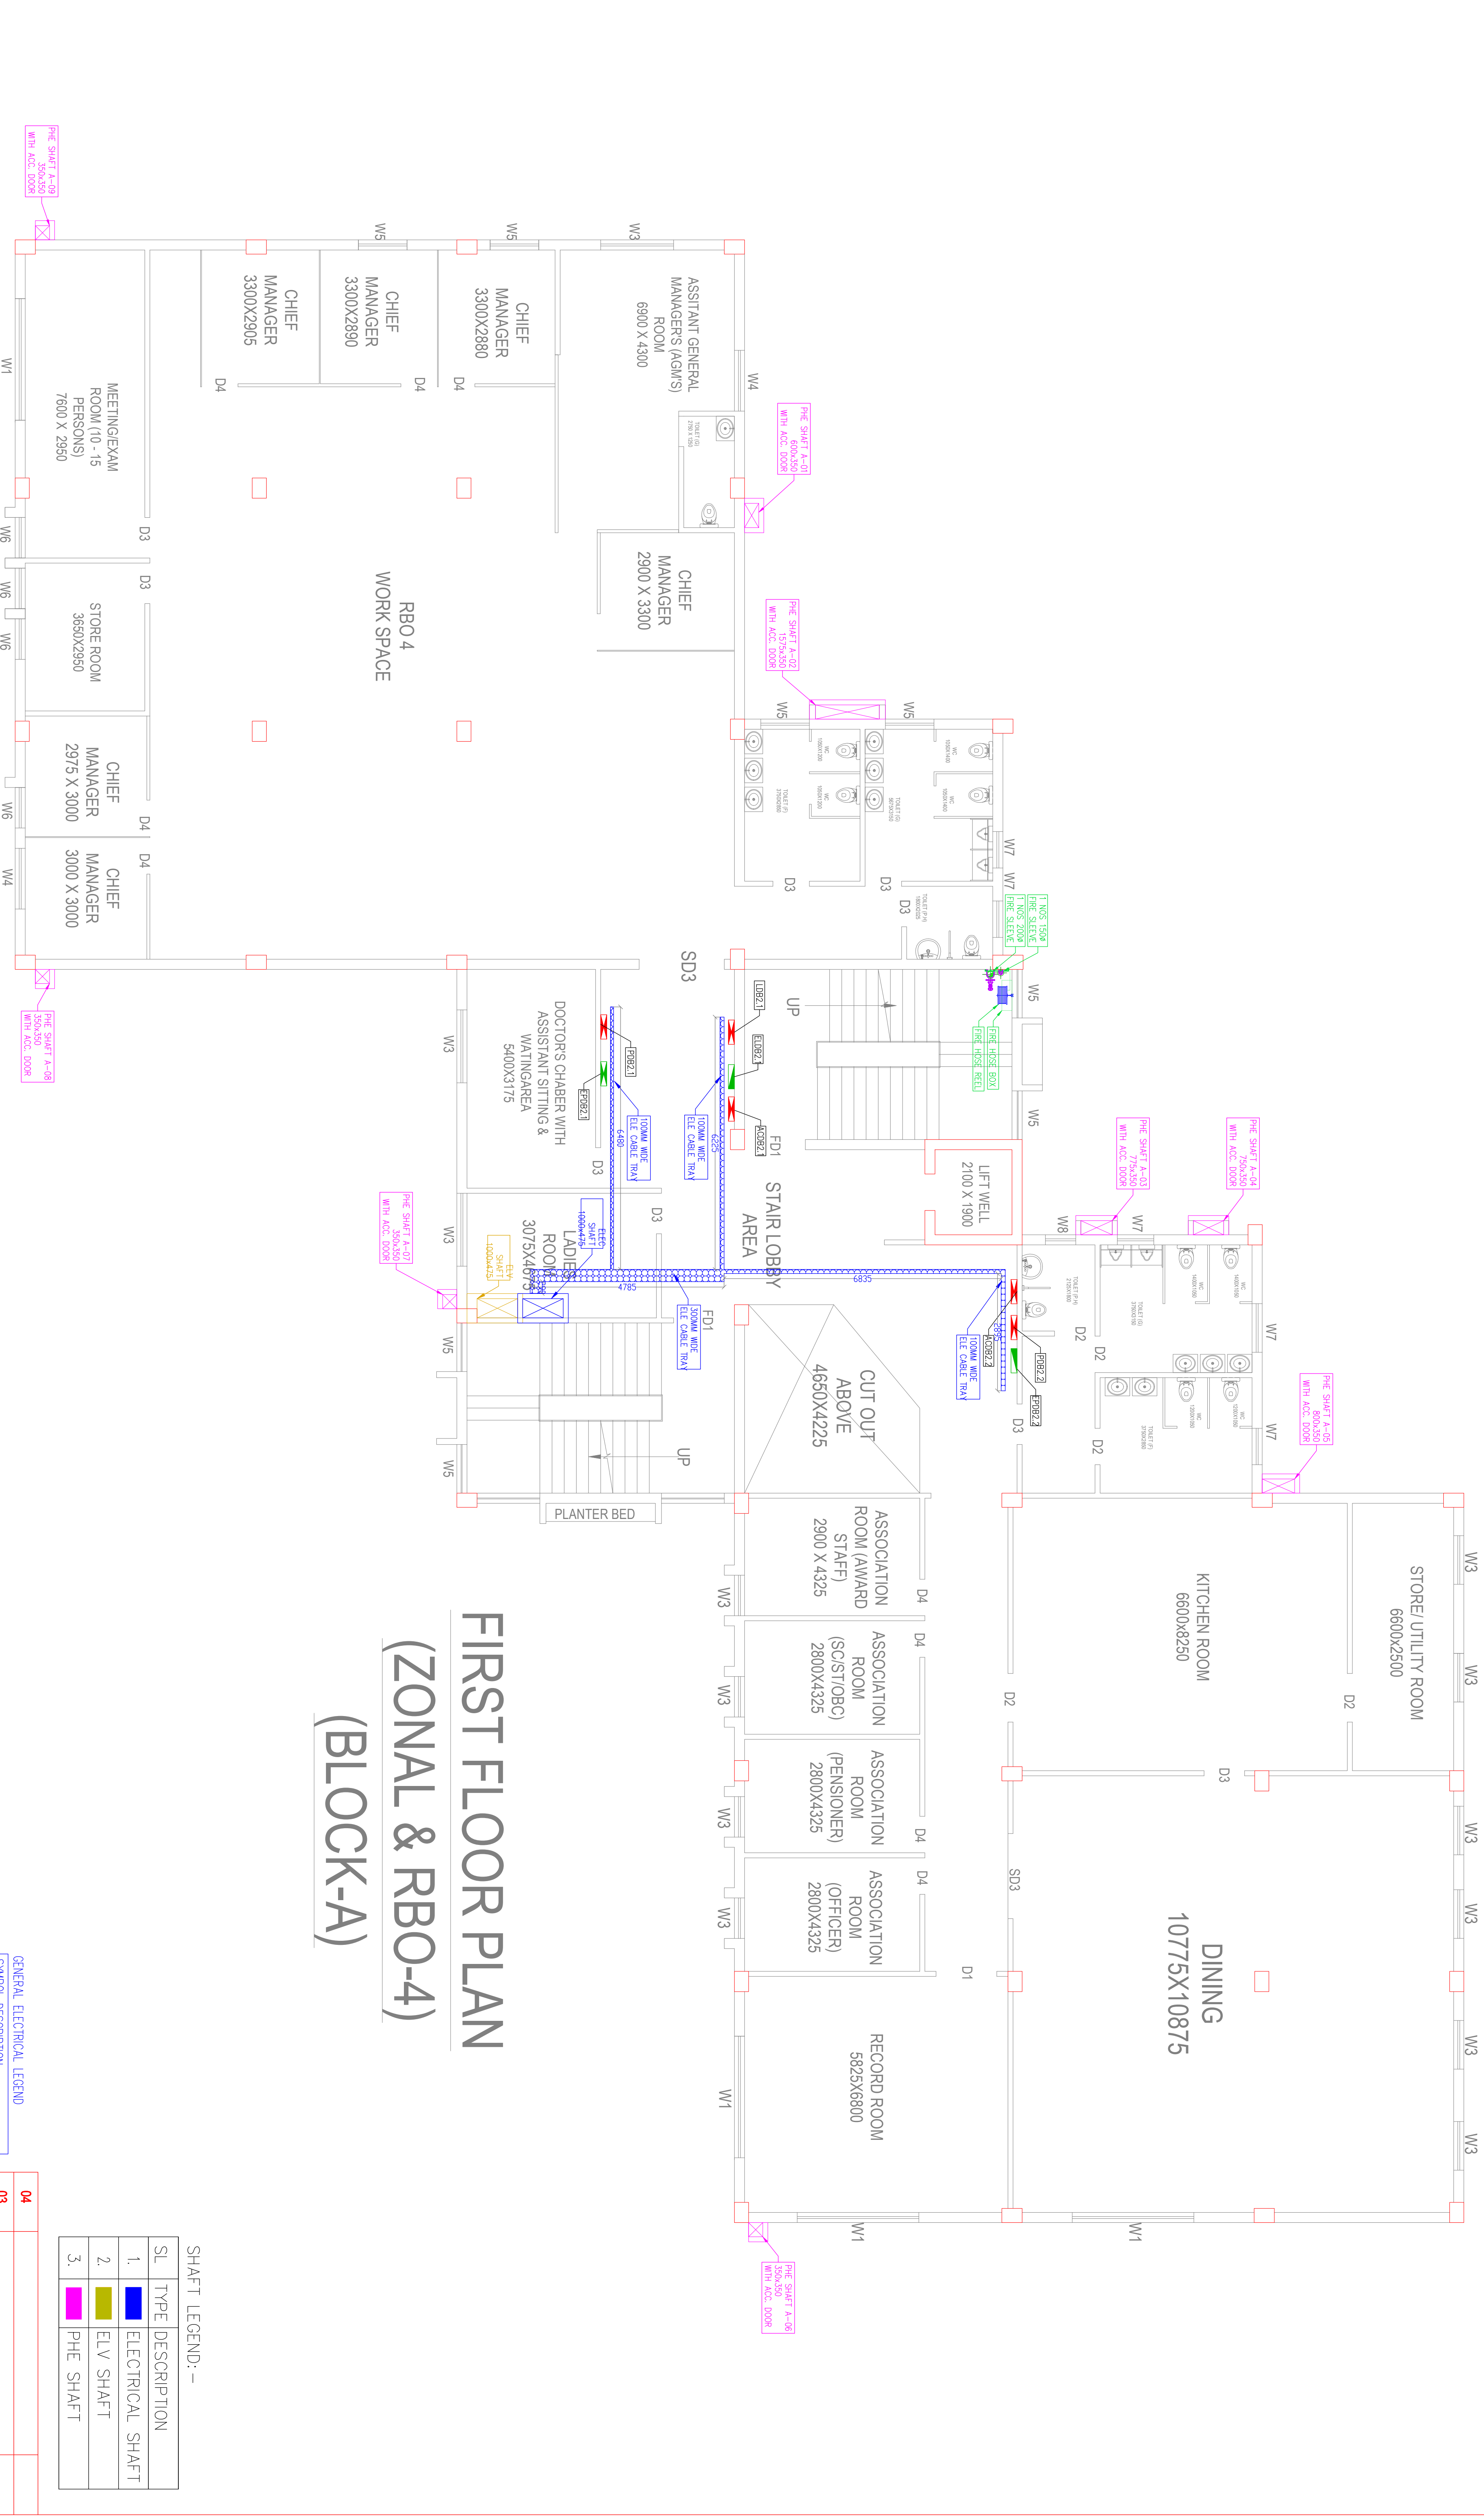

04		
03		
02		
01		
REV. NO.	DESCRIPTION	DATE
01		
02		
03		
04		
DATE	31.08.2025	
DRAWN	RD/SR	
CHECKED	SD	
APPRD.	JD	
JOB NO	488	
SCALE	1:75	
STATUS	DESIGN	
Drawing No.	SAN/488ELE-SCH-05	
SHEET NO.	REV.	
SHEET SIZE	RO	1/1
	AT	