


GROUND FLOOR PLAN
SBILD(HOSTEL BLOCK)
(BLOCK-C)

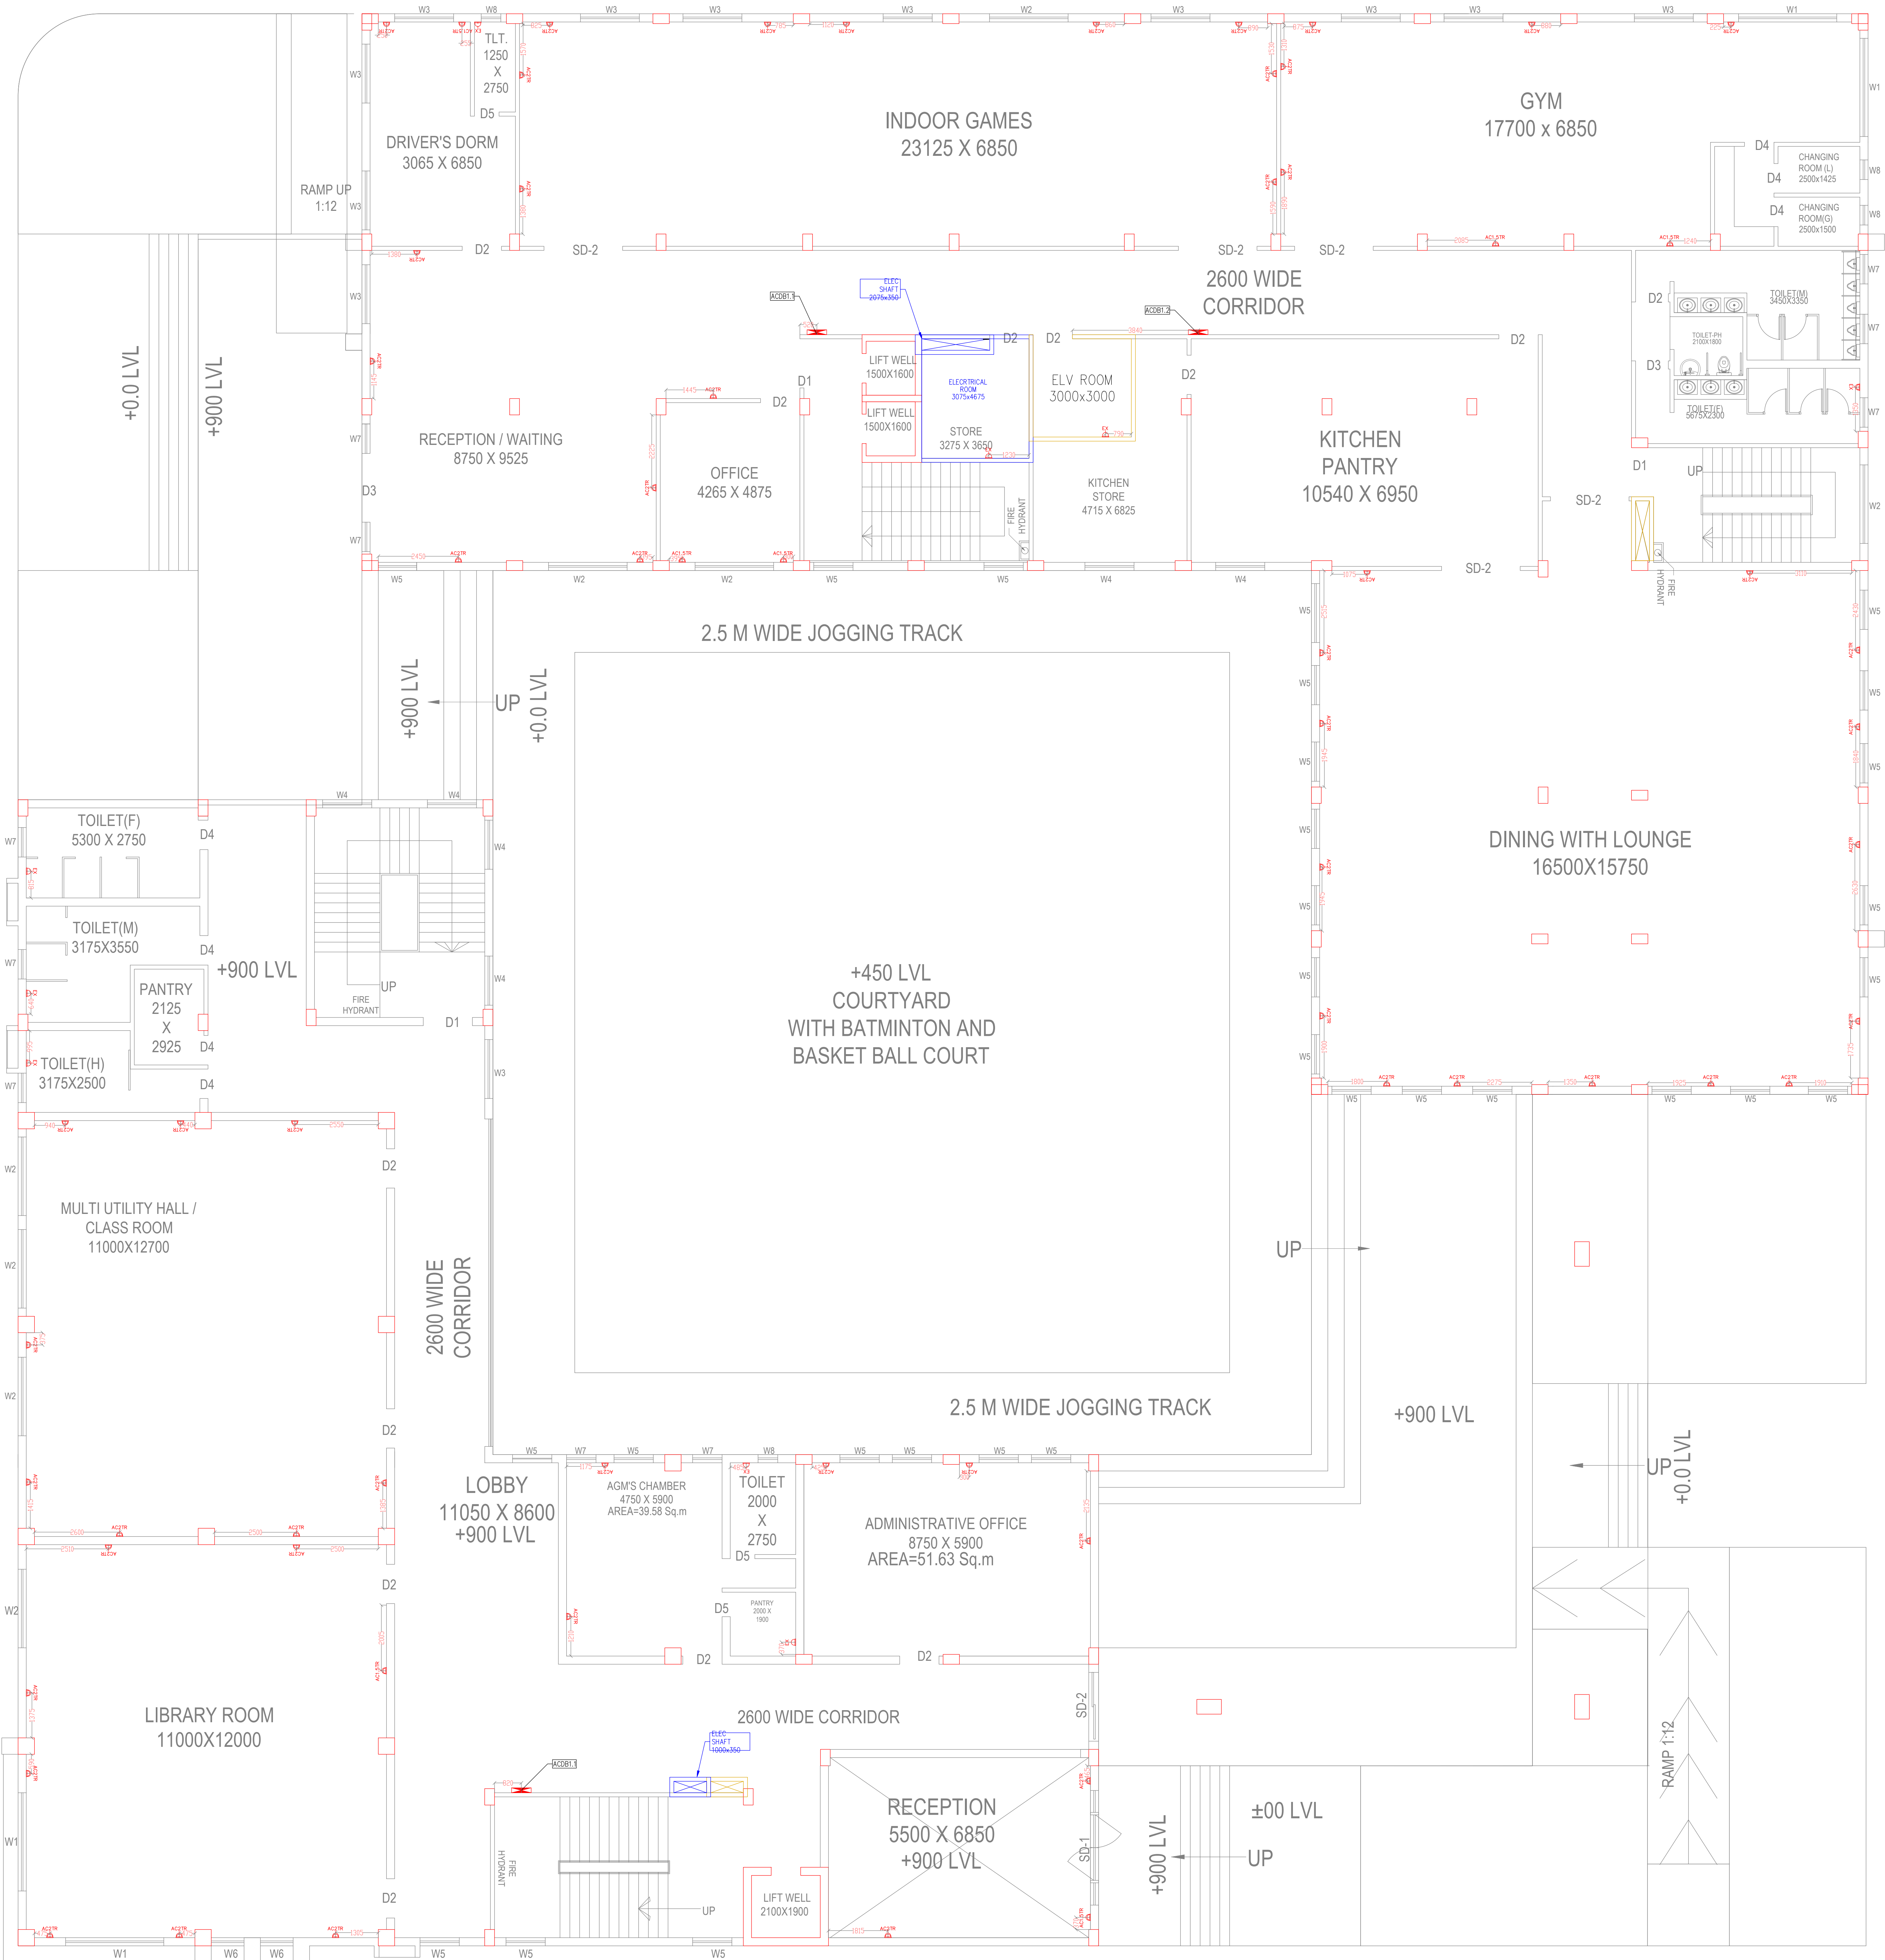

GROUND FLOOR PLAN
SBILD(ADMINISTRATIVE BLOCK)
(BLOCK-B)

ELECTRICAL FIXTURE AND POINT LEGEND	
SYMBOL RAW	DESCRIPTION
AC1TR	20A SOCKET FOR 1TR AC
AC1.5TR	20A SOCKET FOR 1.5TR AC
AC2TR	20A SOCKET FOR 2TR AC
EX	6/16A SOCKET FOR TOILET EXHAUST AT +150 FROM ABOVE LINTEL
EX	6A SOCKET FOR TOILET EXHAUST AT +150 FROM ABOVE LINTEL

NOTE:

1. ALL THE DIMENSIONS ARE IN MILIMETER, UNLESS OTHERWISE MENTIONED
2. ONLY WRITTEN DIMENSIONS TO BE FOLLOWED
3. DRAWING SHOULD NOT BE SCALED
4. SOME DETAILS MAY VARY DUE TO SITE CONDITION.

GENERAL ELECTRICAL LEGEND

SYMBOL DESCRIPTION

TPN DB (NORMAL)

ARCHITECT:
MISHRA & MISHRA CONSULTANCY
SERVICES PVT. LTD.
PO-394, SECTOR - III, SALT LAKE CITY, KOLKATA-700106
PH: 4004 5307, email : umes_mimcs_2006@yahoo.co.in
website : www.mimcsdesign.co

PROJECT :
PROPOSED TWO STORED AO & RBO AND THREE STORED SBILD BANK'S
BUILDING OF STATE BANK OF INDIA AT MAHATMA GANDHI AVENUE,
KHAIRANI NCH-441, I, 8 FLOT NO-18(P), C-3 FLOT NO-272(P), 340(P), 341(P),
342(P), 343, 344, 345(P), 346, 347, 348, 349, 350(P), 352, 353(P), 354(P),
355(P), 356(P), 357(P), 501(P), OF MOUDA-FARDIPUR, P.S-DURGAPUR, J.L
NO-74, DIST-PASCHIM BARDHAMAN, WEST BENGAL, PIN-713216

CLIENT :



04		
03		
02		
01		
REV. NO.	DESCRIPTION	DATE
DATE	24.08.2025	DRAWING TITLE:
DRAWN	AP	ELECTRICAL AC SOCKET LAYOUT FOR
CHECKED	SD	GROUND FLOOR BLOCK B & C
APPRD.	JD	Drawing No.
JOB NO	468	SAN/68/ELEPOWER/AC-11
SCALE	1:75	REV. SHEET SHEET
STATUS	DESIGN	R0 1/1 A0