


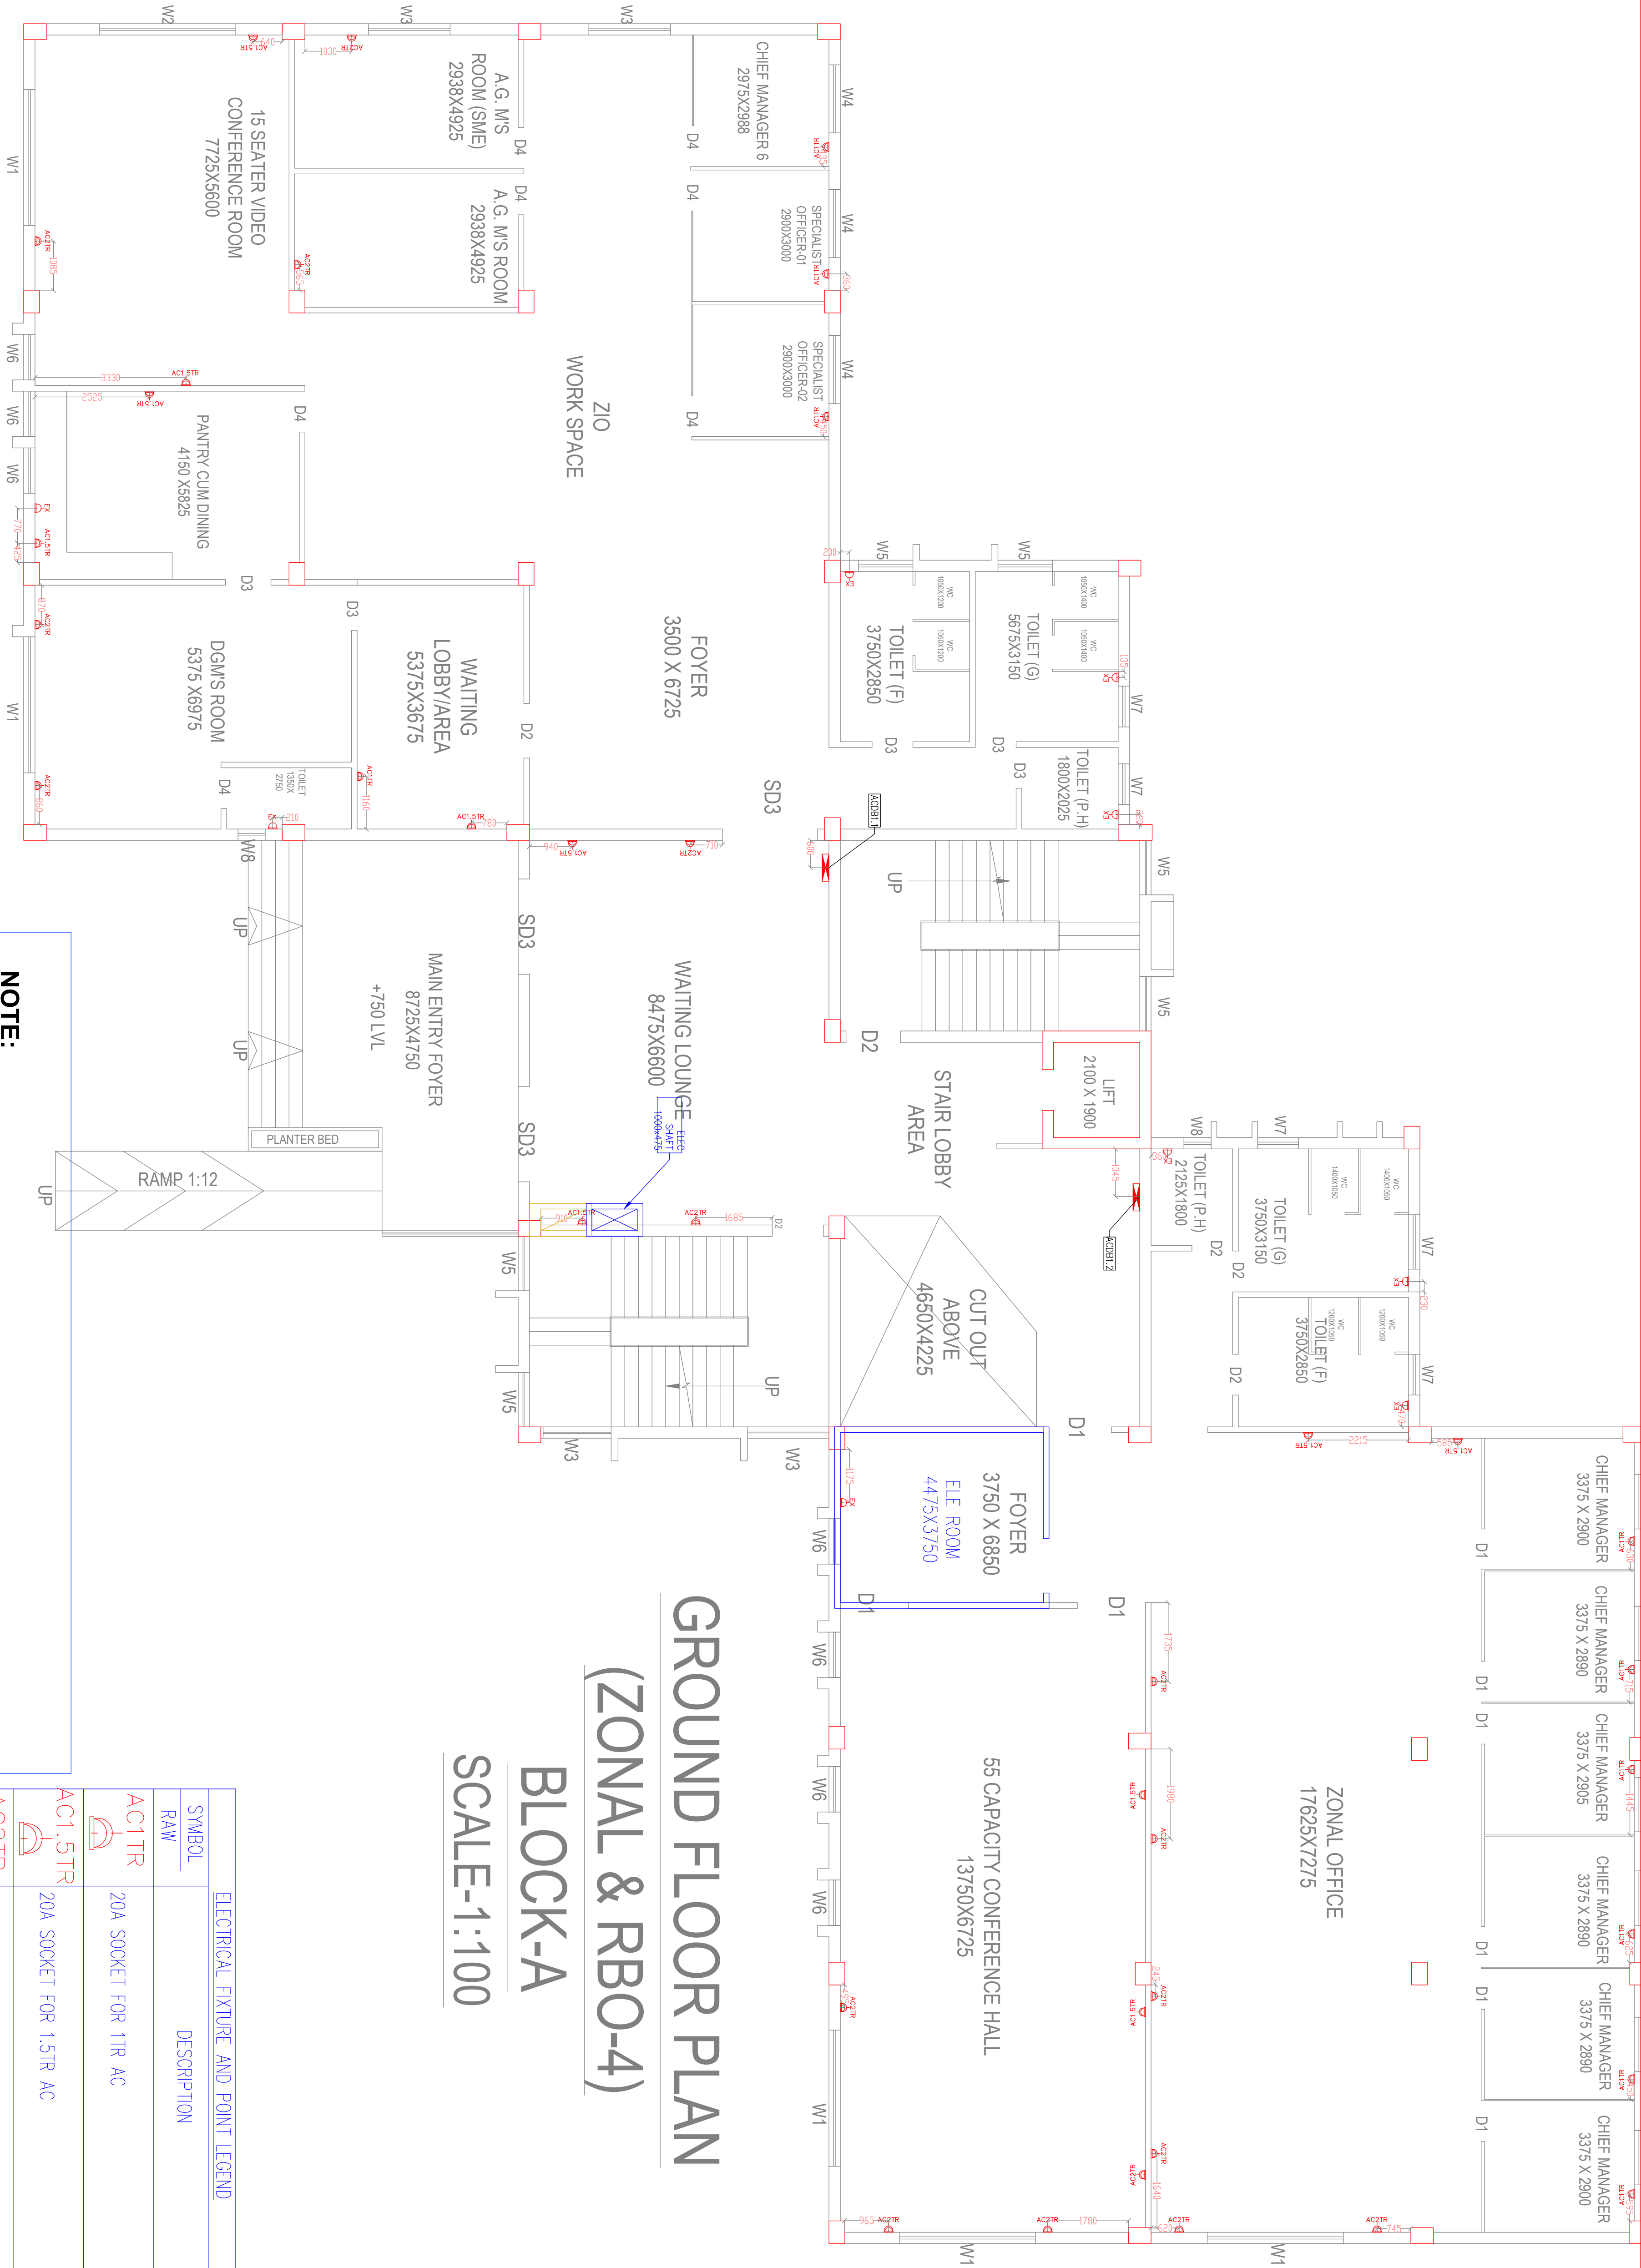

GROUND FLOOR PLAN

(ZONAL & RBO-4)

BLOCK-A

SCALE-1:100

GENERAL ELECTRICAL LEGEND

SYMBOL DESCRIPTION



TPN DB (NORMAL)

- NOTE:**
- ALL THE DIMENSIONS ARE IN MILLIMETER, UNLESS OTHERWISE MENTIONED
 - ONLY WRITTEN DIMENSIONS TO BE FOLLOWED
 - DRAWING SHOULD NOT BE SCALED
 - SOME DETAILS MAY VARY DUE TO SITE CONDITION.

ELECTRICAL FIXTURE AND POINT LEGEND	
SYMBOL	DESCRIPTION
RAW	
AC1TR	20A SOCKET FOR 1TR AC
AC1.5TR	20A SOCKET FOR 1.5TR AC
AC2TR	20A SOCKET FOR 2TR AC
EX	6/16A SOCKET FOR TOILET EXHAUST AT +150 FROM ABOVE LINTEL
EX	6A SOCKET FOR TOILET EXHAUST AT +150 FROM ABOVE LINTEL

ARCHITECT:
MISHRA & MISHRA CONSULTANCY SERVICES PVT. LTD.
FD-376, SECTOR - III, SALT LAKE CITY, KOLKATA-700106
Ph: 4004 5307 / email : umes_mncs_2006@yahoo.co.in
website : www.mncsdesign.co

PROJECT :
PROPOSED TWO STORED AQ & RBO AND THREE STORED BUILDINGS OF STATE BANK OF INDIA AT MAHATMA GANDHI MARG, KHATAJ NO.441, LB PLOT NO.18(P), CS PLOT NO.22(ZIP), 34(P), 341(P), 342(P), 343, 344, 345(P), 346, 347, 348, 349, 350(P), 352, 353(P), 354(P), 355(P), 356(P), 357(P), 301(P) OF MOUDA -FARIDPUR, P.S. -DURGAPUR, JL. NO-74, DIST-PASCHIM BANGDHAMAN, WEST BENGAL, PIN-713216.

CLIENT :

DATE: 24.08.2025

CHECKED: AP

APPRD: SD

JOB NO: 488

SCALE: 1/75

STATUS: DESIGN

REVISIONS

REV. NO.

DESCRIPTION

DATE

DRAWING TITLE:

ELECTRICAL AC SOCKET LAYOUT FOR GROUND FLOOR BLOCK A

Drawing No.

SAN/ABSELEPOWER/AC-09

REV. NO.

SHEET NO.

SHEET SIZE

AT