


Revised - 3
10'-2"

CORRIDOR 6'-4" WIDE
51'-6"

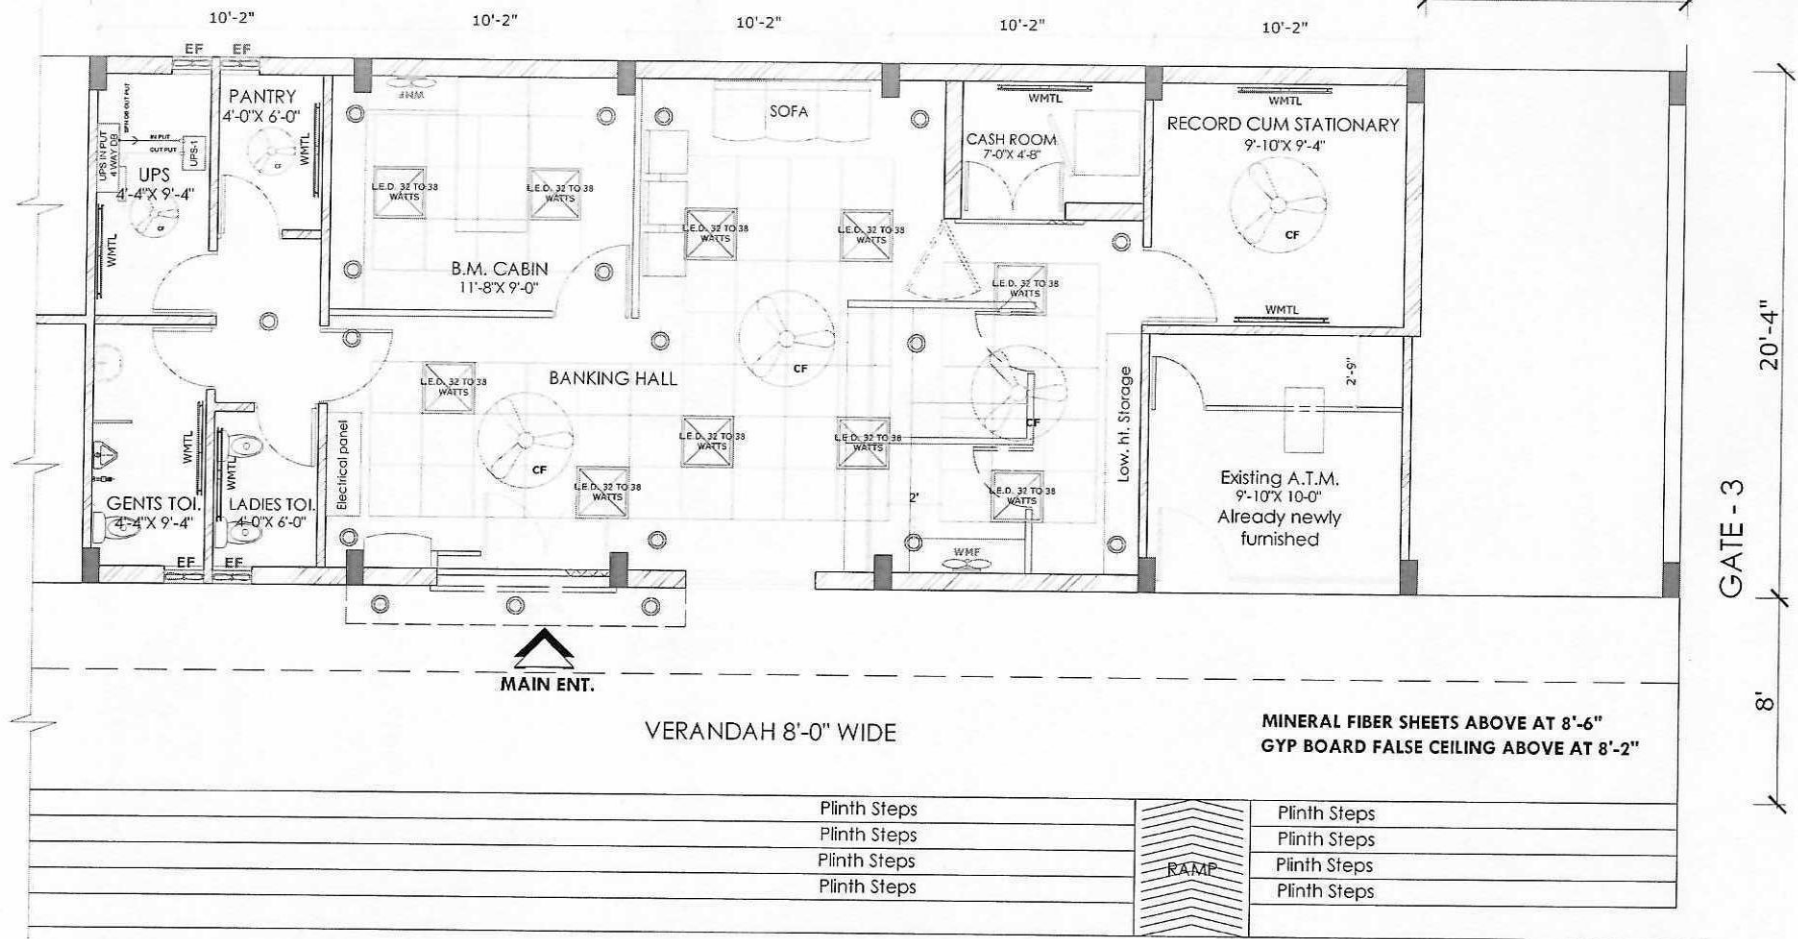

LEGEND

SYMBOL	DESCRIPTION OF ITEM
	600 MM. X600 MM. L.E.D. 32 TO 38 WATTS
	200 MM. DIA L.E.D. 15 TO 25 WATTS
	75 MM. DIA L.E.D. 3 WATTS SPOT LIGHT

LEGEND

SYMBOL	DESCRIPTION OF ITEM
	1200 MM. DIA. CEILING FAN
	WALL MOUNTED FAN
	EXHAUST FAN

MAIN ROAD

SYMBOL	DESCRIPTION OF ITEM
	WALL MOUNTED TUBE LIGHT
	CALL BELL POINT
	SWITCH BOARD

LEGEND

SYMBOL	DESCRIPTION OF ITEM
	WALL BRACKET POINT
	15 AMP. SWITCH & SOCKET BOARD
	AIR CONDITION POWER POINT
	5 AMP. SWITCH & SOCKET BOARD

PROPOSED FURNISHING, ELECTRIFICATION, DATA CABLING & AIR CONDITIONING OF NEW BRANCH PREMISES OF "S.B.I." AT KUBERESHWAR DHAM, SEHORE M.P.

**CEILING LAYOUT PLAN
ELECTRICAL LAYOUT PLAN**

JOB NO.: 22/2024
SCALE: 1/2"
DATE: 08.04.2024
CHECKED BY: *[Signature]*
Signature of Architect

DRAWING NO.: 22/2024
DATE: 08.04.2024
CHECKED BY: *[Signature]*
Signature of A.G.P.



MINU & SHARAT ASSOCIATES
architects, engineers, planners, interior designers
E-8 / 15, DOORSANCHAR NAGAR, GULNHAR COLONY,
BANGHRA KALAN, BHOPAL - 462 029
PHONE NOS. : (0755) 4273 986.
MOB. 9755945577

Revised - 3

10'-2"


CORRIDOR 6'-4" WIDE

51'-6"

20'-4"

GATE - 3

8'

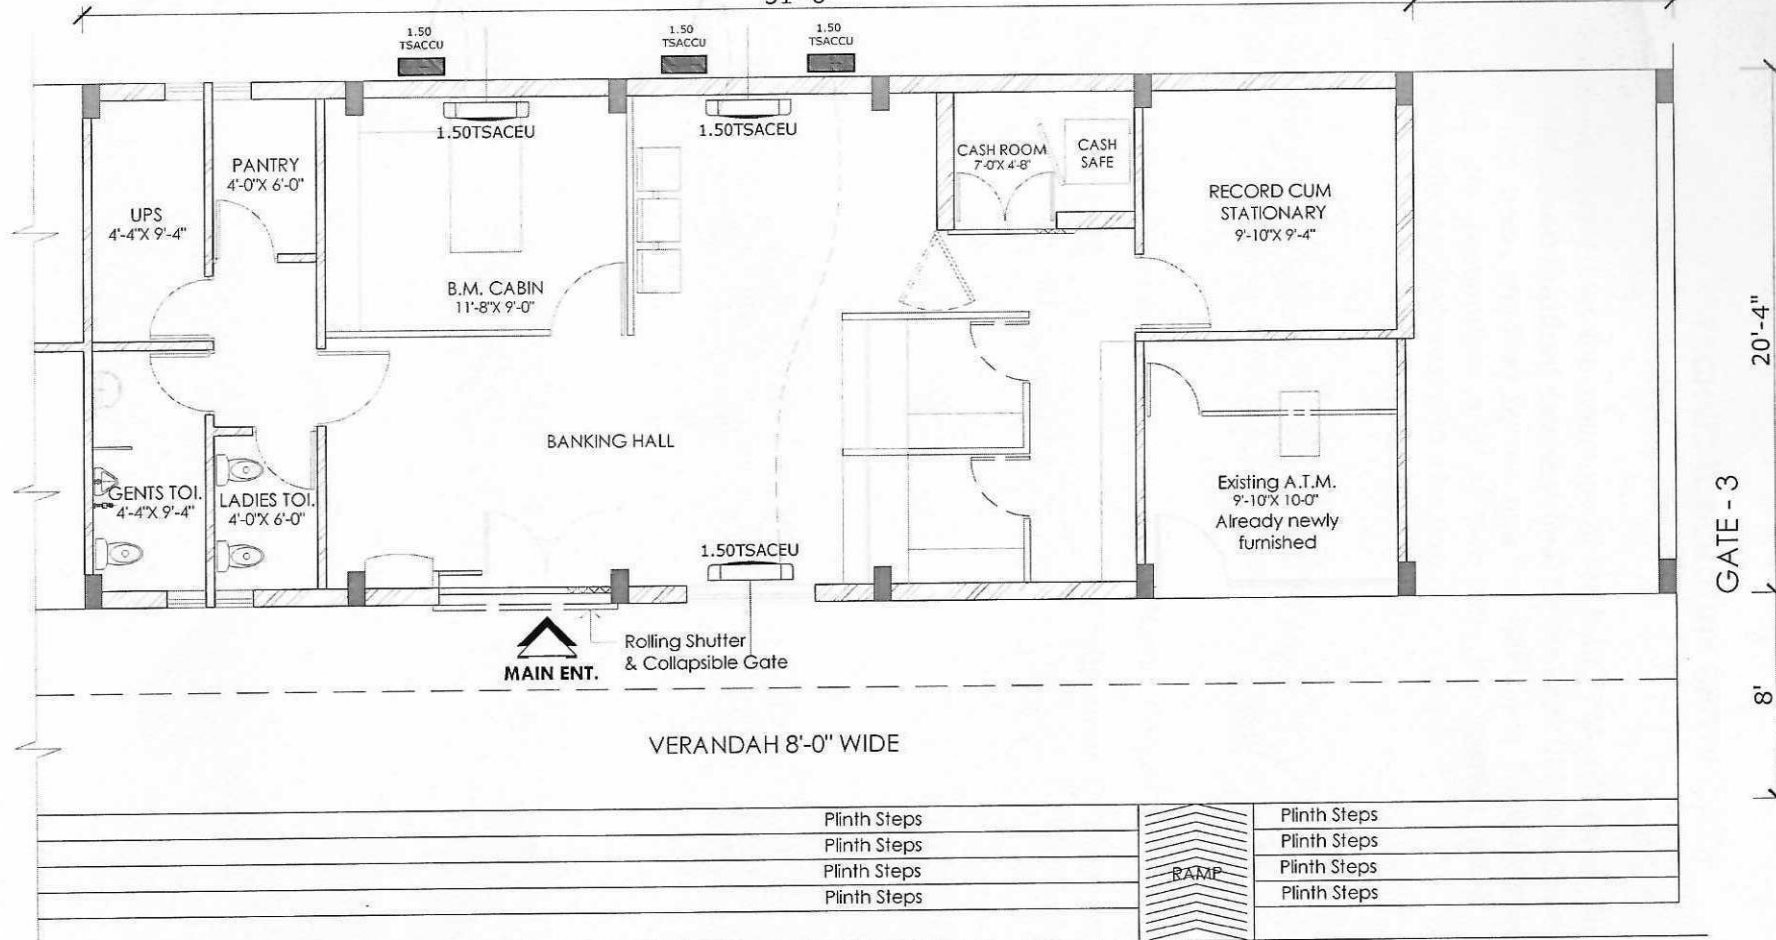


LEGEND OF AIR CONDITION

1.	1.50 TSACEU	= 1.50 TONNE SPLIT A.C. EVAPORATER UNIT
2.	1.50 TSACCU	= 1.50 TONNE SPLIT A.C. COMPRESSOR UNIT
3.	DP	= P.V.C. DRAIN PIPE

MAIN ROAD

PROPOSED FURNISHING, ELECTRIFICATION, DATA CABLING & AIR CONDITIONING OF NEW BRANCH PREMISES OF "S.B.I." AT KUBERESHWAR DHAM, SEHORE M.P.

A.C. LAYOUT PLAN

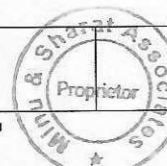

JOB NO. : 05/06/06	DRAWING NO. : 001
SCALE : 1/2"	DATE : 11/06/06
DEALT BY : <i>Minu</i>	CHECKED BY : <i>Sharat</i>
Signature of Architect	Signature of A.G.M.



MINU & SHARAT ASSOCIATES
architects, engineers, planners, interior designers
B-8 / 15, DOORANAGAR NAGAR, GURU RAMA COLONY,
SRINAGAR NAGAR, BHOPAL - 462 039
PHONE NOS. : (0755) 4173 906,
MOB. 975945577