



Key Plan :

Notes :

1. THIS DRAWING AND DESIGN IS THE PROPERTY OF THE DESIGNERS. NO PORTION MAY BE USED OR REPRODUCED WITHOUT THEIR WRITTEN PERMISSION.
2. THIS DRAWING IS TO BE READ IN CONJUNCTION WITH THE DESIGNERS SPECIFICATIONS AND CONDITIONS OF CONTRACT.
3. ALL DIMENSIONS ARE TO BE READ NOT SCALED.
4. ALL INDICATED LEVELS ARE FINISHED LEVELS UNLESS NOTED OTHERWISE.
5. ALL OUTER DIMENSIONS IN METER & INTERNAL DIMENSIONS IN MM.

A - 150Ø FIRE WET RISER
B - 150Ø SPRINKLER RISER
C - 80Ø SPRINKLER DRAIN PIPE
D - 80Ø FIRE DRAIN PIPE

SCHEDULE OF SPRINKLER PIPING

NUMBER OF SPR.	DIAMETER OF PIPE
upto 2	25mm Nominal Bore
3	32mm Nominal Bore
4 to 5	40mm Nominal Bore
6 to 10	50mm Nominal Bore
11 to 20	65mm Nominal Bore
21 to 60	80mm Nominal Bore
61 to 100	100mm Nominal Bore
above 101	150mm Nominal Bore

LEGEND

	PENDENT TYPE SPRINKLER
	FLOW INDICATING SWITCH
	BUTTERFLY VALVE
	TESTING TUBE (SIGHT GLASS) WITH 25# DRAIN VALVE
	FIRE HOSE CABINET 1200X600X2100mm
	EXTERNAL FIRE HYDRANT
	FIRE LINE
	4.5 KG CO2 PORTABLE FIRE EXTINGUISHER
	6 KG ABC DRY POWDER PORTABLE FIRE EXTINGUISHER
	50 Kg. Mech. Foam type extinguisher
	22.5 Kg. CO2 Fire Extinguisher

MEP - CONSULTANT



 
AD CONSULTANTS
C-418, 4th Floor Vignette Plaza | Email: info@adconsultants.co.in
Sector 81 Faridabad-121002 | Website: www.adconsultants.co.in
HARYANA INDIA | Ph: +91-9811-663885

DATE: 25-08-2025 | PREPARED BY: ANSHU SHARMA

PROJECT TITLE

PROPOSED CONSTRUCTION OF MULTI STOREY BUILDING FOR SBI BANK AT KALYANPUR NEAR CIRCUIT HOUSE, DEOGARH

CLIENT :-



ARCHITECT:-



DRAWING STAGE:-

TENDER DRAWING

DRAWING TITLE:-

BASEMENT
(LVL -5.1M)

SCALE	ARCH./ENGR.:	DATE	REV.
A1 SHEET--	DRAWN	25-08-2025	
A2 SHEET--	CHECKED		
A3 SHEET--	APPROVED		

DRAWING NO.
DKA/SBI/FF-01

NORTH



Key Plan :

Notes :

1. THIS DRAWING AND DESIGN IS THE PROPERTY OF THE DESIGNERS. NO PORTION MAY BE USED OR REPRODUCED WITHOUT THEIR WRITTEN PERMISSION.
2. THIS DRAWING IS TO BE READ IN CONJUNCTION WITH THE DESIGNERS SPECIFICATIONS AND CONDITIONS OF CONTRACT.
3. ALL DIMENSIONS ARE TO BE READ NOT SCALED.
4. ALL INDICATED LEVELS ARE FINISHED LEVELS UNLESS NOTED OTHERWISE.
5. ALL OUTER DIMENSIONS IN METER & INTERNAL DIMENSIONS IN MM.

- A — 150Ø FIRE WET RISER
B — 150Ø SPRINKLER RISER
C — 80Ø SPRINKLER DRAIN PIPE
D — 80Ø FIRE DRAIN PIPE

SCHEDULE OF SPRINKLER PIPING	
NUMBER OF SPR.	DIAMETER OF PIPE
upto 2	25mm Nominal Bore
3	32mm Nominal Bore
4 to 5	40mm Nominal Bore
6 to 10	50mm Nominal Bore
11 to 20	65mm Nominal Bore
21 to 60	80mm Nominal Bore
61 to 100	100mm Nominal Bore
above 101	150mm Nominal Bore

- ⊕ PENDENT TYPE SPRINKLER
⊗ FLOW INDICATING SWITCH
⊕ BUTTERFLY VALVE
⊕ TESTING TUBE (SIGHT GLASS) WITH 25Ø DRAIN VALVE
⊕ FIRE HOSE CABINET 1200X600X2100mm
⊕ EXTERNAL FIRE HYDRANT
⊕ FIRE LINE
⊕ 4.5 KG CO2 PORTABLE FIRE EXTINGUISHER
⊕ 6 KG ABC DRY POWDER PORTABLE FIRE EXTINGUISHER

MEP - CONSULTANT

AD CONSULTANTS
C-410, 4th Floor, New Plaza, Sector-17, Faridkot-151001
Tel: 91-174-2633333/2633334 Email: info@adconsultants.co.in

PROJECT TITLE
PROPOSED CONSTRUCTION OF MULTI STOREY BUILDING FOR SBI BANK AT KALYANPUR NEAR CIRCUIT HOUSE, DEODGARH


CLIENT :
SBI STATE BANK OF INDIA PATNA

ARCHITECT :
D K & ASSOCIATES
(ARCHITECTS & INTERIOR DESIGNERS)
A-308, DEFENCE COLONY, NEW DELHI - 110048
Tel: 91-11-2633333/2633334 Email: info@dkandassociates.com

DRAWING STAGE :
TENDER DRAWING

DRAWING TITLE :
GROUND FLOOR PLAN (LVL.+1.2M)

SCALE	ARCH./ENGR.	DATE	REV.
A1 SHEET: A2 SHEET:	DRAWN: ANSHU CHECKED: GAURAV	7-02-2025 APPROVED	
DRAWING NO. DKA/SBI/ID/FF-02		NORTH	

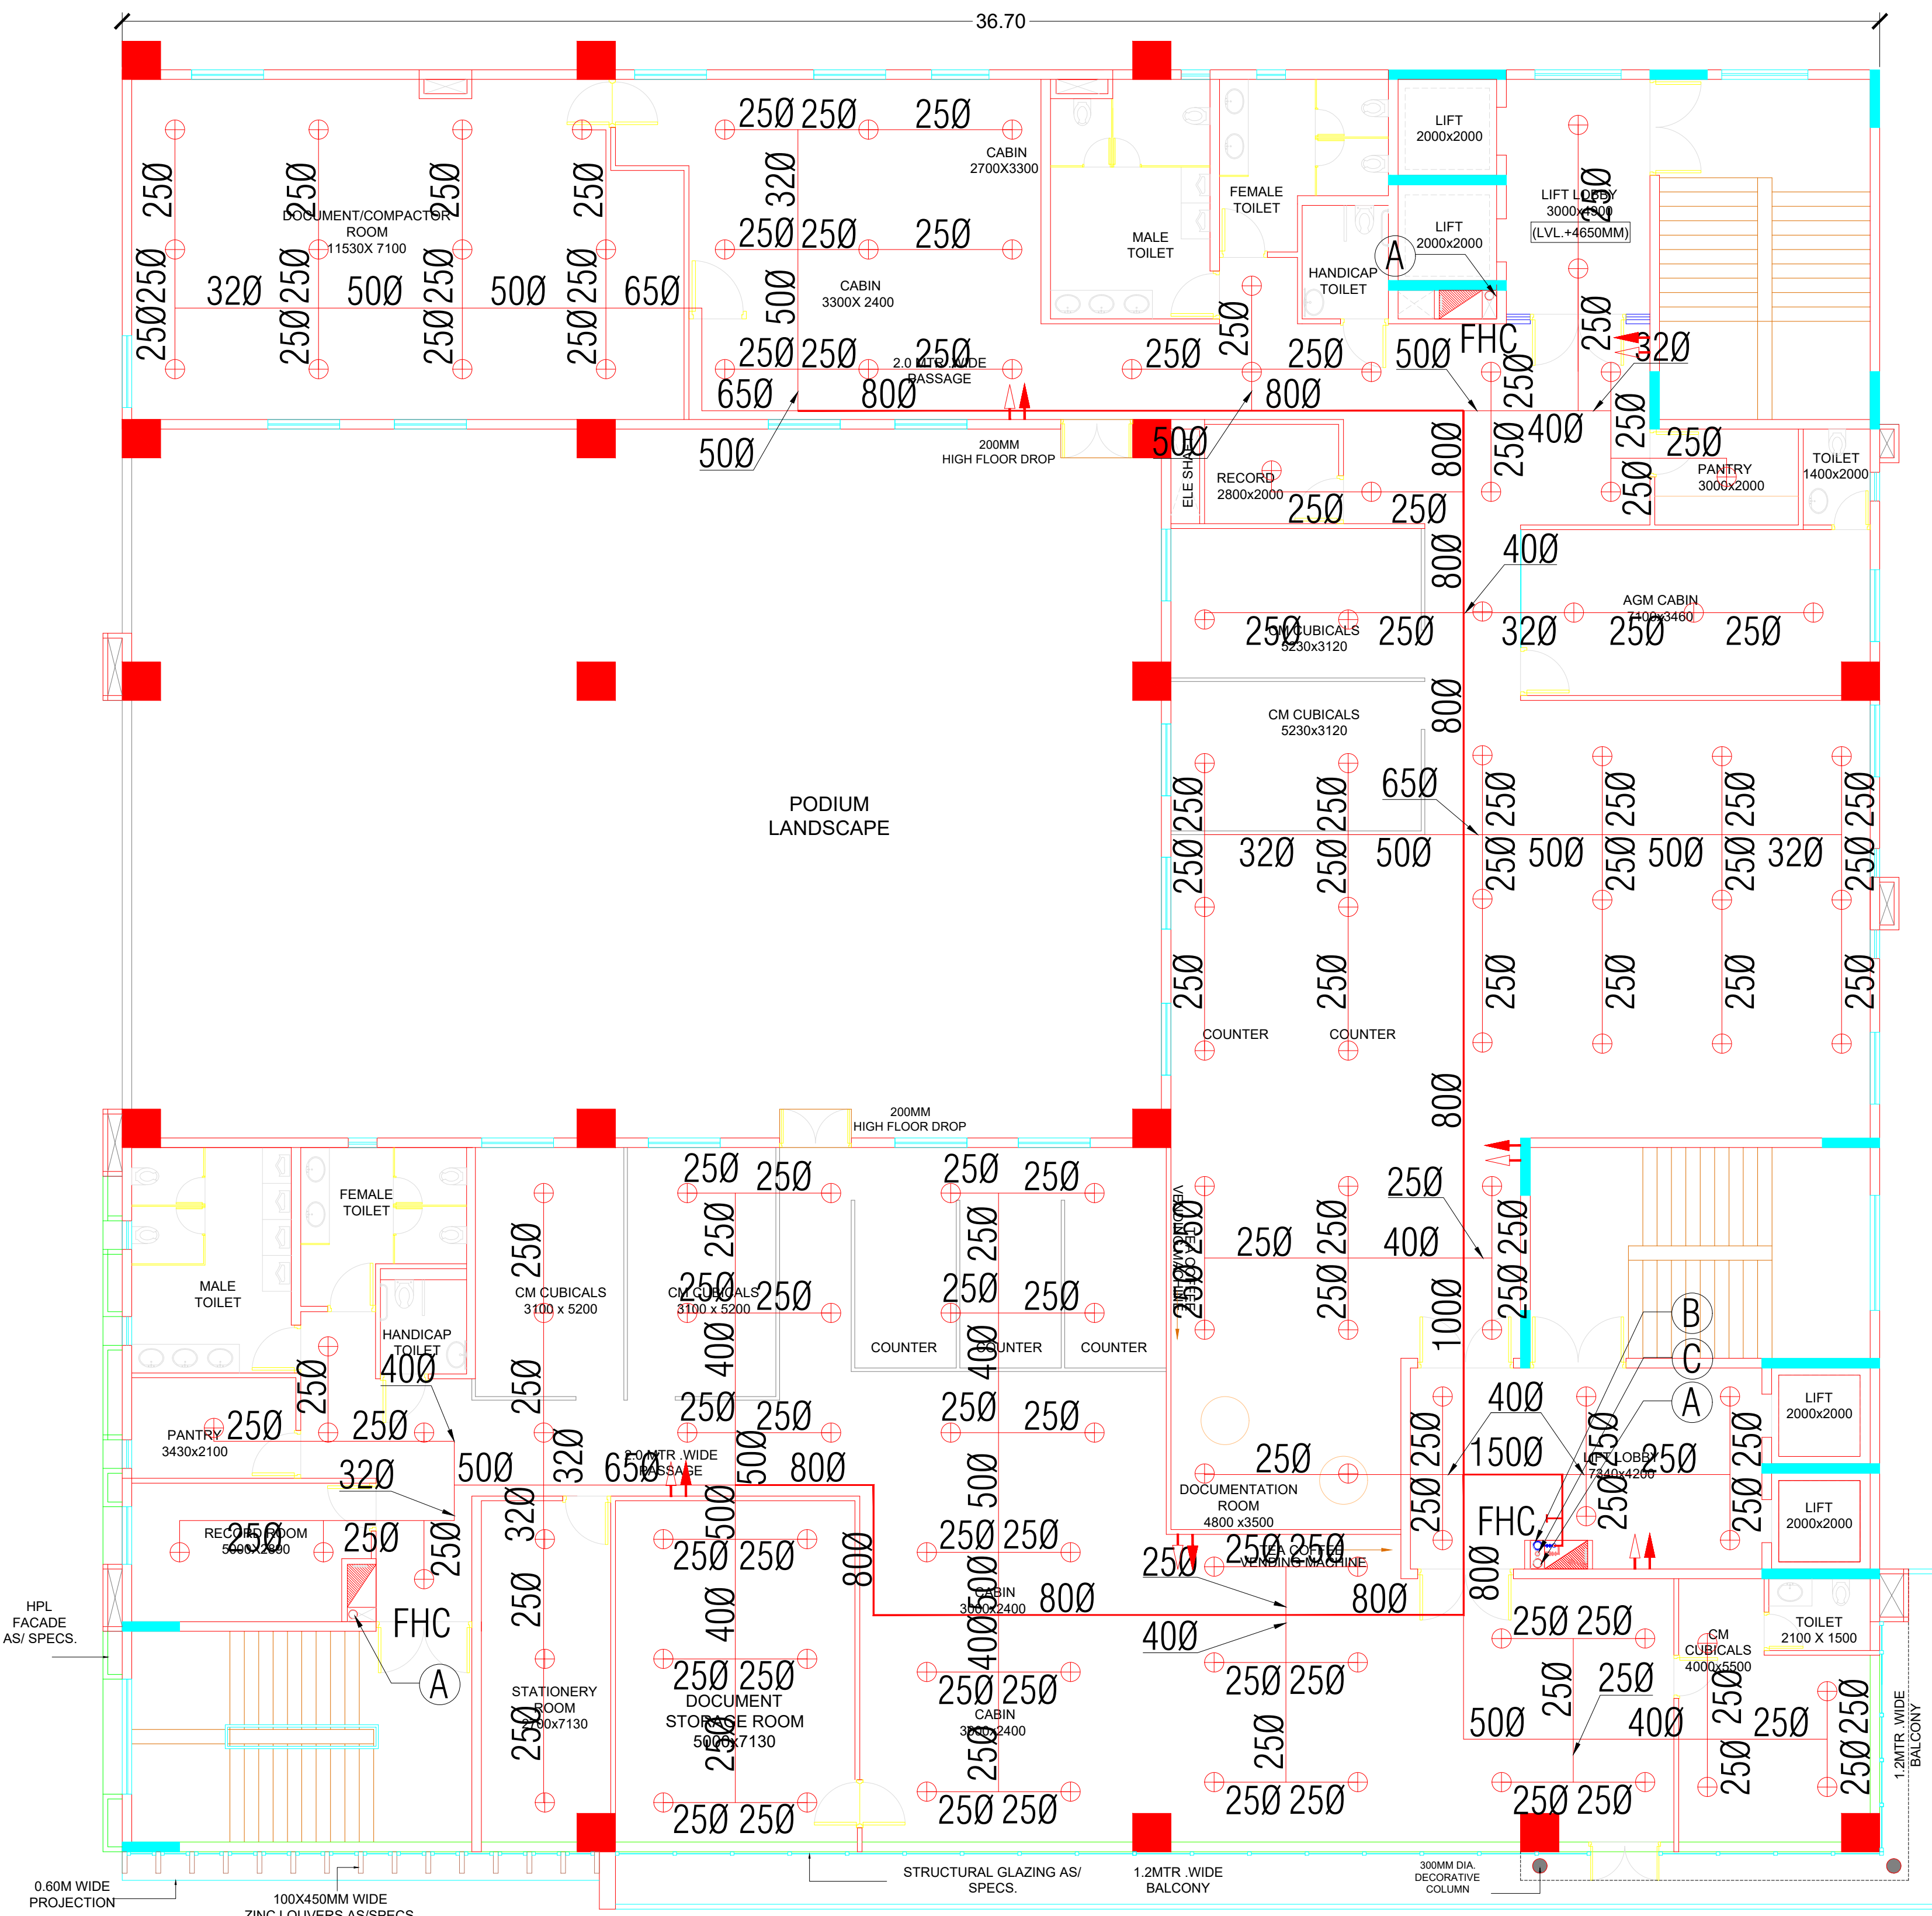

Key Plan :

Notes :
1. THIS DRAWING AND DESIGN IS THE PROPERTY OF THE DESIGNERS. NO PORTION MAY BE USED OR REPRODUCED WITHOUT THEIR WRITTEN PERMISSION.
2. THIS DRAWING IS TO BE READ IN CONJUNCTION WITH THE DESIGNERS SPECIFICATIONS AND CONDITIONS OF CONTRACT.
3. ALL DIMENSIONS ARE TO BE READ NOT SCALED.
4. ALL INDICATED LEVELS ARE FINISHED LEVELS UNLESS NOTED OTHERWISE.
5. ALL OUTER DIMENSIONS IN METER & INTERNAL DIMENSIONS IN MM.

A – 150Ø FIRE WET RISER
B – 150Ø SPRINKLER RISER
C – 80Ø SPRINKLER DRAIN PIPE
D – 80Ø FIRE DRAIN PIPE

SCHEDULE OF SPRINKLER PIPING	
NUMBER OF SPR.	DIAMETER OF PIPE
upto 2	25mm Nominal Bore
3	32mm Nominal Bore
4 to 5	40mm Nominal Bore
6 to 10	50mm Nominal Bore
11 to 20	65mm Nominal Bore
21 to 60	80mm Nominal Bore
61 to 100	100mm Nominal Bore
above 101	150mm Nominal Bore

⊕	PENDENT TYPE SPRINKLER
⊗	FLOW INDICATING SWITCH
+	BUTTERFLY VALVE
+	TESTING TUBE (SIGHT GLASS) WITH 25Ø DRAIN VALVE
+	FIRE HOSE CABINET 1200X600X2100mm
+	EXTERNAL FIRE HYDRANT
+	FIRE LINE
+	4.5 KG CO2 PORTABLE FIRE EXTINGUISHER
+	6 KG ABC DRY POWDER PORTABLE FIRE EXTINGUISHER

MEP - CONSULTANT

AD CONSULTANTS

C-419, 4th Floor Vigneti Plaza
Sector-41, Faridabad-121002
HARYANA, INDIA

Email: info@adconsultants.co.in
Website: www.adconsultants.co.in
Ph: +91-9811-623885

CONSULTANTS

ATUL PANDEY

MECHANICAL

PROJECT TITLE
PROPOSED CONSTRUCTION OF MULTI STOREY BUILDING FOR SBI BANK AT KALYANPUR NEAR CIRCUIT HOUSE, DEOGARH

CLIENT :-
SBI STATE BANK OF INDIA PATNA

ARCHITECT:-
D K & ASSOCIATES
(ARCHITECTS & INTERIOR DESIGNERS)
A-385, DEFENCE COLONY, NEW DELHI - 110024.
Tel: 91-11-26333312/918 Email: dkao2000@gmail.com


DRAWING STAGE:-
CONCEPT DRAWING

DRAWING TITLE:-
FIRST FLOOR PLAN
(LVL. +4.65M)

SCALE	ARCH./ENG./:	DATE	REV.
A1 SHEET:-	DRAWN	7-02-2025	
A2 SHEET:-	CHECKED	APPROVED	
A3 SHEET:-	GAURAV		

DRAWING NO.
DKA/SBI/TD/FF-03

NORTH

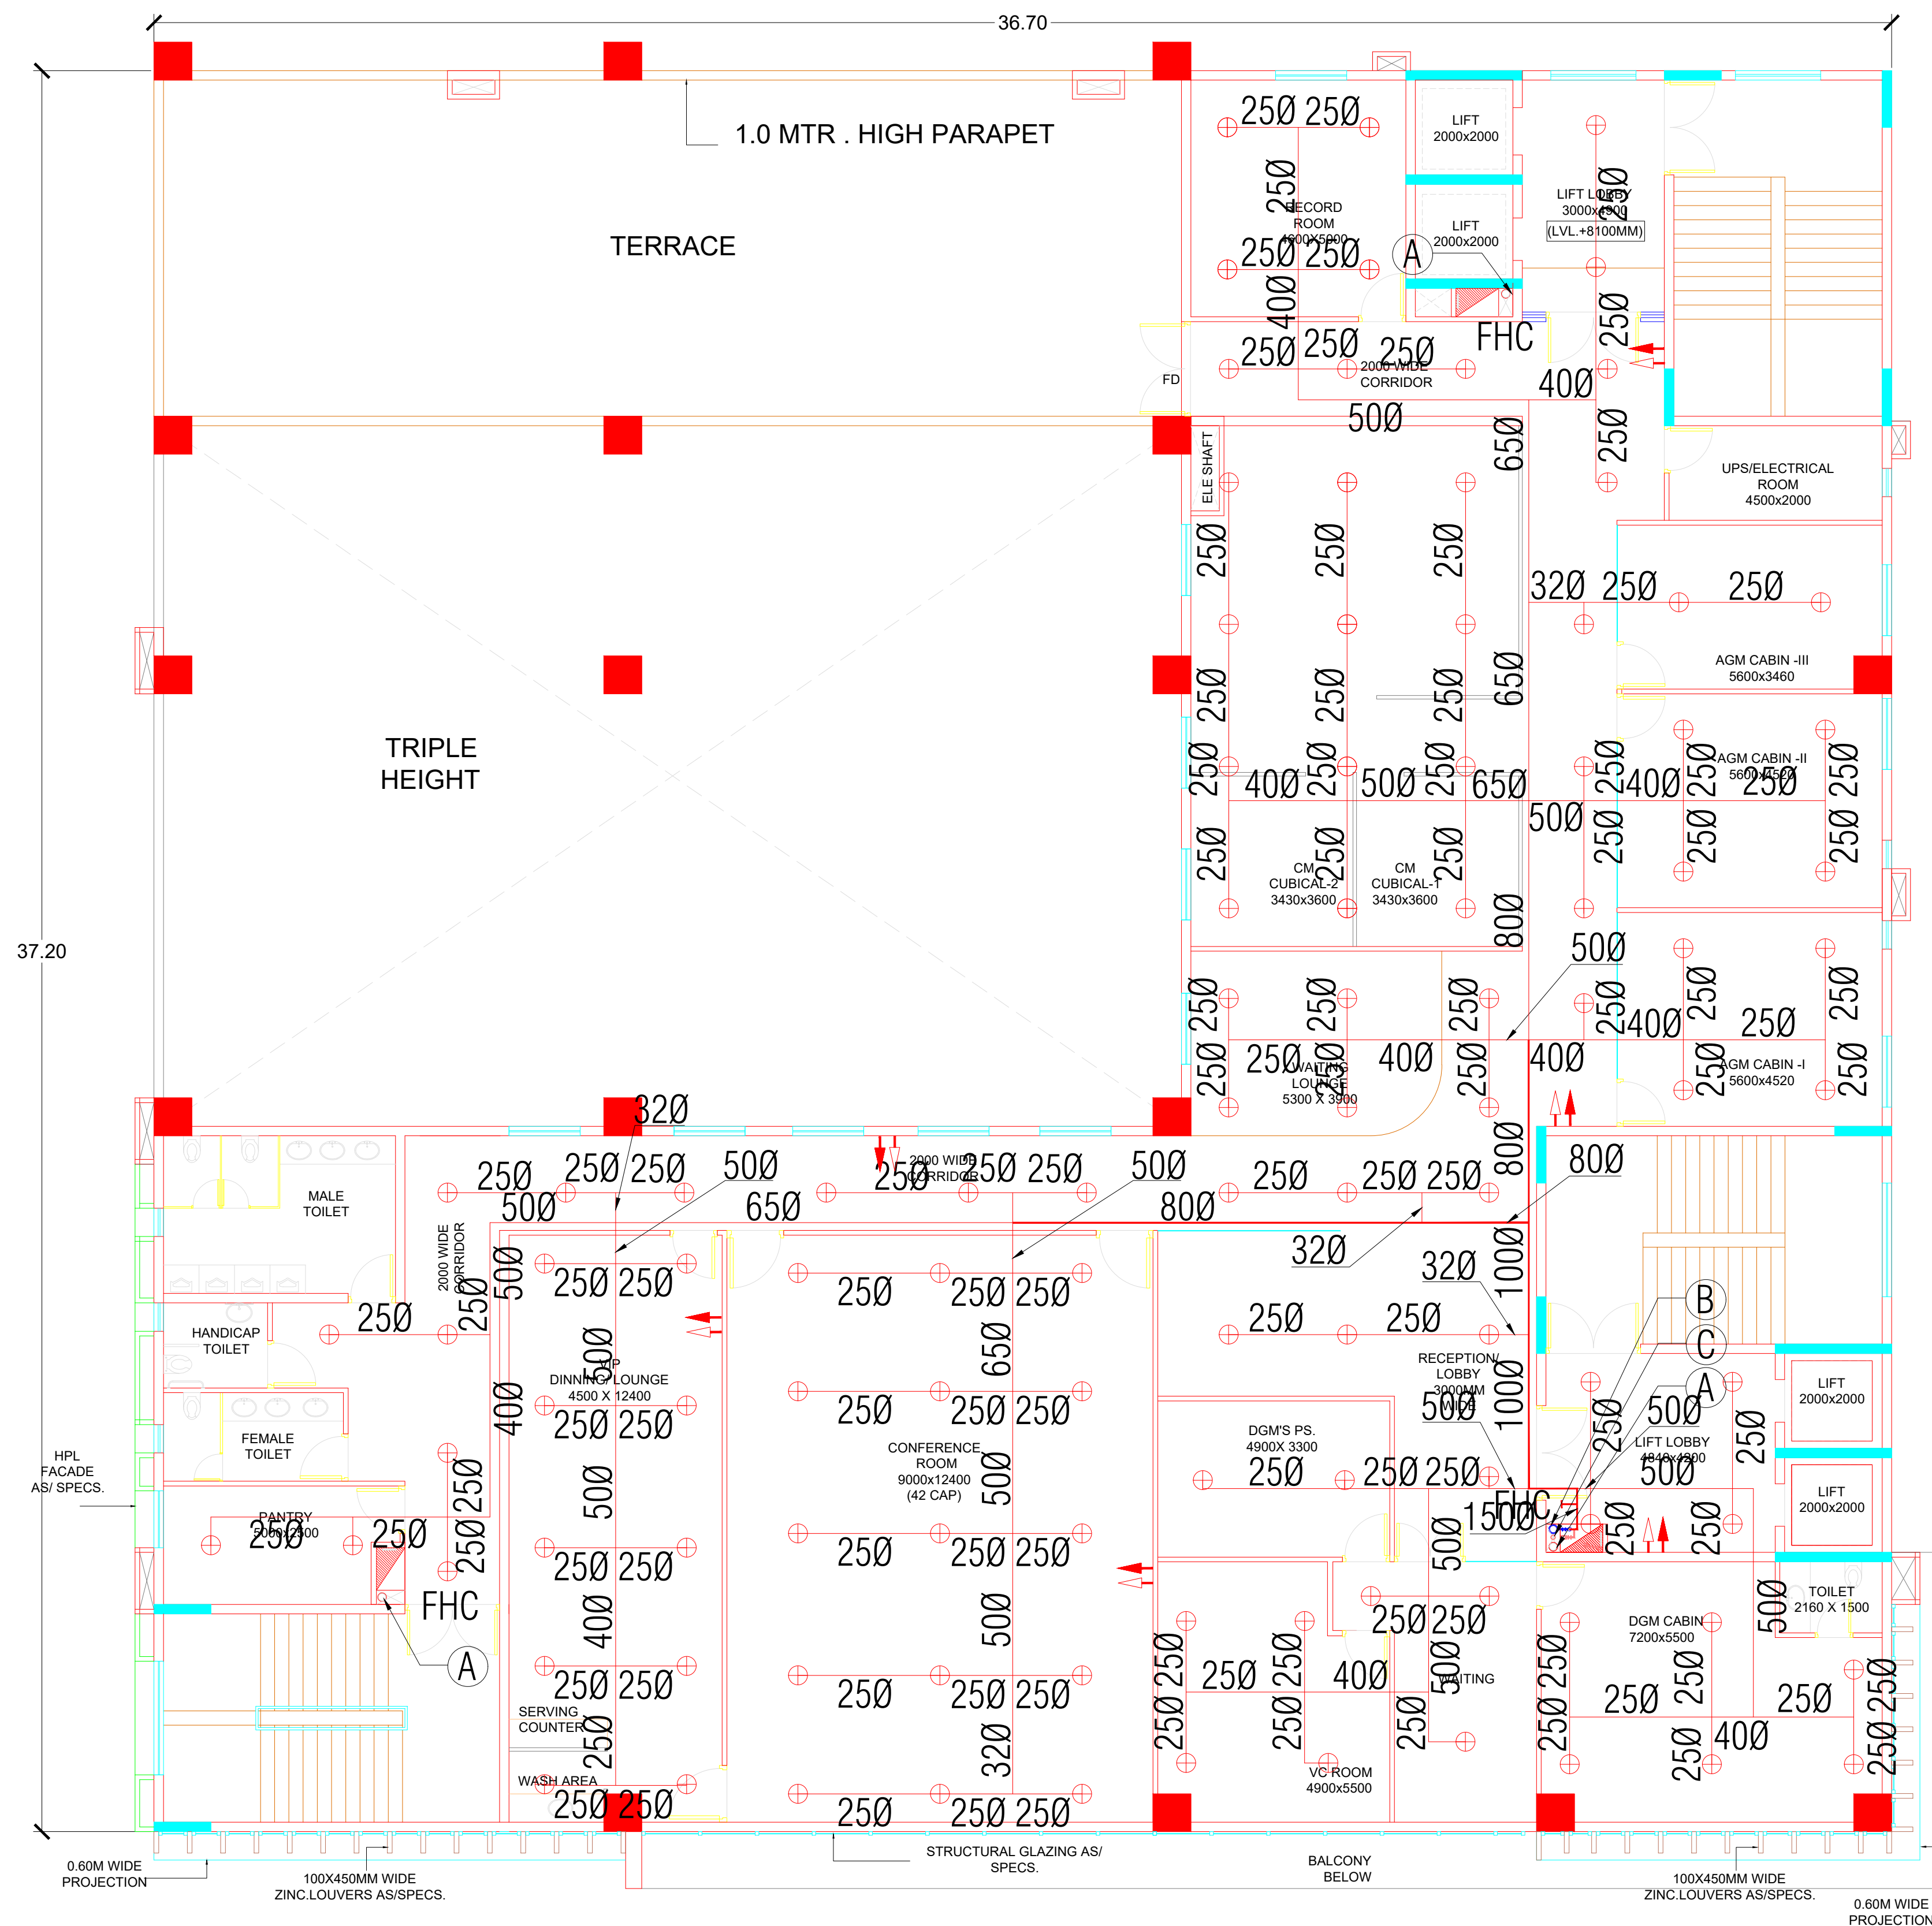

Key Plan :

Notes :

1. THIS DRAWING AND DESIGN IS THE PROPERTY OF THE DESIGNERS. NO PORTION MAY BE USED OR REPRODUCED WITHOUT THEIR WRITTEN PERMISSION.
2. THIS DRAWING IS TO BE READ IN CONJUNCTION WITH THE DESIGNERS SPECIFICATIONS AND CONDITIONS OF CONTRACT.
3. ALL DIMENSIONS ARE TO BE READ NOT SCALED.
4. ALL INDICATED LEVELS ARE FINISHED LEVELS UNLESS NOTED OTHERWISE.
5. ALL OUTER DIMENSIONS IN METER & INTERNAL DIMENSIONS IN MM.

- A - 150Ø FIRE WET RISER
B - 150Ø SPRINKLER RISER
C - 80Ø SPRINKLER DRAIN PIPE
D - 80Ø FIRE DRAIN PIPE

SCHEDULE OF SPRINKLER PIPING

NUMBER OF SPR.	DIAMETER OF PIPE
upto 2	25mm Nominal Bore
3	32mm Nominal Bore
4 to 5	40mm Nominal Bore
6 to 10	50mm Nominal Bore
11 to 20	65mm Nominal Bore
21 to 60	80mm Nominal Bore
61 to 100	100mm Nominal Bore
above 101	150mm Nominal Bore

⊕	PENDENT TYPE SPRINKLER
⊗	FLOW INDICATING SWITCH
+	BUTTERFLY VALVE
+	TESTING TUBE (SIGHT GLASS) WITH 25Ø DRAIN VALVE
+	FIRE HOSE CABINET 1200X600X2100mm
ETH	EXTERNAL FIRE HYDRANT
F	FIRE LINE
+	4.5 KG CO2 PORTABLE FIRE EXTINGUISHER
+	6 KG ABC DRY POWDER PORTABLE FIRE EXTINGUISHER

MEP - CONSULTANT	AD CONSULTANTS
	C-419, 4th Floor Vigneti Plaza, Sector-41, Faridkot-151002, PUNJAB, INDIA
CONSULTANTS	PH: +91-9811-682885

PROJECT TITLE
PROPOSED CONSTRUCTION OF MULTI STOREY BUILDING FOR SBI BANK AT KALYANPUR NEAR CIRCUIT HOUSE, DEOGARH

CLIENT
SBI STATE BANK OF INDIA PATNA

ARCHITECT:-
D K & ASSOCIATES
(ARCHITECTS & INTERIOR DESIGNERS)
A-385, DEFENCE COLONY, NEW DELHI - 110024
Tel: 91-11-2633331/2/3/4 Email: dkad000@gmail.com


DRAWING STAGE:-
CONCEPT DRAWING

DRAWING TITLE:-
SECOND FLOOR PLAN
(LVL. +8.1M)

SCALE	ARCH./ENGR.:-	DATE	REV.
A1 SHEET:- A2 SHEET:- A3 SHEET:-	DRAWN: ANSHU CHECKED: GAURAV	7-02-2025 APPROVED	

DRAWING NO.
DKA/SBI/TD/FF-04

NORTH

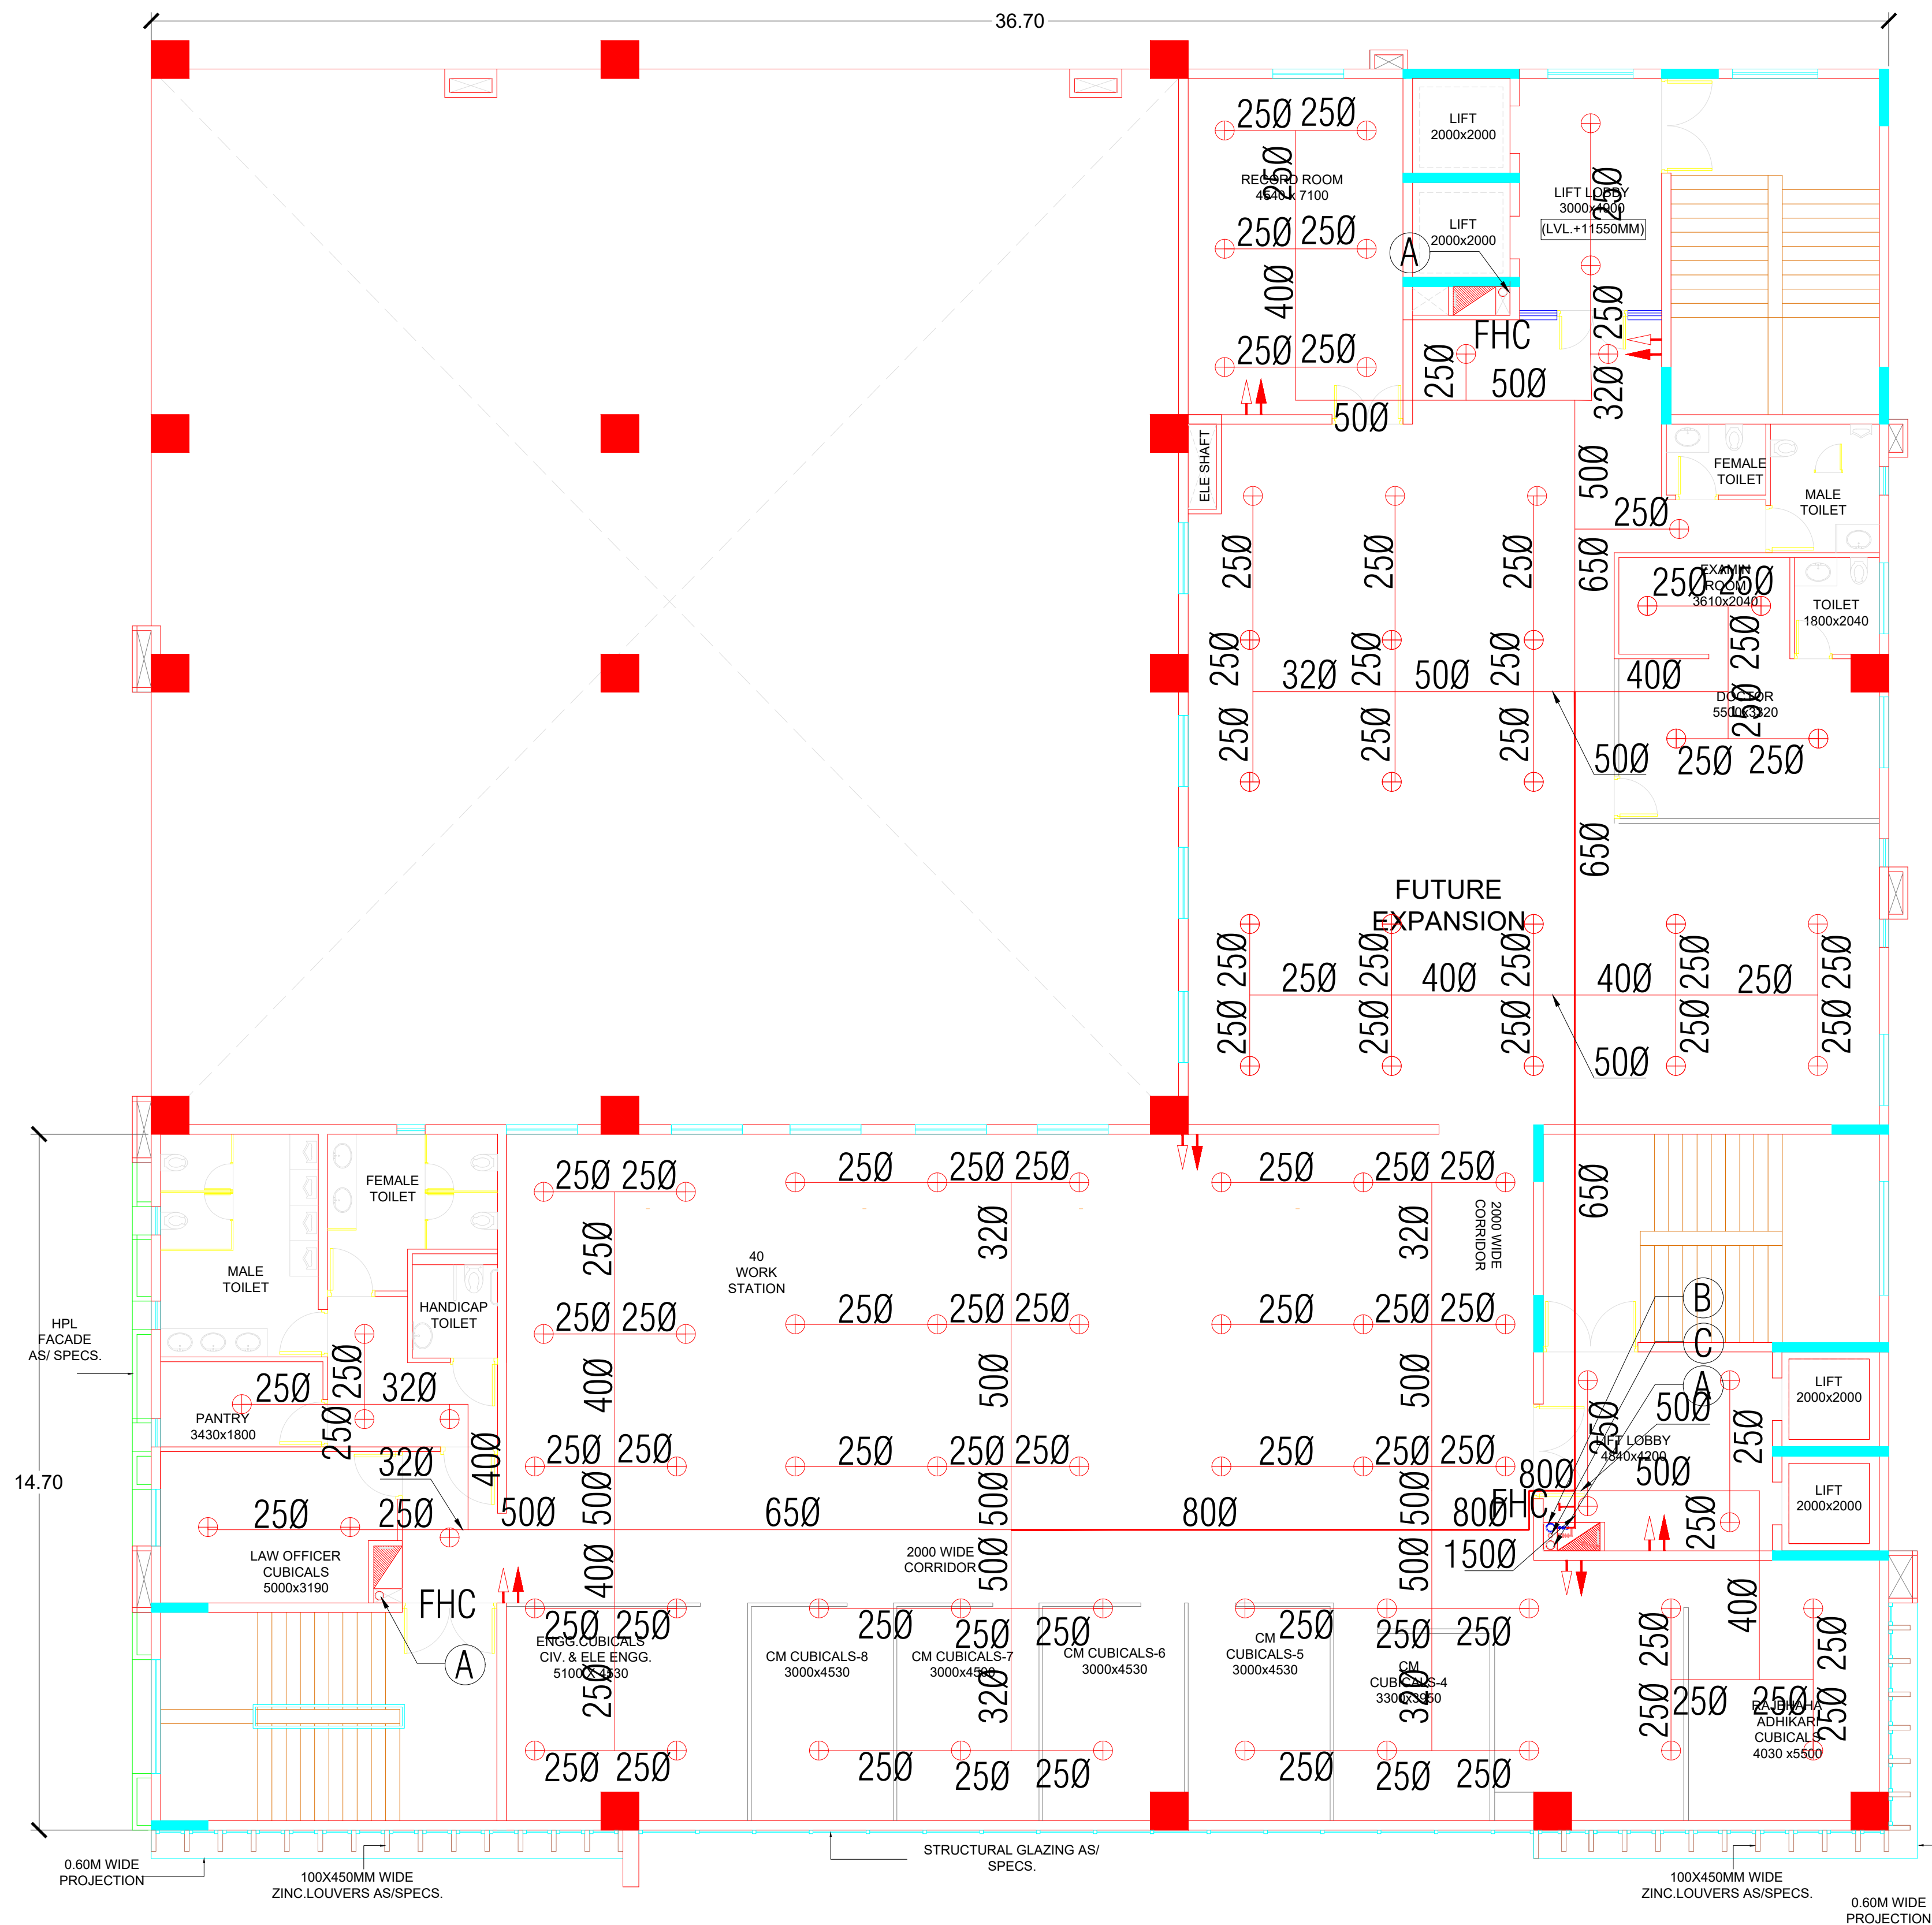

Key Plan :

Notes :

1. THIS DRAWING AND DESIGN IS THE PROPERTY OF THE DESIGNERS. NO PORTION MAY BE USED OR REPRODUCED WITHOUT THEIR WRITTEN PERMISSION.
2. THIS DRAWING IS TO BE READ IN CONJUNCTION WITH THE DESIGNERS SPECIFICATIONS AND CONDITIONS OF CONTRACT.
3. ALL DIMENSIONS ARE TO BE READ NOT SCALED.
4. ALL INDICATED LEVELS ARE FINISHED LEVELS UNLESS NOTED OTHERWISE.
5. ALL OUTER DIMENSIONS IN METER & INTERNAL DIMENSIONS IN MM.

A - 150Ø FIRE WET RISER
B - 150Ø SPRINKLER RISER
C - 80Ø SPRINKLER DRAIN PIPE
D - 80Ø FIRE DRAIN PIPE

SCHEDULE OF SPRINKLER PIPING	
NUMBER OF SPR.	DIAMETER OF PIPE
upto 2	25mm Nominal Bore
3	32mm Nominal Bore
4 to 5	40mm Nominal Bore
6 to 10	50mm Nominal Bore
11 to 20	65mm Nominal Bore
21 to 60	80mm Nominal Bore
61 to 100	100mm Nominal Bore
above 101	150mm Nominal Bore

⊕	PENDENT TYPE SPRINKLER
⊗	FLOW INDICATING SWITCH
⋈	BUTTERFLY VALVE
⋈	TESTING TUBE (SIGHT GLASS) WITH 25Ø DRAIN VALVE
⋈	FIRE HOSE CABINET 1200X600X2100mm
EFH	EXTERNAL FIRE HYDRANT
— F —	FIRE LINE
⋈	4.5 KG CO2 PORTABLE FIRE EXTINGUISHER
⋈	6 KG ABC DRY POWDER PORTABLE FIRE EXTINGUISHER

MEP - CONSULTANT	AD CONSULTANTS
	C-419, 4th Floor Vignette Plaza Sector-81 Faridabad-121002 HARYANA INDIA Email: info@adconsultants.co.in Website: www.adconsultants.co.in Ph: +91-9811-623883
Client: ATUL PANDEY	Project: MCHNA SHARMA

PROJECT TITLE
PROPOSED CONSTRUCTION OF MULTI STOREY BUILDING FOR SBI BANK AT KALYANPUR NEAR CIRCUIT HOUSE, DEOGARH

CLIENT
SBI STATE BANK OF INDIA PATNA

ARCHITECT:-
D K & ASSOCIATES
(ARCHITECTS & INTERIOR DESIGNERS)
A-385, DEFENCE COLONY, NEW DELHI - 110024.
Tel: 91-11-26333312/918 Email: dka000@gmail.com


DRAWING STAGE:-
CONCEPT DRAWING

DRAWING TITLE:-
THIRD FLOOR PLAN
(LVL. +11.55M)

SCALE	ARCH./ENG.:	DATE	REV.
A1 SHEET:- A2 SHEET:- A3 SHEET:-	DRAWN: ANSHU CHECKED: GAURAV	7-02-2025 APPROVED	

DRAWING NO.
DKA/SBI/TD/FF-05

NORTH

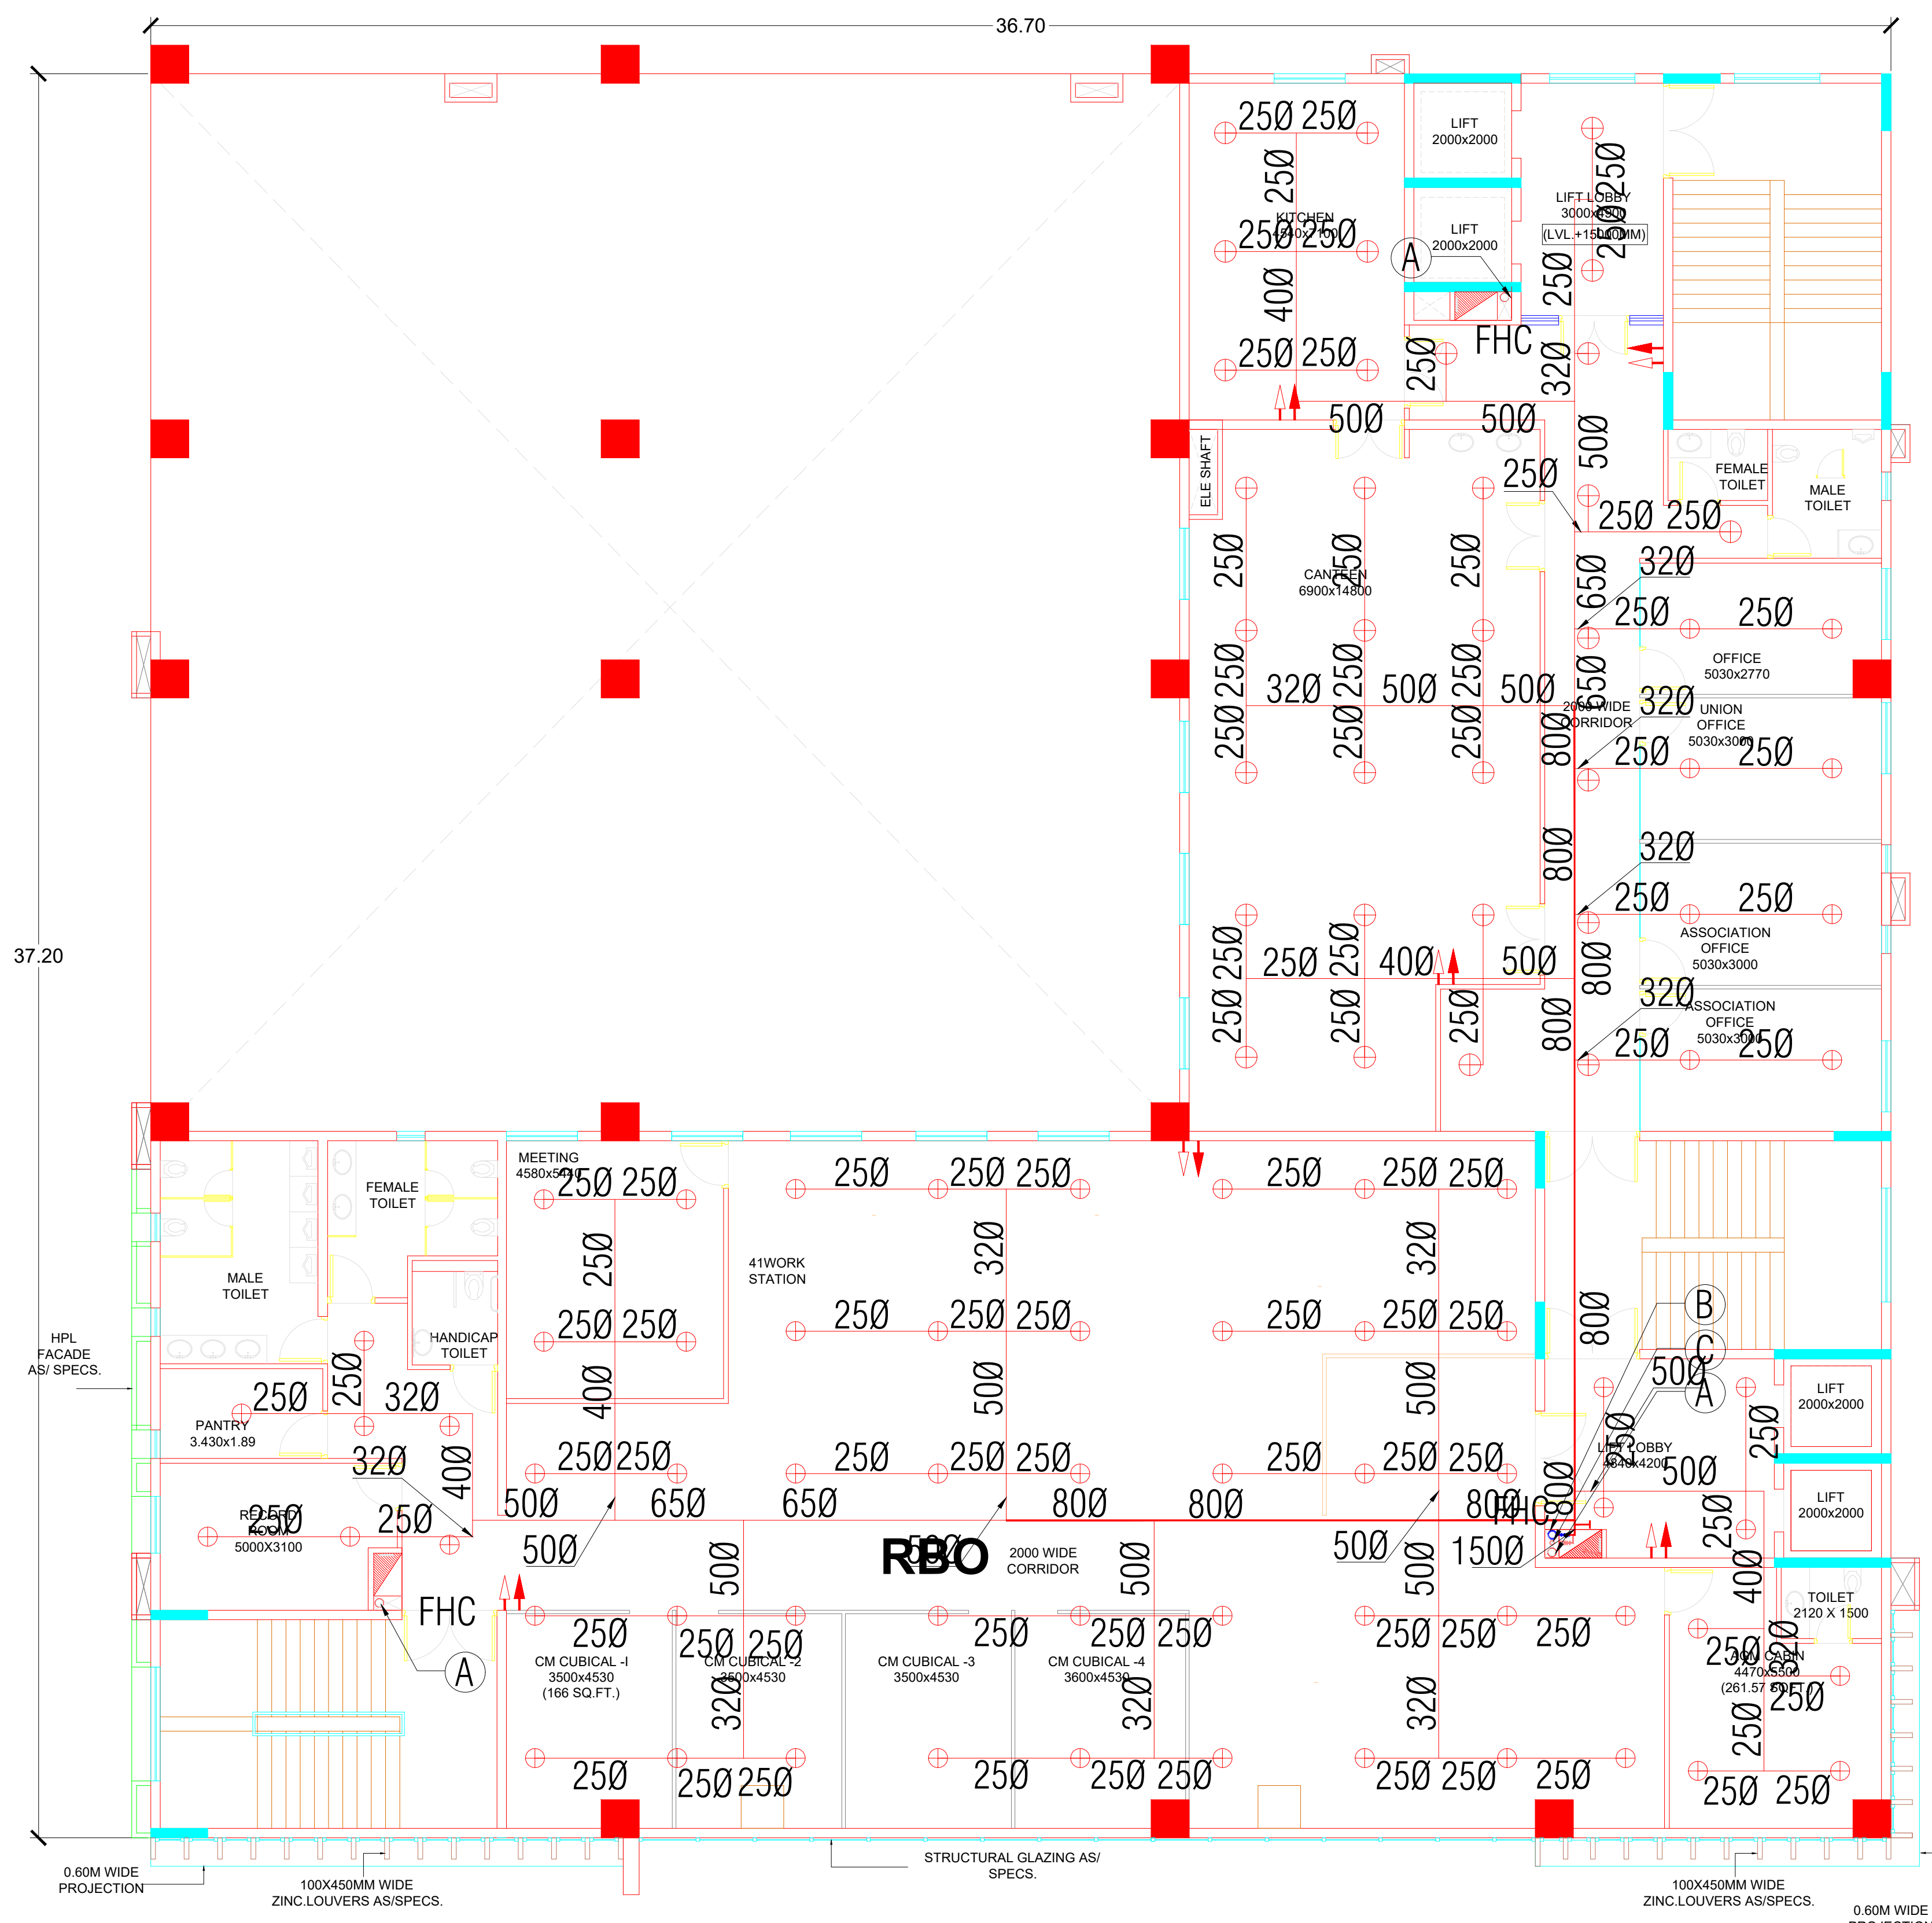

Key Plan :

Notes :
1. THIS DRAWING AND DESIGN IS THE PROPERTY OF THE DESIGNERS. NO PORTION MAY BE USED OR REPRODUCED WITHOUT THEIR WRITTEN PERMISSION.
2. THIS DRAWING IS TO BE READ IN CONJUNCTION WITH THE DESIGNERS SPECIFICATIONS AND CONDITIONS OF CONTRACT.
3. ALL DIMENSIONS ARE TO BE READ NOT SCALED.
4. ALL INDICATED LEVELS ARE FINISHED LEVELS UNLESS NOTED OTHERWISE.
5. ALL OUTER DIMENSIONS IN METER & INTERNAL DIMENSIONS IN MM.

A – 150Ø FIRE WET RISER
B – 150Ø SPRINKLER RISER
C – 80Ø SPRINKLER DRAIN PIPE
D – 80Ø FIRE DRAIN PIPE

SCHEDULE OF SPRINKLER PIPING
NUMBER OF SPR. DIAMETER OF PIPE
upto 2 25mm Nominal Bore
3 32mm Nominal Bore
4 to 5 40mm Nominal Bore
6 to 10 50mm Nominal Bore
11 to 20 65mm Nominal Bore
21 to 60 80mm Nominal Bore
61 to 100 100mm Nominal Bore
above 101 150mm Nominal Bore

⊕

PENDENT TYPE SPRINKLER

⊗

FLOW INDICATING SWITCH

⋈

BUTTERFLY VALVE

⋈

TESTING TUBE (SIGHT GLASS) WITH 25Ø DRAIN VALVE

⊕

FIRE HOSE CABINET 1200X600X2100mm

⊕

EXTERNAL FIRE HYDRANT

⊕

FIRE LINE

⊕

4.5 KG CO2 PORTABLE FIRE EXTINGUISHER

⊕

6 KG ABC DRY POWDER PORTABLE FIRE EXTINGUISHER

MEP - CONSULTANT

AD CONSULTANTS
C-419, 4th Floor Vigneti Plaza
Sector-81 Faridkot-151002
HARYANA INDIA
Email: info@adconsultants.co.in
Website: www.adconsultants.co.in
Ph: +91-9811-923883

Drawn: ATUL PANEY

Checked: MOHNA SHARMA

PROJECT TITLE
PROPOSED CONSTRUCTION OF MULTI STOREY BUILDING FOR SBI BANK AT KALYANPUR NEAR CIRCUIT HOUSE,DEOGARH

CLIENT
 STATE BANK OF INDIA PATNA

ARCHITECT:-
 D K & ASSOCIATES
(ARCHITECTS & INTERIOR DESIGNERS)
A-385, DEFENCE COLONY, NEW DELHI - 110024.
Tel: 91-11-26333312/918 E-mail: dko2000@gmail.com

DRAWING STAGE:-
CONCEPT DRAWING

DRAWING TITLE:-
FOURTH FLOOR PLAN
(LVL. +15.0M)


SCALE
A1 SHEET:-
A2 SHEET:-
A3 SHEET:-

ARCH./ENGR.:
DRAWN: ANSHU
CHECKED: GAURAV

DATE
7-02-2025
APPROVED

REV.

DRAWING NO.
DKA/SBI/TD/FF-06

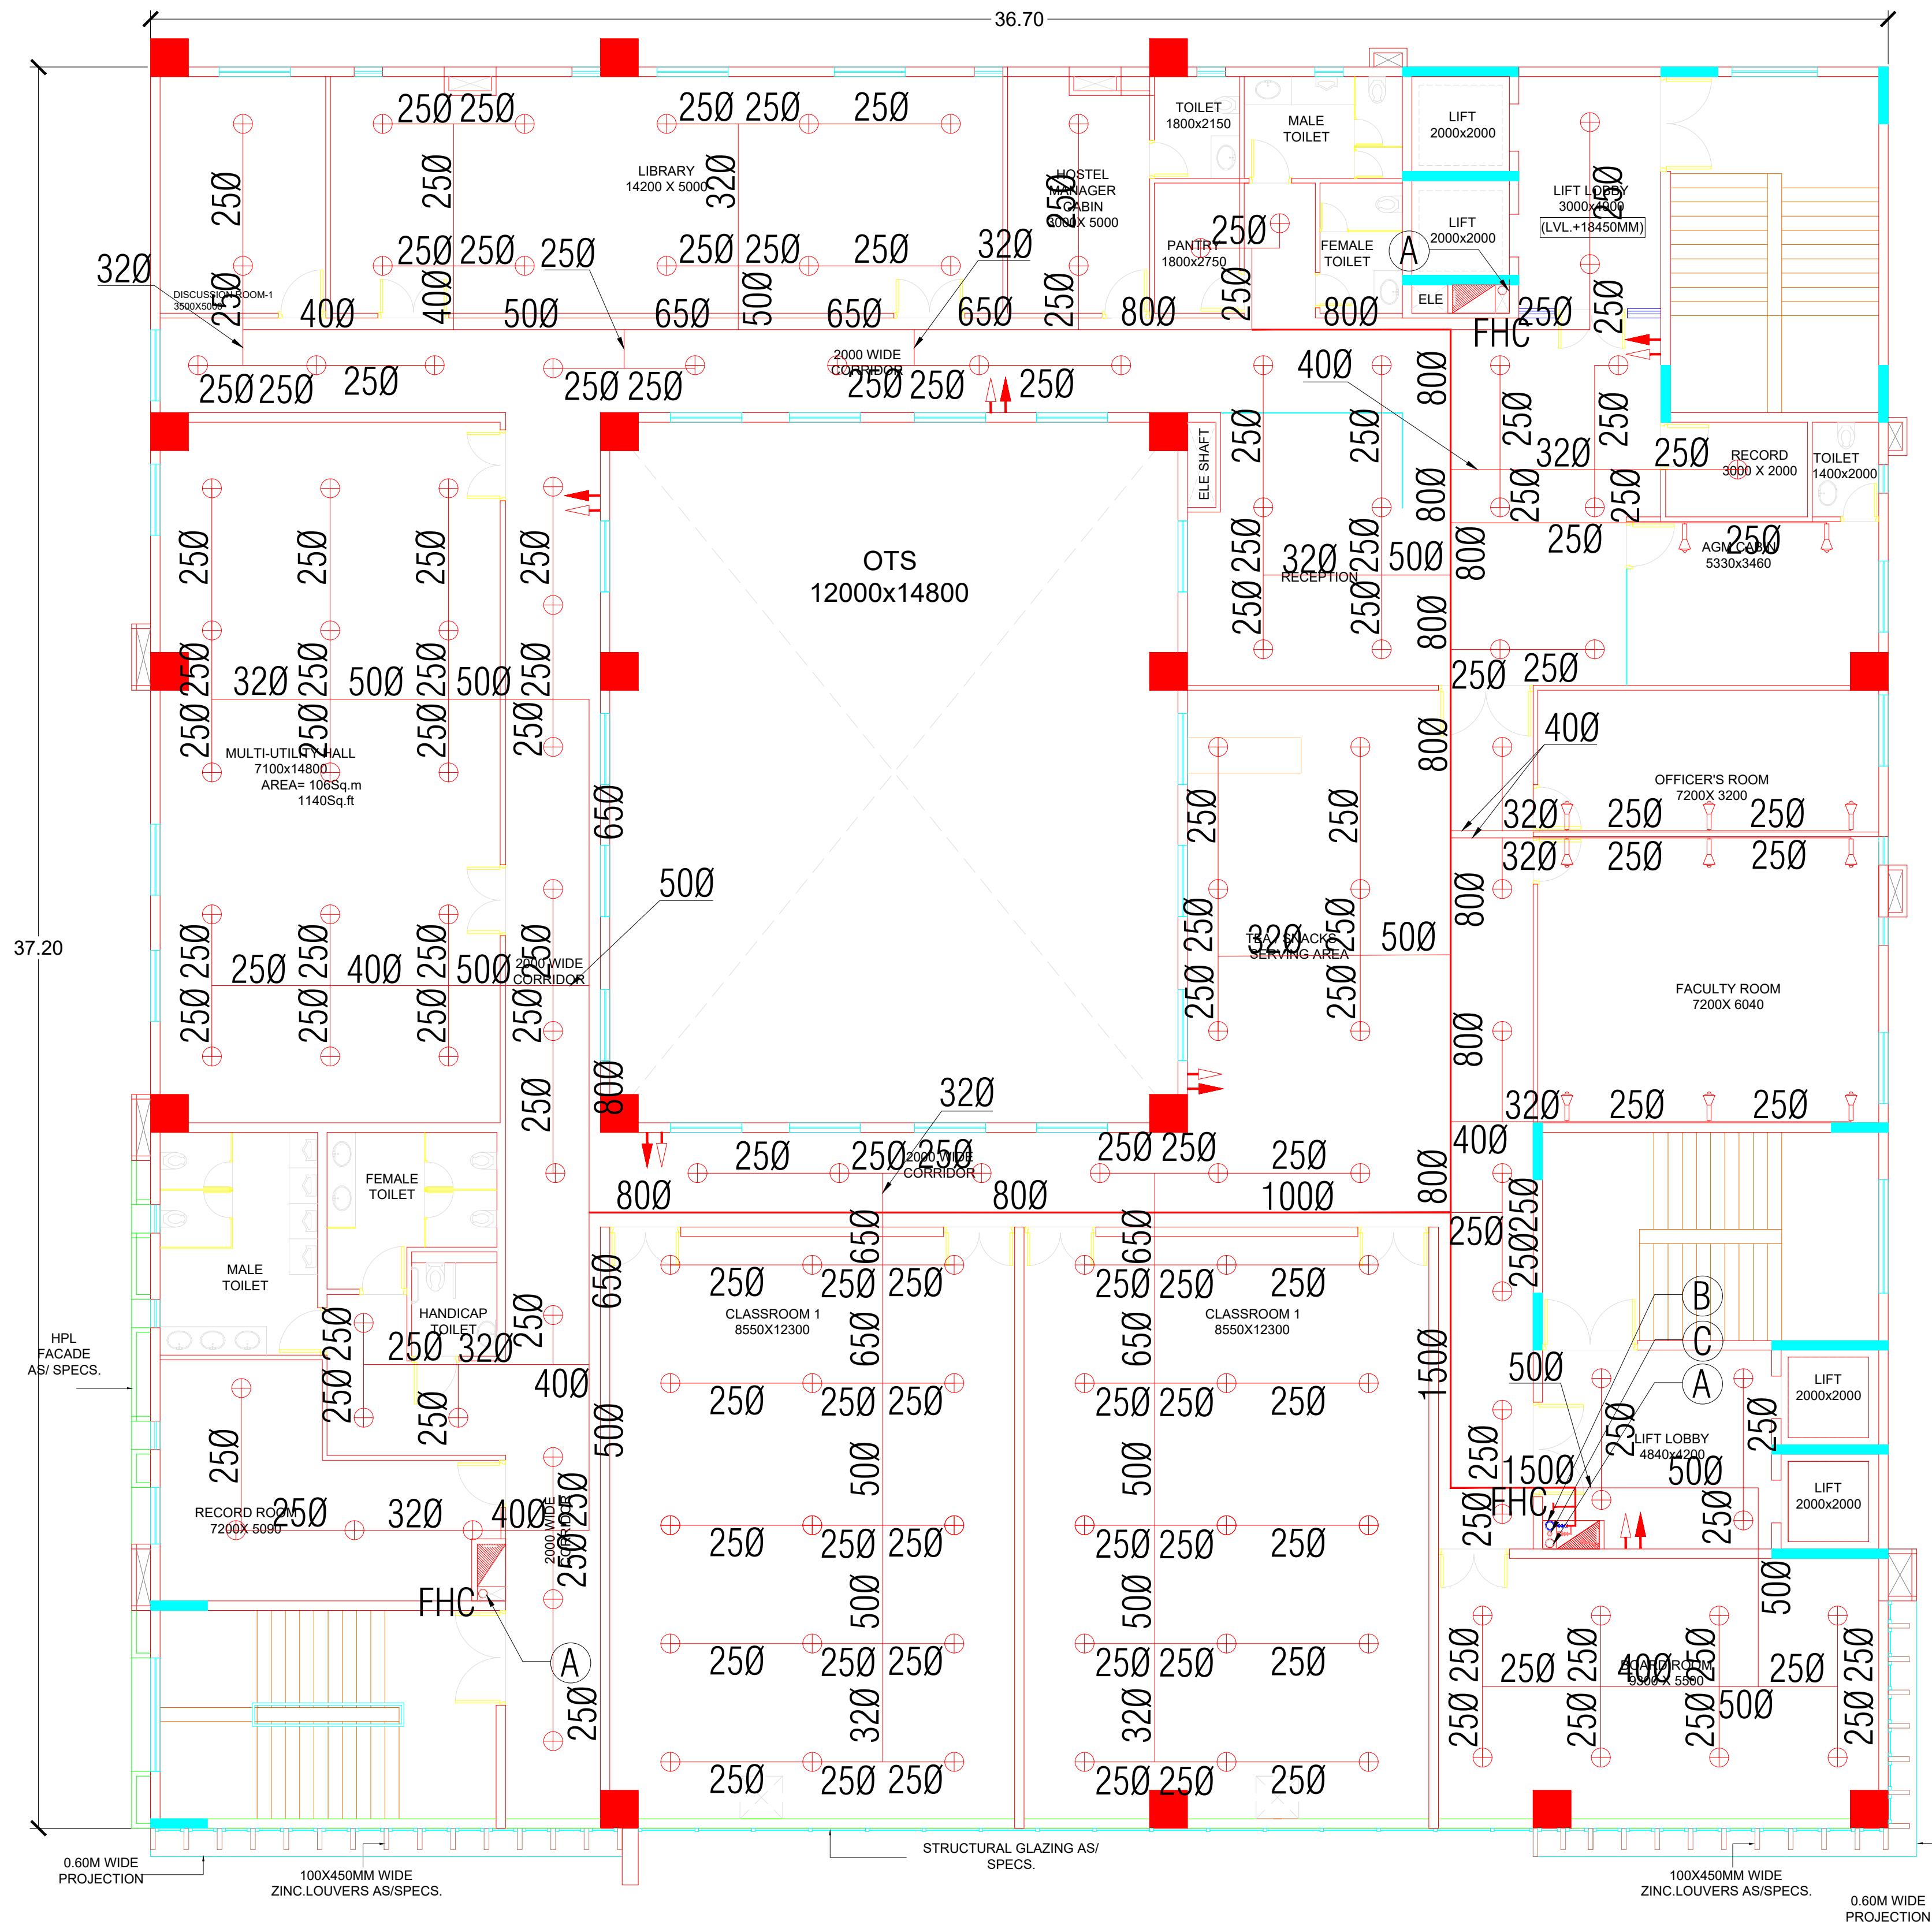

Key Plan :

Notes :

1. THIS DRAWING AND DESIGN IS THE PROPERTY OF THE DESIGNERS. NO PORTION MAY BE USED OR REPRODUCED WITHOUT THEIR WRITTEN PERMISSION.
2. THIS DRAWING IS TO BE READ IN CONJUNCTION WITH THE DESIGNERS SPECIFICATIONS AND CONDITIONS OF CONTRACT.
3. ALL DIMENSIONS ARE TO BE READ NOT SCALED.
4. ALL INDICATED LEVELS ARE FINISHED LEVELS UNLESS NOTED OTHERWISE.
5. ALL OUTER DIMENSIONS IN METER & INTERNAL DIMENSIONS IN MM.

- A - 150Ø FIRE WET RISER
B - 150Ø SPRINKLER RISER
C - 80Ø SPRINKLER DRAIN PIPE
D - 80Ø FIRE DRAIN PIPE

SCHEDULE OF SPRINKLER PIPING	
NUMBER OF SPR.	DIAMETER OF PIPE
upto 2	25mm Nominal Bore
3	32mm Nominal Bore
4 to 5	40mm Nominal Bore
6 to 10	50mm Nominal Bore
11 to 20	65mm Nominal Bore
21 to 60	80mm Nominal Bore
61 to 100	100mm Nominal Bore
above 101	150mm Nominal Bore

	PENDENT TYPE SPRINKLER
	FLOW INDICATING SWITCH
	BUTTERFLY VALVE
	TESTING TUBE (SIGHT GLASS) WITH 25Ø DRAIN VALVE
	FIRE HOSE CABINET 1200X600X2100mm
	EXTERNAL FIRE HYDRANT
	FIRE LINE
	4.5 KG CO2 PORTABLE FIRE EXTINGUISHER
	6 KG ABC DRY POWDER PORTABLE FIRE EXTINGUISHER

MEP - CONSULTANT	AD CONSULTANTS
	C-419, 4th Floor Vigneti Plaza Sector-41 Faridkot-171002 HARYANA INDIA Email: info@adconsultants.co.in Website: www.adconsultants.co.in Ph: +91-9811-623885
Client: ATUL PANDEY	Project: SBI BANK PATNA

PROJECT TITLE
PROPOSED CONSTRUCTION OF MULTI STOREY BUILDING FOR SBI BANK AT KALYANPUR NEAR CIRCUIT HOUSE,DEOGARH

CLIENT :-
CLIENT :-

SBI STATE BANK OF INDIA PATNA

ARCHITECT:-
D K & ASSOCIATES
(ARCHITECTS & INTERIOR DESIGNERS)
A-385, DEFENCE COLONY, NEW DELHI - 110024.
Tel: 91-11-26333312/918 Email: dkco200@gmail.com


DRAWING STAGE:-
CONCEPT DRAWING

DRAWING TITLE:-
FIFTH FLOOR PLAN
(LVL.+18.45M)

SCALE	ARCH./ENGR.:	DATE	REV.
A1 SHEET:- A2 SHEET:- A3 SHEET:-	DRAWN: ANSHU CHECKED: GAURAV	7-02-2025 APPROVED	

DRAWING NO.
DKA/SBI/TD/FF-07

NORTH

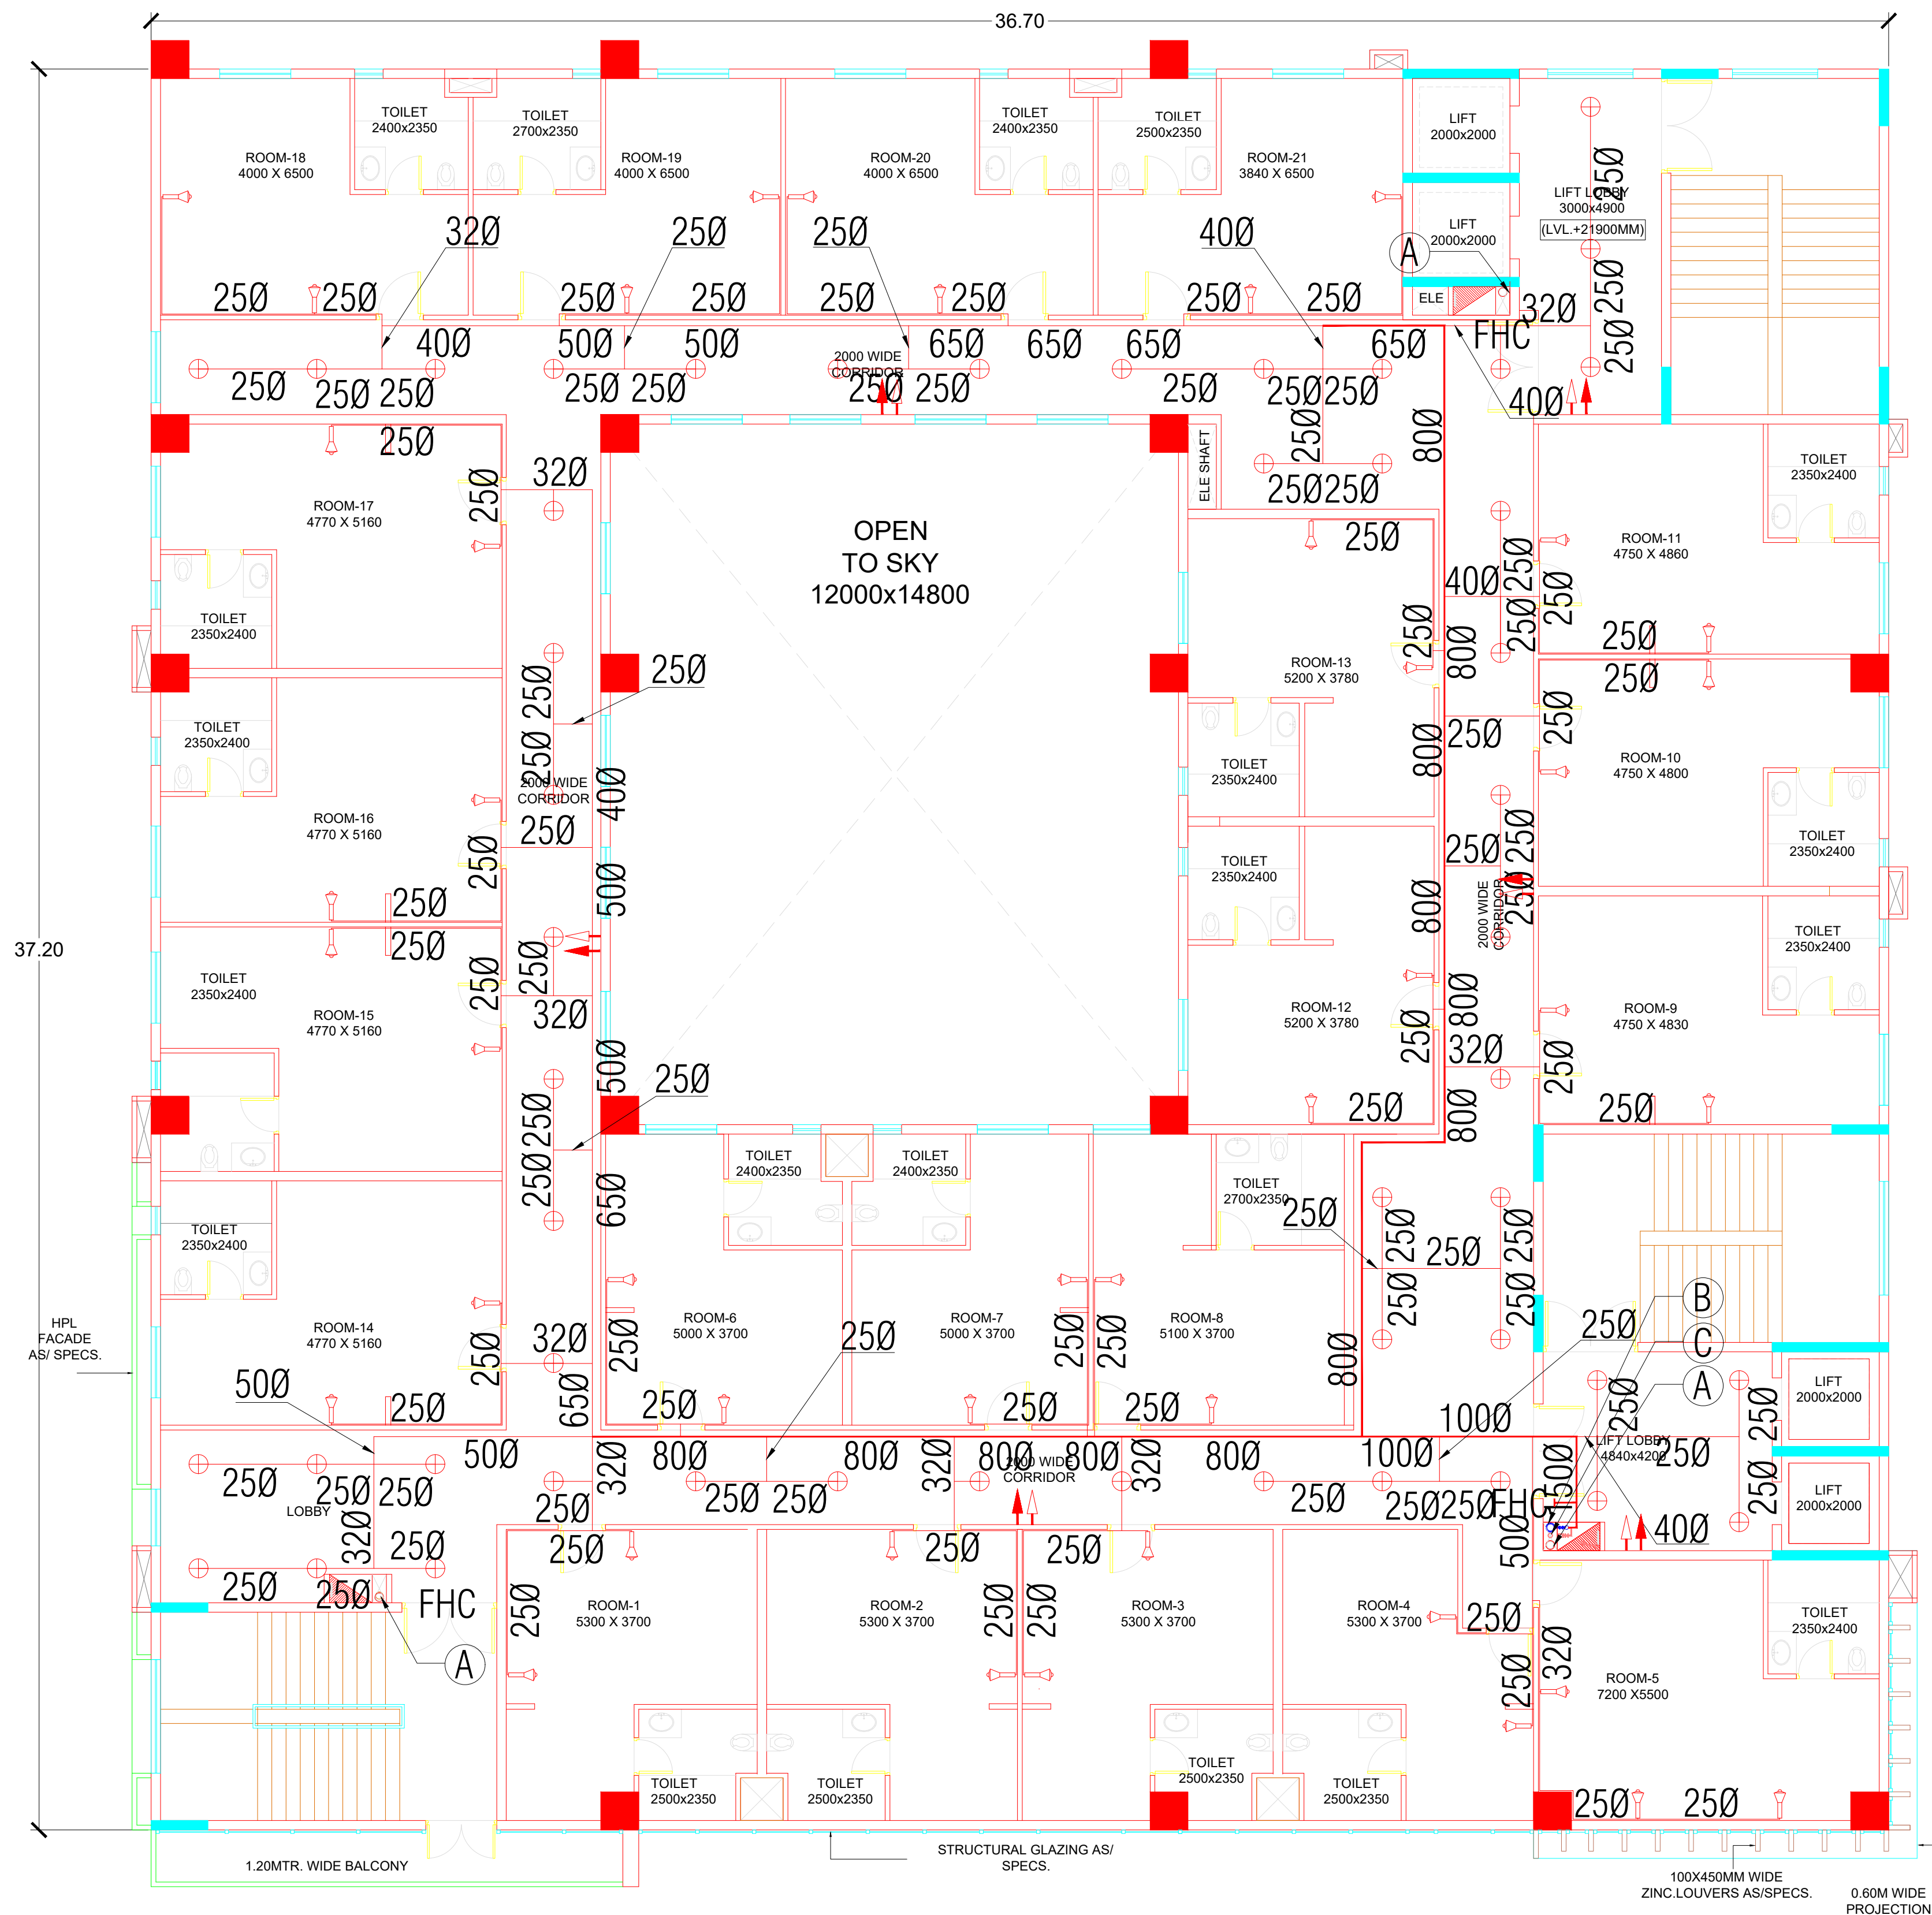

Key Plan :

Notes :

1. THIS DRAWING AND DESIGN IS THE PROPERTY OF THE DESIGNERS. NO PORTION MAY BE USED OR REPRODUCED WITHOUT THEIR WRITTEN PERMISSION.
2. THIS DRAWING IS TO BE READ IN CONJUNCTION WITH THE DESIGNERS SPECIFICATIONS AND CONDITIONS OF CONTRACT.
3. ALL DIMENSIONS ARE TO BE READ NOT SCALED.
4. ALL INDICATED LEVELS ARE FINISHED LEVELS UNLESS NOTED OTHERWISE.
5. ALL OUTER DIMENSIONS IN METER & INTERNAL DIMENSIONS IN MM.

A - 150Ø FIRE WET RISER
B - 150Ø SPRINKLER RISER
C - 80Ø SPRINKLER DRAIN PIPE
D - 80Ø FIRE DRAIN PIPE

SCHEDULE OF SPRINKLER PIPING	
NUMBER OF SPR.	DIAMETER OF PIPE
upto 2	25mm Nominal Bore
3	32mm Nominal Bore
4 to 5	40mm Nominal Bore
6 to 10	50mm Nominal Bore
11 to 20	65mm Nominal Bore
21 to 60	80mm Nominal Bore
61 to 100	100mm Nominal Bore
above 101	150mm Nominal Bore

⊕	PENDENT TYPE SPRINKLER
⊗	FLOW INDICATING SWITCH
+	BUTTERFLY VALVE
+	TESTING TUBE (SIGHT GLASS) WITH 25Ø DRAIN VALVE
+	FIRE HOSE CABINET 1200X600X2100mm
+	EXTERNAL FIRE HYDRANT
+	FIRE LINE
+	4.5 KG CO2 PORTABLE FIRE EXTINGUISHER
+	6 KG ABC DRY POWDER PORTABLE FIRE EXTINGUISHER

MEP - CONSULTANT	AD CONSULTANTS
	C-419, 4th Floor Vigneti Plaza Sector-81 Faridkot-171002 HARYANA INDIA Email: info@adconsultants.co.in Website: www.adconsultants.co.in Ph: +91-9811-683883
Drawn: ATUL PANEY	Reviewed: MOHNA SHARMA

PROJECT TITLE
PROPOSED CONSTRUCTION OF MULTI STOREY BUILDING FOR SBI BANK AT KALYANPUR NEAR CIRCUIT HOUSE, DEOGARH
CLIENT :-

SBI STATE BANK OF INDIA PATNA

ARCHITECT:-
D K & ASSOCIATES
(ARCHITECTS & INTERIOR DESIGNERS)
A-385, DEFENCE COLONY, NEW DELHI - 110024.
Tel: 91-11-26533312/918 E-mail: dkao2000@gmail.com


DRAWING STAGE:-
CONCEPT DRAWING

DRAWING TITLE:-
SIXTH FLOOR PLAN
(LVL. +21.9M)

SCALE	ARCH./ENGR.:	DATE	REV.
A1 SHEET:- A2 SHEET:- A3 SHEET:-	DRAWN: ANSHU CHECKED: GAURAV	7-02-2025 APPROVED	

DRAWING NO.
DKA/SBI/TD/FF-08

NORTH

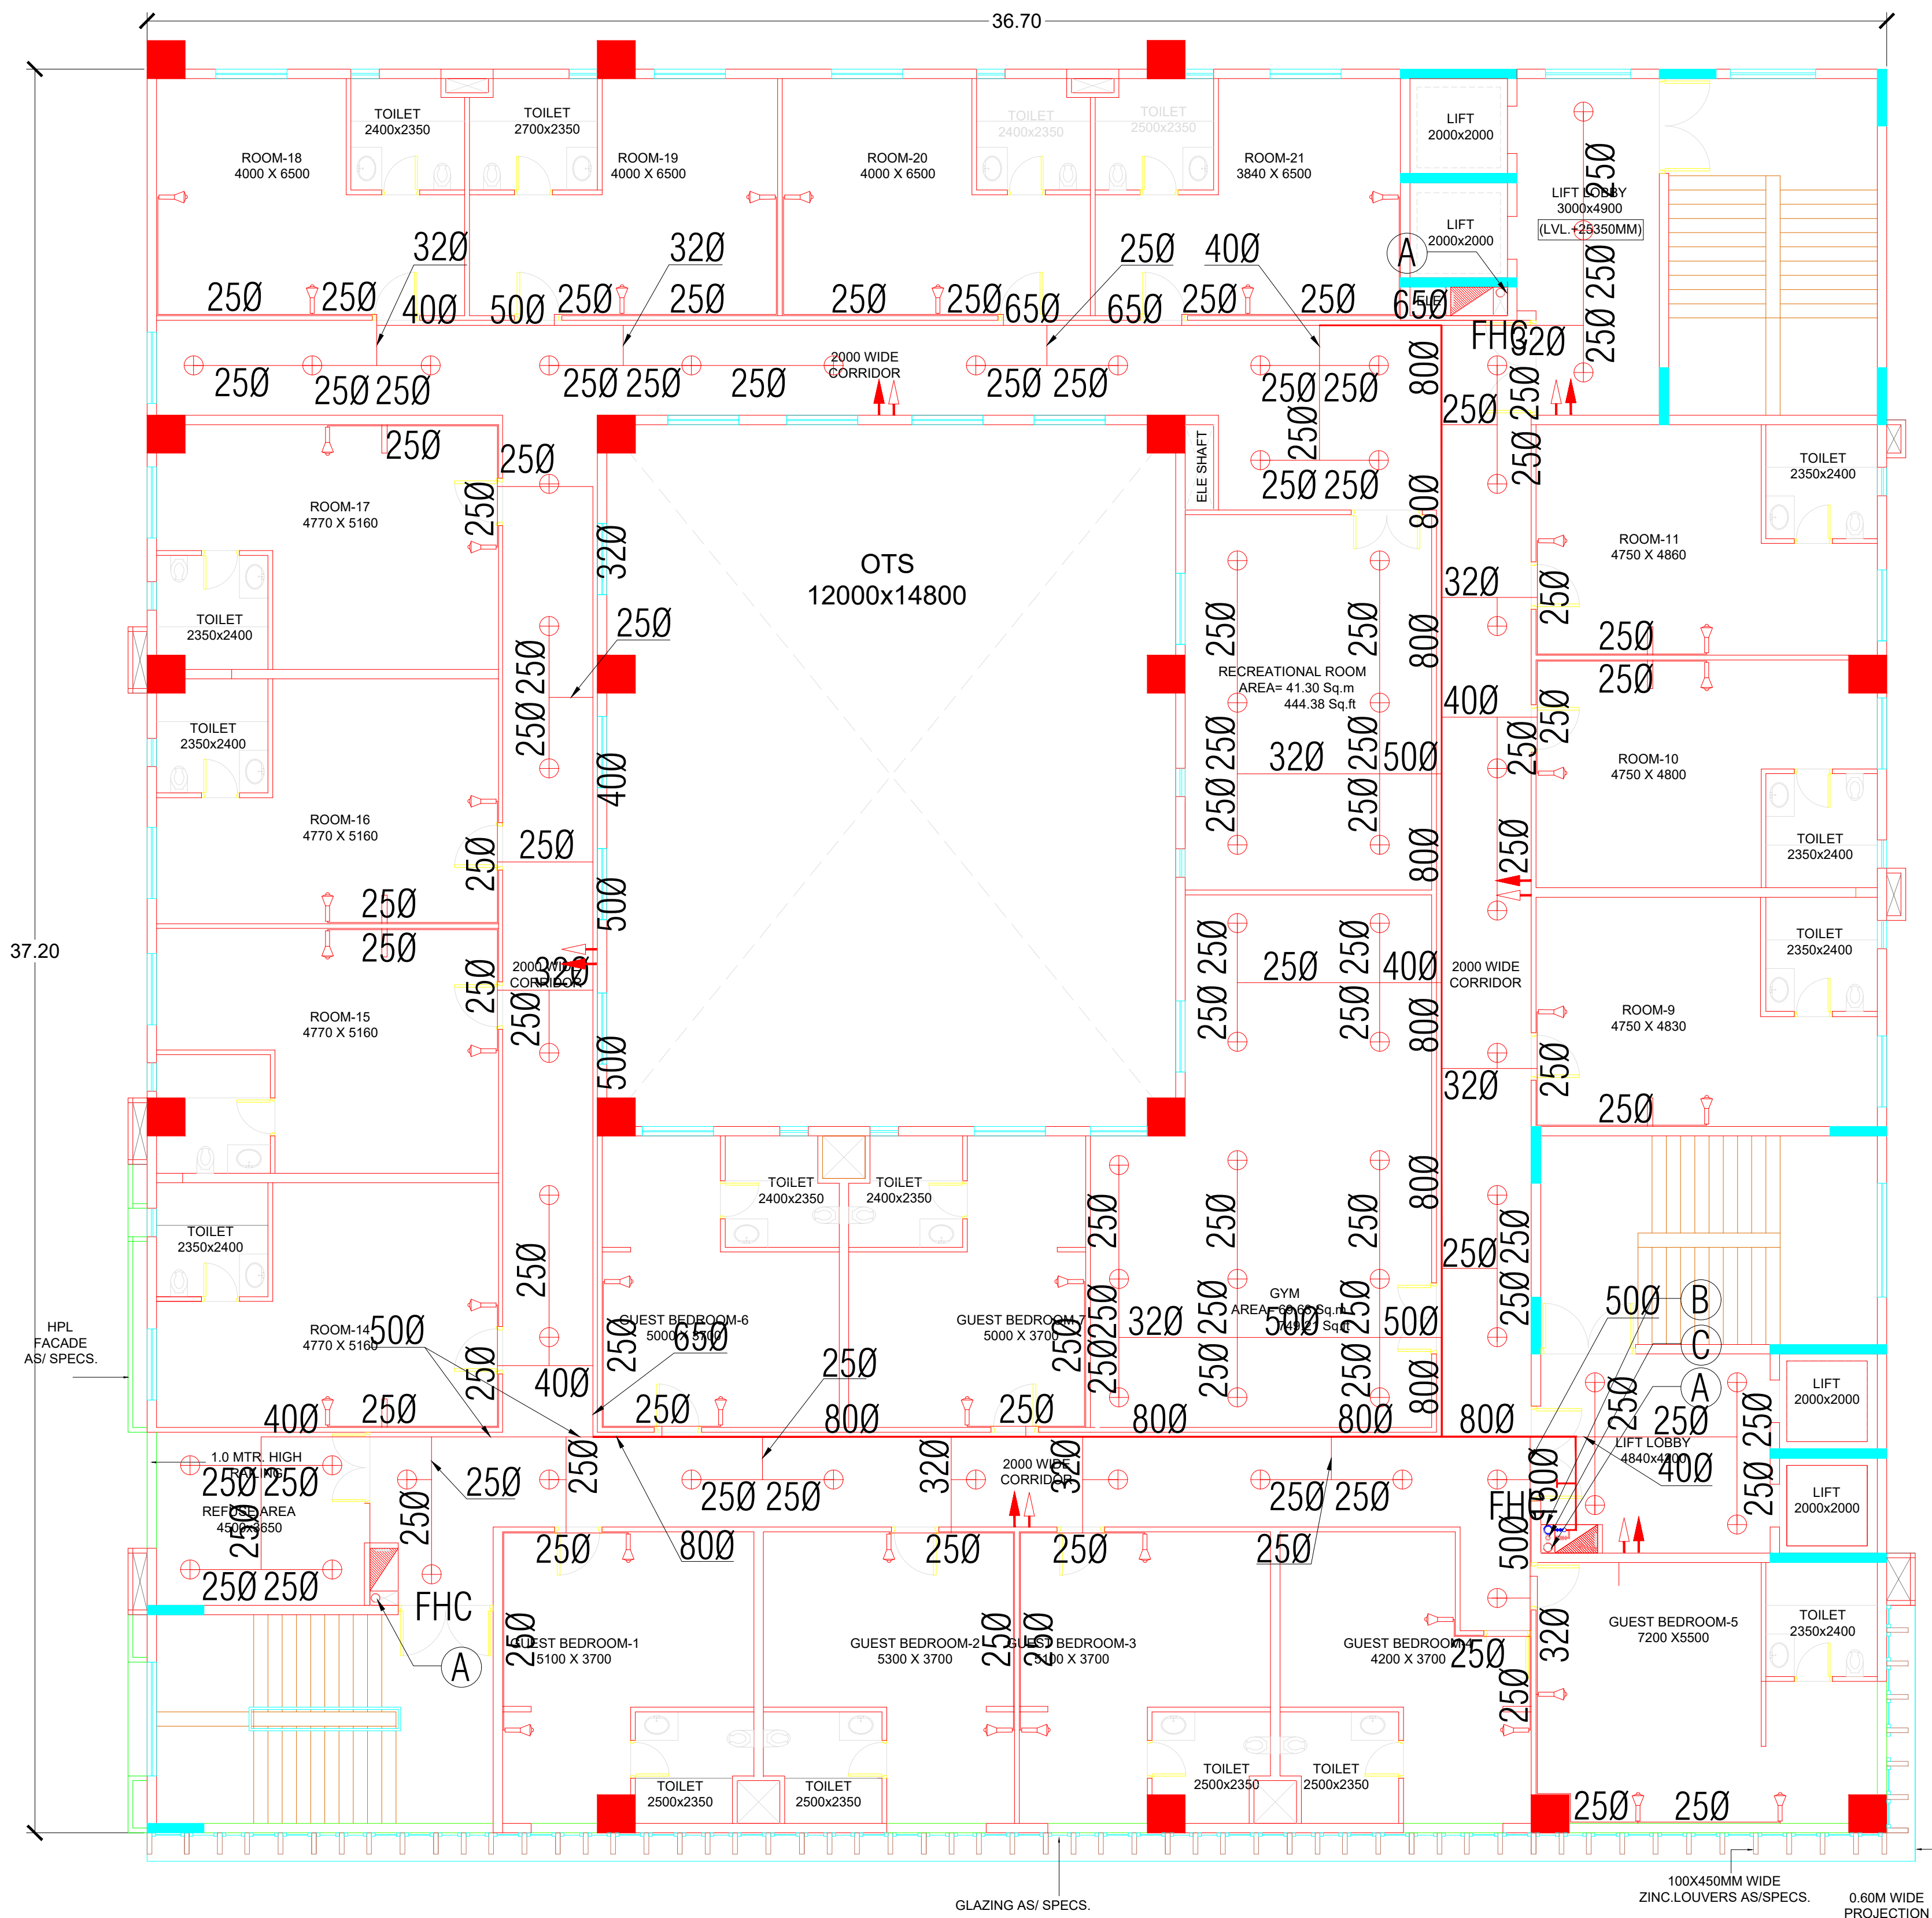

Key Plan :

Notes :

1. THIS DRAWING AND DESIGN IS THE PROPERTY OF THE DESIGNERS. NO PORTION MAY BE USED OR REPRODUCED WITHOUT THEIR WRITTEN PERMISSION.
2. THIS DRAWING IS TO BE READ IN CONJUNCTION WITH THE DESIGNERS SPECIFICATIONS AND CONDITIONS OF CONTRACT.
3. ALL DIMENSIONS ARE TO BE READ NOT SCALED.
4. ALL INDICATED LEVELS ARE FINISHED LEVELS UNLESS NOTED OTHERWISE.
5. ALL OUTER DIMENSIONS IN METER & INTERNAL DIMENSIONS IN MM.

- A - 150Ø FIRE WET RISER
B - 150Ø SPRINKLER RISER
C - 80Ø SPRINKLER DRAIN PIPE
D - 80Ø FIRE DRAIN PIPE

SCHEDULE OF SPRINKLER PIPING	
NUMBER OF SPR.	DIAMETER OF PIPE
upto 2	25mm Nominal Bore
3	32mm Nominal Bore
4 to 5	40mm Nominal Bore
6 to 10	50mm Nominal Bore
11 to 20	65mm Nominal Bore
21 to 60	80mm Nominal Bore
61 to 100	100mm Nominal Bore
above 101	150mm Nominal Bore

⊕	PENDENT TYPE SPRINKLER
⊗	FLOW INDICATING SWITCH
+	BUTTERFLY VALVE
+	TESTING TUBE (SIGHT GLASS) WITH 25Ø DRAIN VALVE
+	FIRE HOSE CABINET 1200X600X2100mm
+	EXTERNAL FIRE HYDRANT
+	FIRE LINE
+	4.5 KG CO2 PORTABLE FIRE EXTINGUISHER
+	6 KG ABC DRY POWDER PORTABLE FIRE EXTINGUISHER

MEP - CONSULTANT	AD CONSULTANTS
	C-419, 4th Floor, Vignesh Plaza, Sector-81, Faridkot-141002, HARIDWARA INDIA. Email: info@adconsultants.co.in, Website: www.adconsultants.co.in, Ph: +91-9811-621885
Client: ATUL PAREKH	Project: MCHN SHARMA

PROJECT TITLE
PROPOSED CONSTRUCTION OF MULTI STOREY BUILDING FOR SBI BANK AT KALYANPUR NEAR CIRCUIT HOUSE, DEOGARH

CLIENT :-
 STATE BANK OF INDIA PATNA

ARCHITECT:-
 D K & ASSOCIATES
(ARCHITECTS & INTERIOR DESIGNERS)
A-385, DEFENCE COLONY, NEW DELHI - 110024.
Tel: 91-11-26333312/918 Email: dpo2000@gmail.com


DRAWING STAGE:-
CONCEPT DRAWING

DRAWING TITLE:-
SEVENTH FLOOR PLAN
(LVL. +25.35M)

SCALE A1 SHEET:- A2 SHEET:- A3 SHEET:-	ARCH./ENGR.: DRAWN: CHECKED: GAURAV	DATE 7-02-2025 APPROVED	REV.
---	--	-------------------------------	------

DRAWING NO.
DKA/SBI/TD/FF-09

NORTH

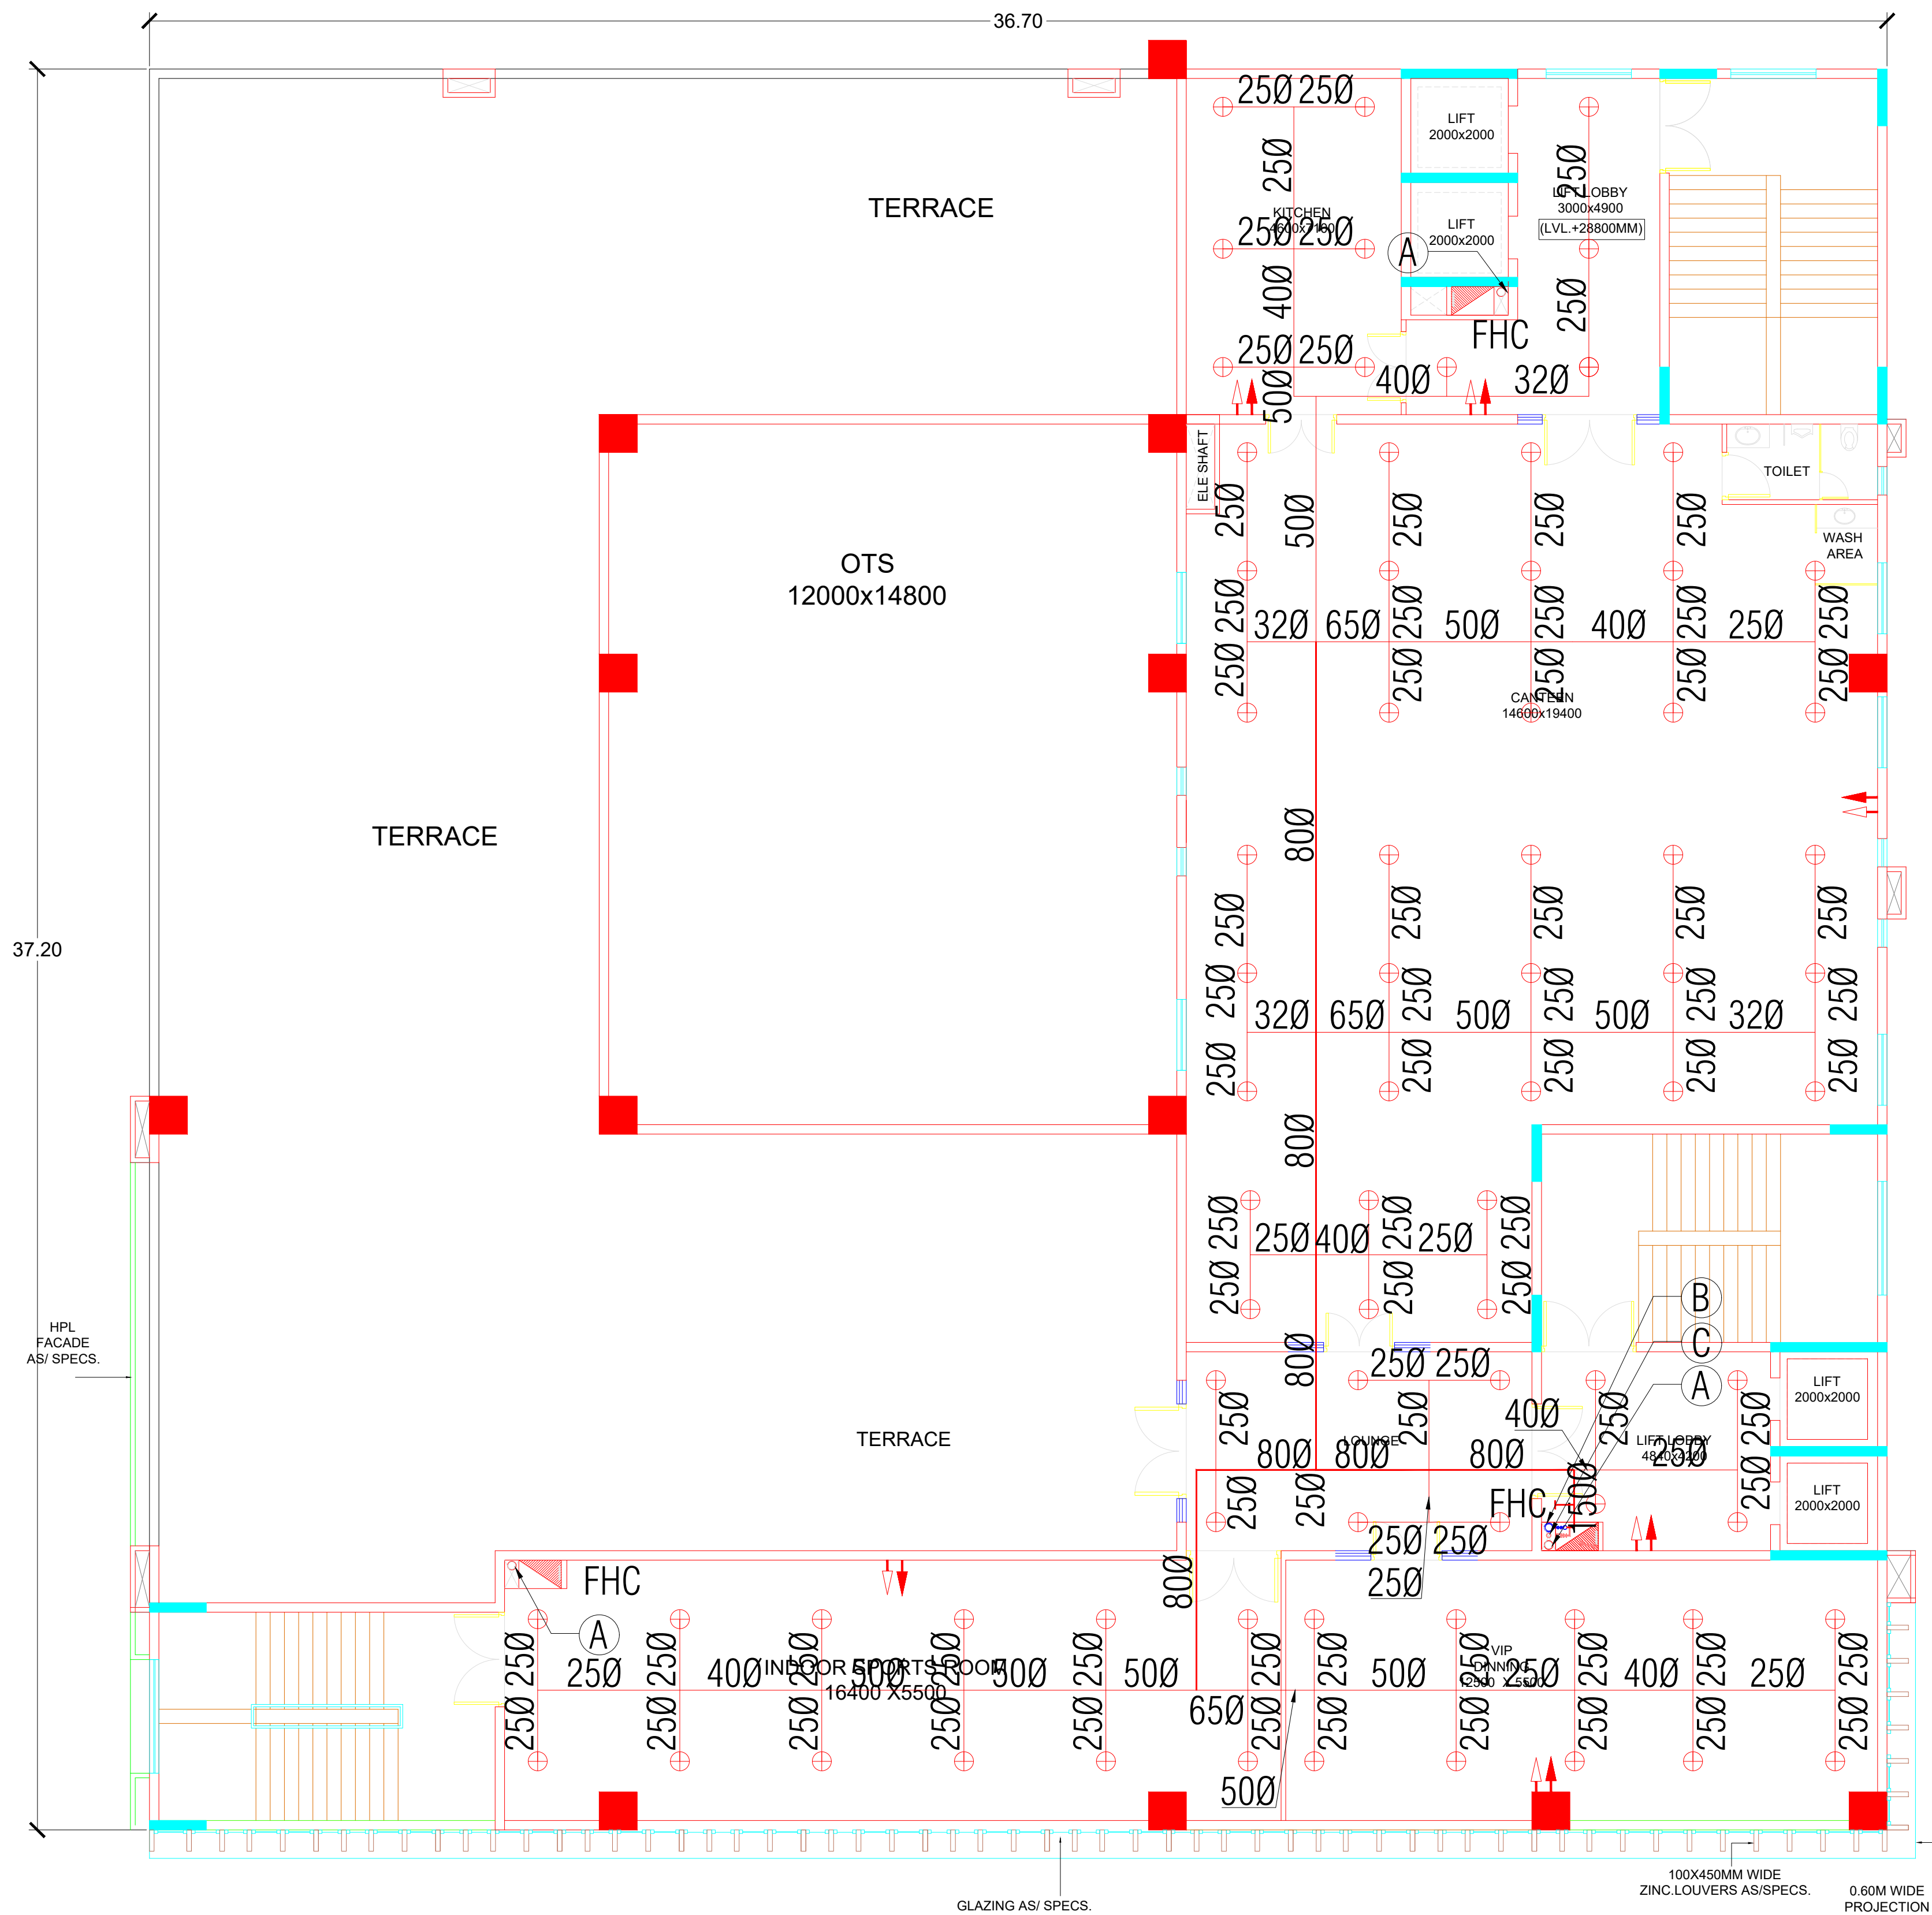

Key Plan :

Notes :

1. THIS DRAWING AND DESIGN IS THE PROPERTY OF THE DESIGNERS. NO PORTION MAY BE USED OR REPRODUCED WITHOUT THEIR WRITTEN PERMISSION.
2. THIS DRAWING IS TO BE READ IN CONJUNCTION WITH THE DESIGNERS SPECIFICATIONS AND CONDITIONS OF CONTRACT.
3. ALL DIMENSIONS ARE TO BE READ NOT SCALED.
4. ALL INDICATED LEVELS ARE FINISHED LEVELS UNLESS NOTED OTHERWISE.
5. ALL OUTER DIMENSIONS IN METER & INTERNAL DIMENSIONS IN MM.

A - 150Ø FIRE WET RISER
B - 150Ø SPRINKLER RISER
C - 80Ø SPRINKLER DRAIN PIPE
D - 80Ø FIRE DRAIN PIPE

SCHEDULE OF SPRINKLER PIPING	
NUMBER OF SPR.	DIAMETER OF PIPE
upto 2	25mm Nominal Bore
3	32mm Nominal Bore
4 to 5	40mm Nominal Bore
6 to 10	50mm Nominal Bore
11 to 20	65mm Nominal Bore
21 to 60	80mm Nominal Bore
61 to 100	100mm Nominal Bore
above 101	150mm Nominal Bore

⊕	PENDENT TYPE SPRINKLER
⊗	FLOW INDICATING SWITCH
+	BUTTERFLY VALVE
⊗	TESTING TUBE (SIGHT GLASS) WITH 25Ø DRAIN VALVE
⊗	FIRE HOSE CABINET 1200X600X2100mm
EFH	EXTERNAL FIRE HYDRANT
F	FIRE LINE
⊗	4.5 KG CO2 PORTABLE FIRE EXTINGUISHER
⊗	6 KG ABC DRY POWDER PORTABLE FIRE EXTINGUISHER

MEP - CONSULTANT	AD CONSULTANTS
	C-419, 4th Floor Vipul Plaza Sector-41 Faridkot-171002 HARYANA INDIA Email: info@adconsultants.co.in Website: www.adconsultants.co.in Ph: +91-9811-623885
Client: ATUL PANDEY	Project: SBI BANK PATNA

PROJECT TITLE
PROPOSED CONSTRUCTION OF MULTI STOREY BUILDING FOR SBI BANK AT KALYANPUR NEAR CIRCUIT HOUSE, DEOGARH

CLIENT :-
 STATE BANK OF INDIA PATNA

ARCHITECT:-
 D K & ASSOCIATES
(ARCHITECTS & INTERIOR DESIGNERS)
A-385, DEFENCE COLONY, NEW DELHI - 110024
Tel: 91-11-26333312/918 E-mail: dpo2000@gmail.com

DRAWING STAGE:-
CONCEPT DRAWING

DRAWING TITLE:-
EIGHTH FLOOR PLAN
(LVL. +28.8M)

SCALE	ARCH./ENGR.:	DATE	REV.
A1 SHEET:- A2 SHEET:- A3 SHEET:-	DRAWN: ANSHU CHECKED: GAURAV	7-02-2025 APPROVED	

DRAWING NO.
DKA/SBI/TD/FF-10

NORTH



NORTH 

