


LAYOUT PLAN

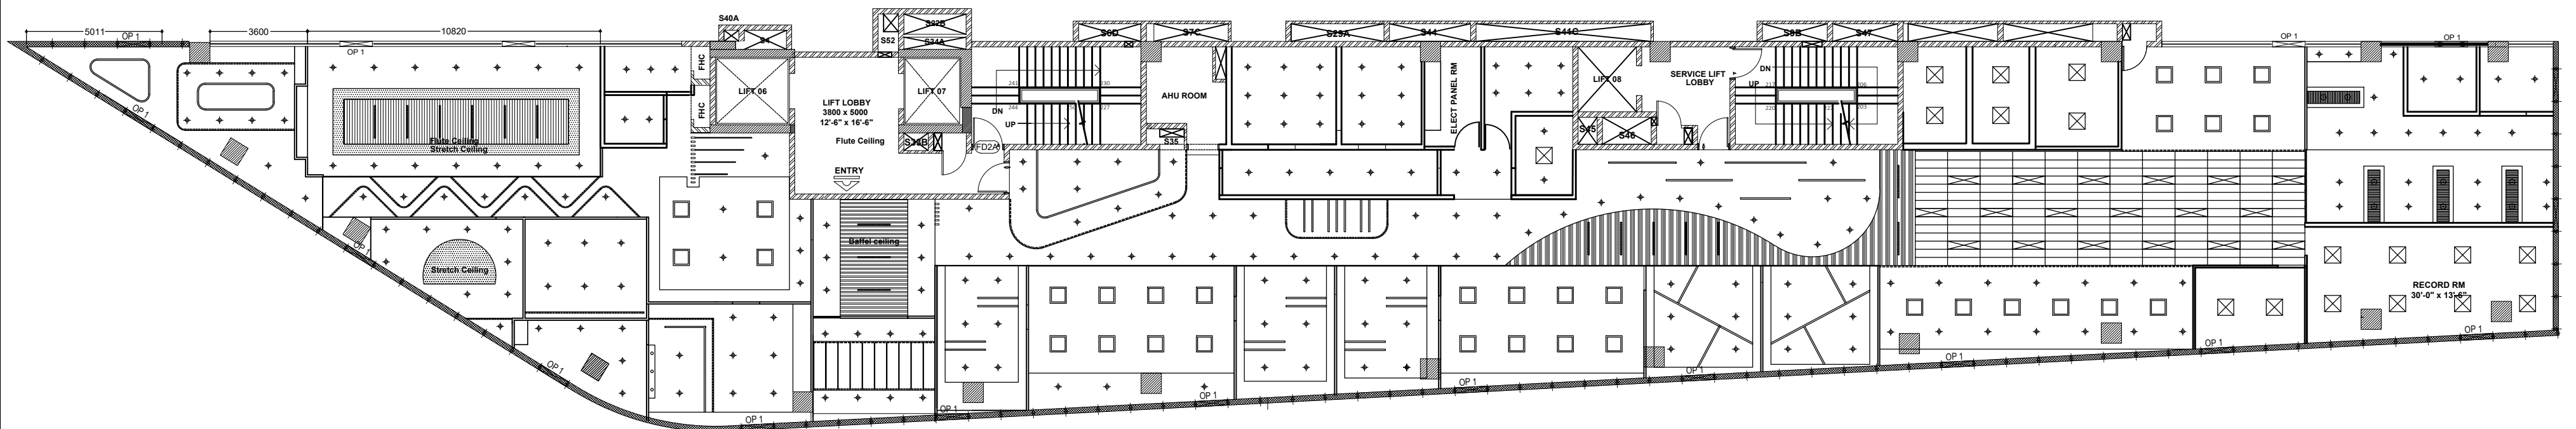

REFLECTED CEILING PLAN

S.NO.	SYMBOL	LEGEND NAME
1.		FULL GLOW 600x600 LED 36 W SLIM SMART PANEL
2.		FULL GLOW 600x600 LED SQUARE PENDENT LIGHT
3.		FULL GLOW 300x1200 LED SLIM SMART PANEL
4.		15/18 W LED COMMERCIAL TYPE DOWN LIGHTER
5.		COMMERCIAL PENDENT ROUND LIGHT
6.		50MM WIDE RECESSED PROFILE LIGHT
7.		COMMERCIAL TYPE CEILING SUSPENDED LINEAR LIGHT
8.		LED STRIP LIGHT FOR COVE LIGHTING 15 WATT
9.		20 WATT LED T8 TUBE LIGHT
10.		6A ONE WAY S/B

DRG. NO.	SCALE
VSPL/SBI/CB/01	N.T.S.
DEALT BY :	CHKD. BY :
JYOTI BACHETI	NEELAM SHARMA

NOTE :-
THIS DRAWING IS PROPERTY OF M/s VASTU SADAN PVT. LTD. & NOT TO BE COPIED OR HANDED OVER TO A PARTY OR USED FOR THE PURPOSE OTHER THAN FOR WHICH IT HAS BEEN ISSUED.

DRG. TITLE	DATE R-06
LAYOUT PLAN 9TH FLOOR	27/04/2026

ARCHITECTS
VASTU SADAN PVT. LTD.
122A/12, Gautam Nagar, New Delhi - 110049.
PHONE : 41643426, 41643626 FAX : 91-11-41643426
Email:-vspvtltd@gmail.com, vastusadan@yahoo.co.in



PROPOSED INTERIOR WORK for STATE BANK OF INDIA COMMERCIAL BRANCH, AT GURUGRAM


DGM (BRANCH)

AGM (CIVIL)

AGM (ELECT)

ARCHITECT

OWNER

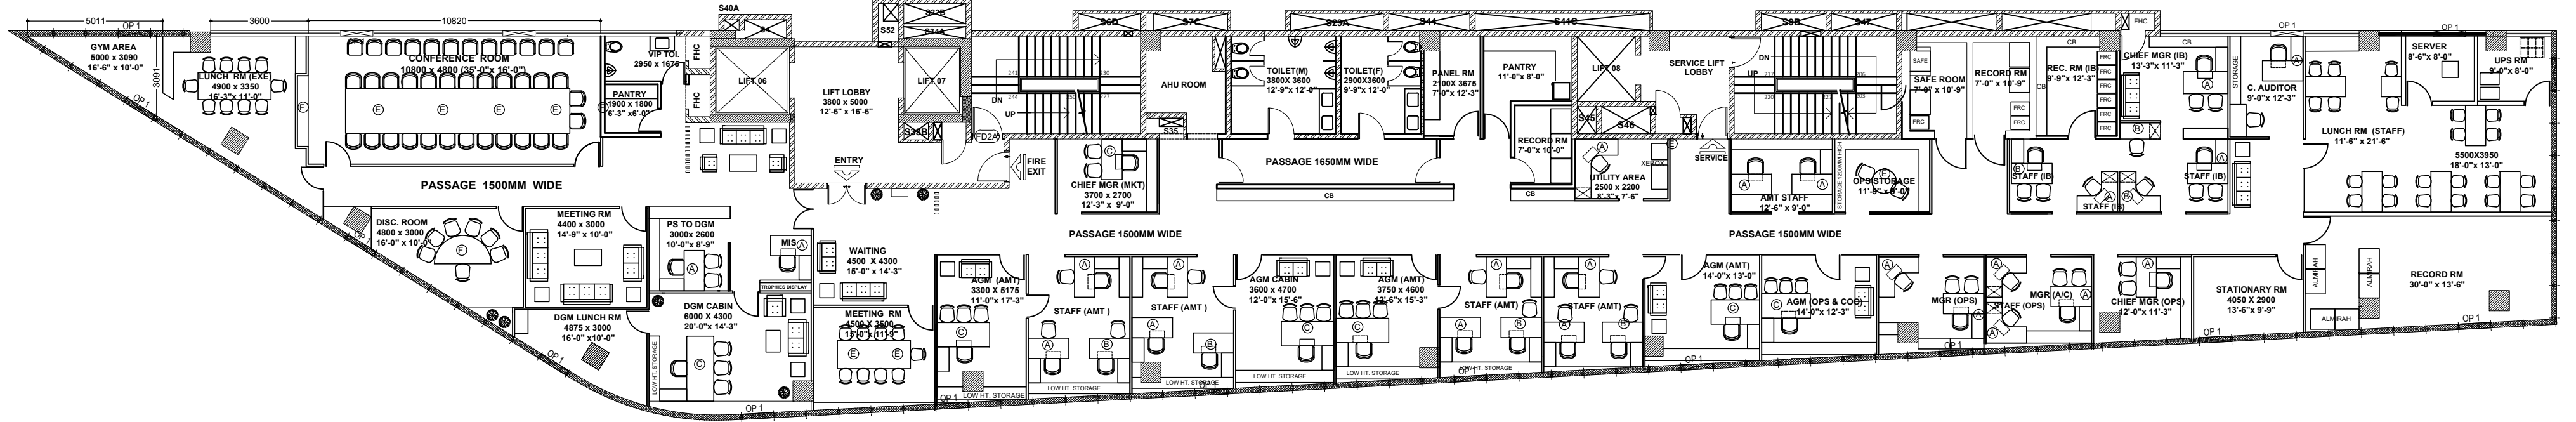

LEGENDS

(A)	
(B)	
(C)	
(D)	
(E)	
(F)	
	UPS PT-3 6A SOCKET & SWITCH
	DATA PT.
	6 AMP. SOCKET & SWITCH
	16A 6 PIN POWER PLUG
	CALL BELL
	TELEPHONE OUTLET
	HDMI PORT
	C/C TYPE PORT
	WALL FAN
	EXHAUST FAN

DRG. NO.	SCALE
VSPL/SBI/CB/02	N.T.S.

DEALT BY :	CHKD. BY :
JYOTI BACHETI	NEELAM SHARMA

NOTE :-
THIS DRAWING IS PROPERTY OF M/s VASTU SADAN PVT. LTD. & NOT TO BE COPIED OR HANDED OVER TO A PARTY OR USED FOR THE PURPOSE OTHER THAN FOR WHICH IT HAS BEEN ISSUED.

DRG. TITLE	DATE :
ELECT LAYOUT PLAN 9TH FLOOR	27/04/2026

ARCHITECTS
VASTU SADAN PVT. LTD.
122A/12, Gautam Nagar, New Delhi - 110049.
PHONE : 41643426, 41643626 FAX : 91-11-41643426
Email:-vspvlttd@gmail.com, vastusadan@yahoo.co.in



PROPOSED INTERIOR WORK for STATE BANK OF INDIA COMMERCIAL BRANCH, AT GURUGRAM

DGM (BRANCH)

AGM (CIVIL)

AGM (ELECT)

ARCHITECT

OWNER