


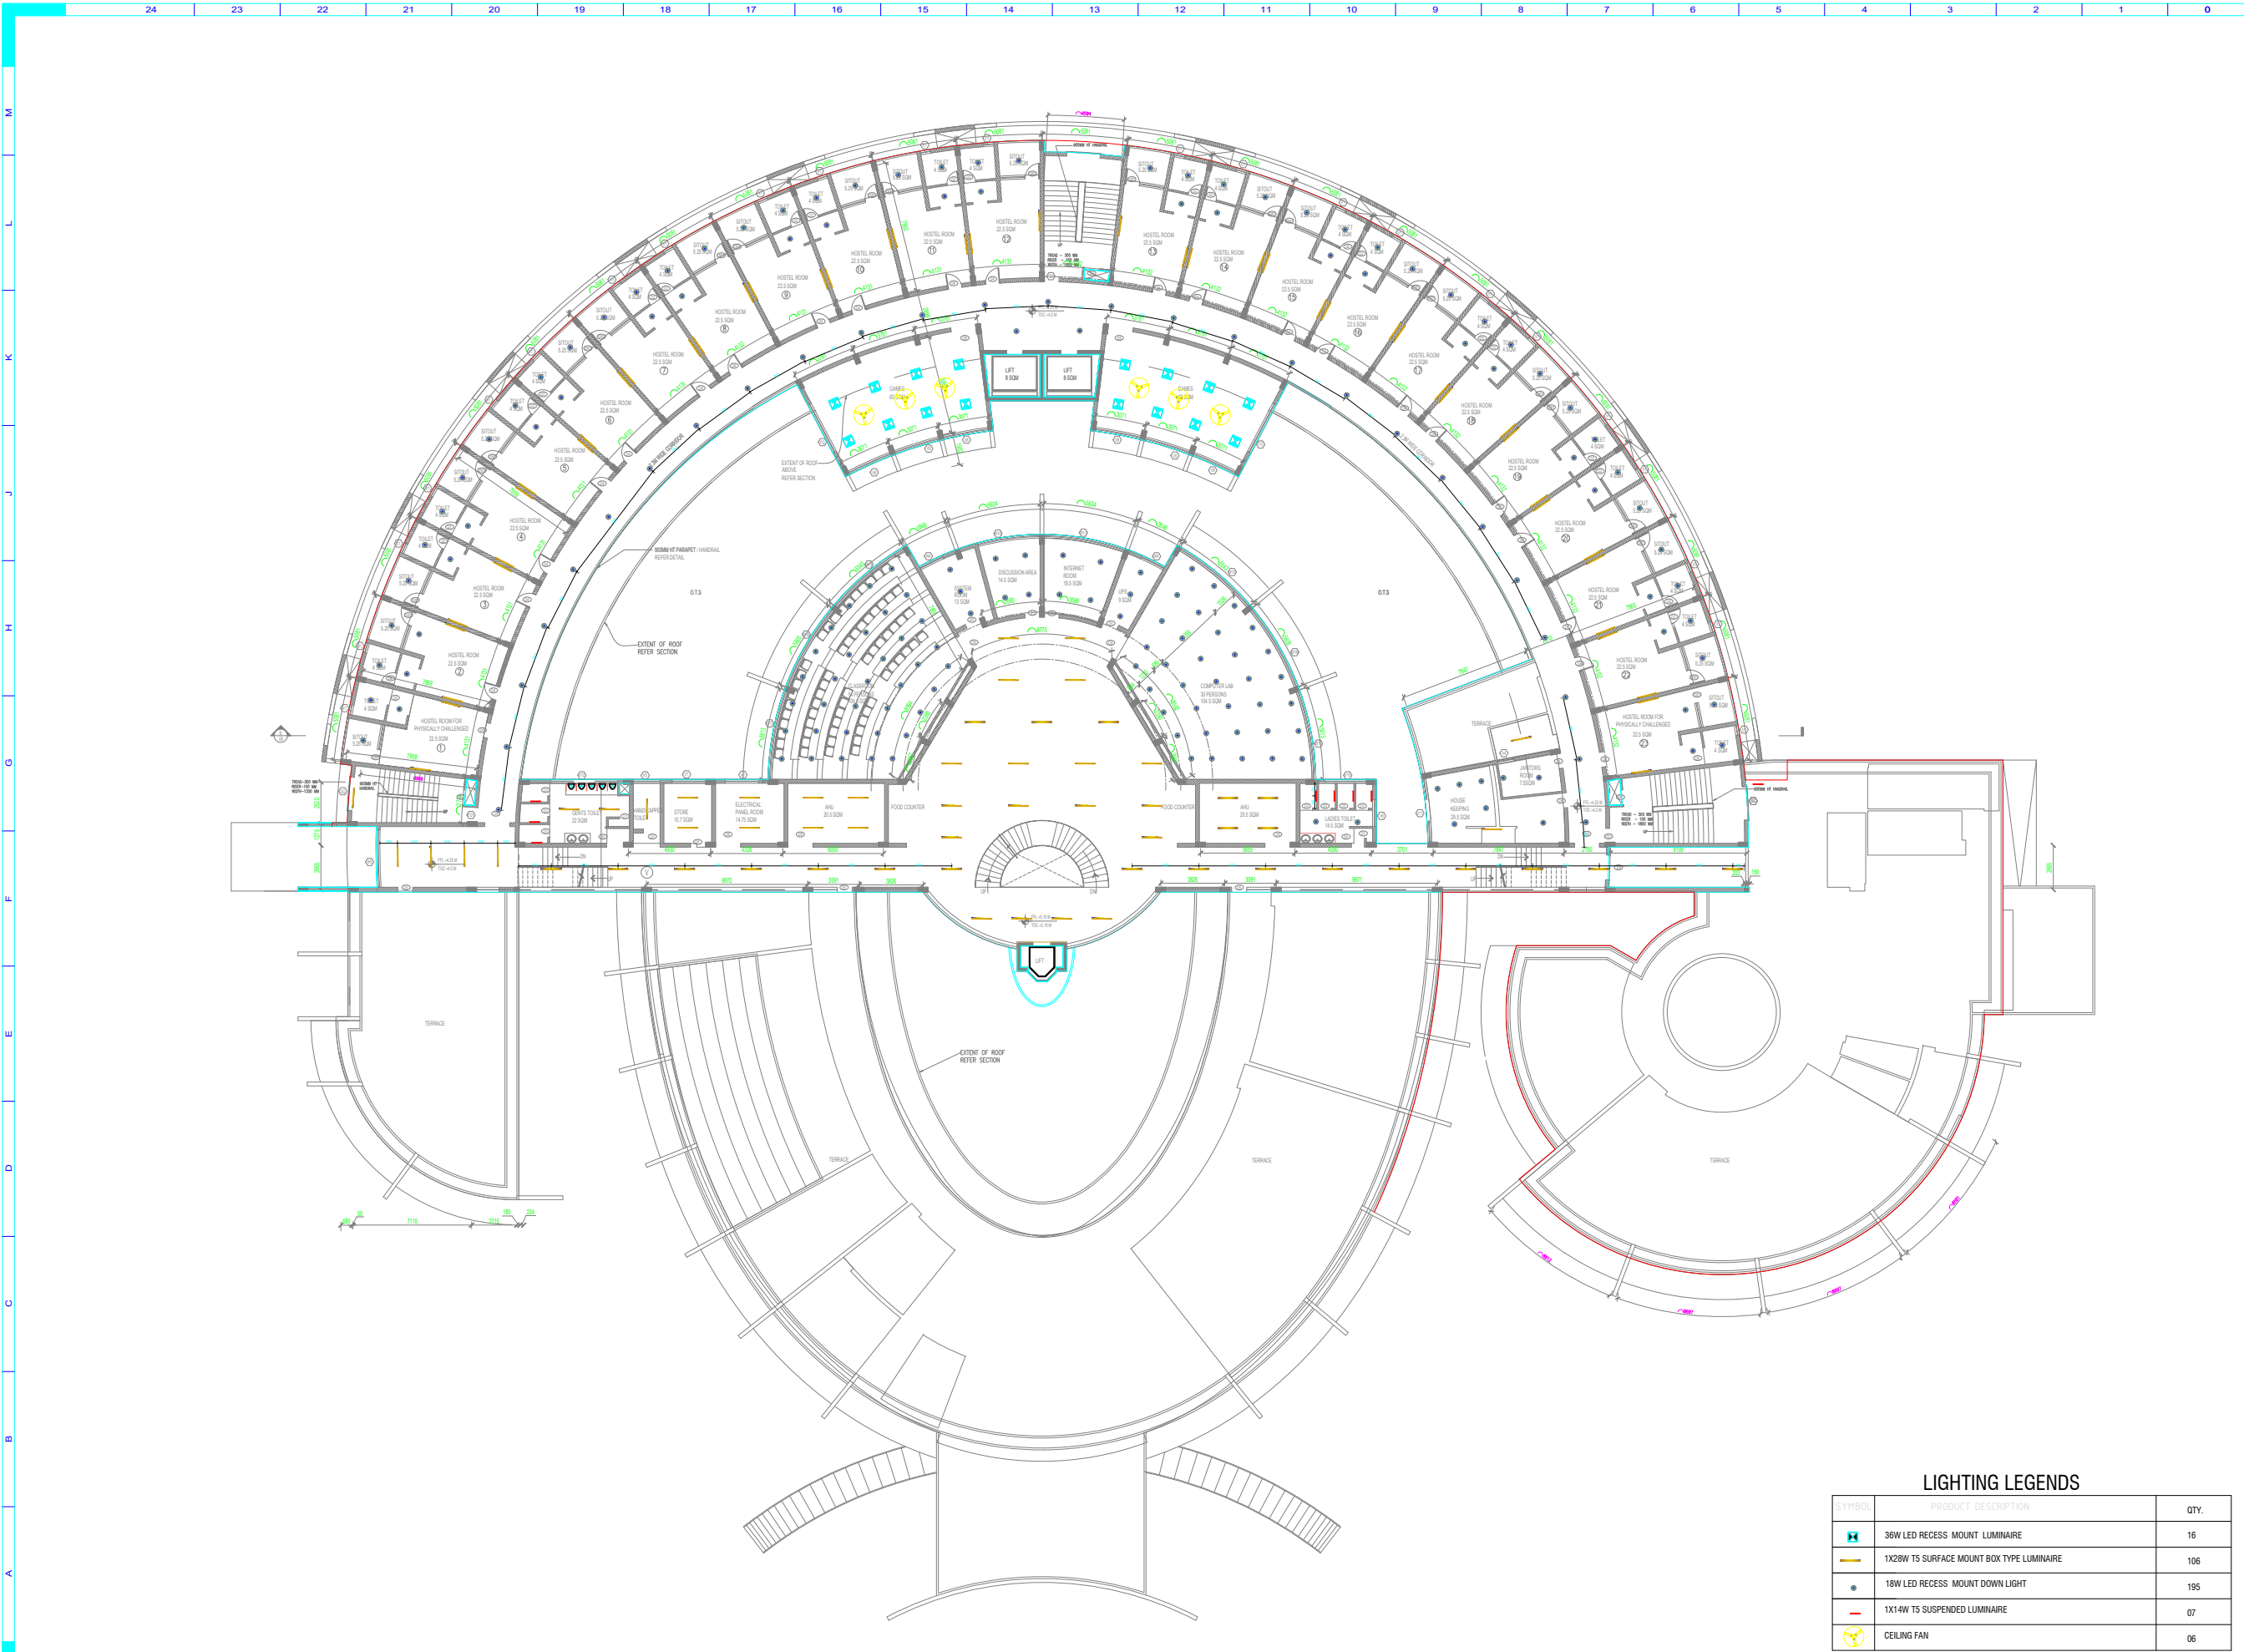

COPYRIGHT
THIS DRAWING IS A COPYRIGHT OF K S RANGANATH ARCHITECTURE AND IT IS NOT TO BE REPRODUCED, COPIED, MANIPULATED, OR
IN ANY MANNER FOR ANY OTHER PURPOSE. OTHER
THAN FOR THE PROJECT INTENDED.

PROJECT TITLE
PROPOSED TECHNICAL INSTITUTE AND
STATIONERY STORES FOR STATE BANK OF INDIA
AT 20/21 COOK ROAD, K.S. NO. 27/2/5,
BLOCK NO. 11, PERAMBUR DIVISION,
PURASAWALKAM - PERAMBUR TALUK, CHENNAI.

DRAWING TITLE
TECHNICAL INSTITUTE
FIRST FLOOR PLAN
APPROVAL DRAWING

SCALE 1:200
DATE 12.02.10
DRAWN BY DEVANAYAKI
CHECKED BY KSR

JOINERY SCHEDULE				
S.NO	DESCRIPTION	SIZE	BILL LEVEL	UNIT
1	IND. MAIN DOOR	1500 X 2100	2100	
2	IND. DOOR	1500 X 2100	2100	
3	IND. DOOR	900 X 2100	2100	
4	IND. DOOR	150 X 2100	2100	
5	IND. DOOR	900 X 2400	2250	
6	IND. WINDOW	2000 X 1500	2100	
7	IND. WINDOW	1500 X 1500	2100	
8	IND. WINDOW	1500 X 2250	2400	
9	IND. WINDOW	800 X 2000	100	
10	IND. WINDOW	2750 X 1500	2100	
11	IND. WINDOW	1500 X 1500	2100	
12	IND. VENTILATOR	2000 X 600	1900	
13	IND. VENTILATOR	2000 X 600	1900	
14	IND. VENTILATOR	1750 X 600	2100	
15	IND. VENTILATOR	1500 X 600	1900	
16	IND. VENTILATOR	1200 X 600	1900	

FOR TENDERING ONLY

LIGHTING LAYOUT - FIRST FLOOR
**MIS JS CONSULTANT**
ELECTRICAL CONSULTANT
NO. 17B SHANTHAN COLONY
ARUNACHAL NAGAR WEST EXTN.
CHENNAI-600101
E-mail: info@misjsconsultant.co.in

PROPOSED
ROAD
SITE BOUNDARY
WATER LINE
SEWER LINE

OWNER'S SIGNATURE

ARCHITECT
**K S RANGANATH**
K S RANGANATH ARCHITECTURE 27,
CHOKKALINGA NAGAR, CHENNAI-600 086
TELEPHONE : 24321250, FAX : 24337280
MOBILE NUMBER : 98410 6888

ARCHITECT'S SIGNATURE

LIGHTING LEGENDS

SYMBOL	PRODUCT DESCRIPTION	QTY.
	36W LED RECESS MOUNT LUMINAIRE	16
	1X28W TS SURFACE MOUNT BOX TYPE LUMINAIRE	106
	18W LED RECESS MOUNT DOWN LIGHT	195
	1X14W TS SUSPENDED LUMINAIRE	07
	CEILING FAN	06