


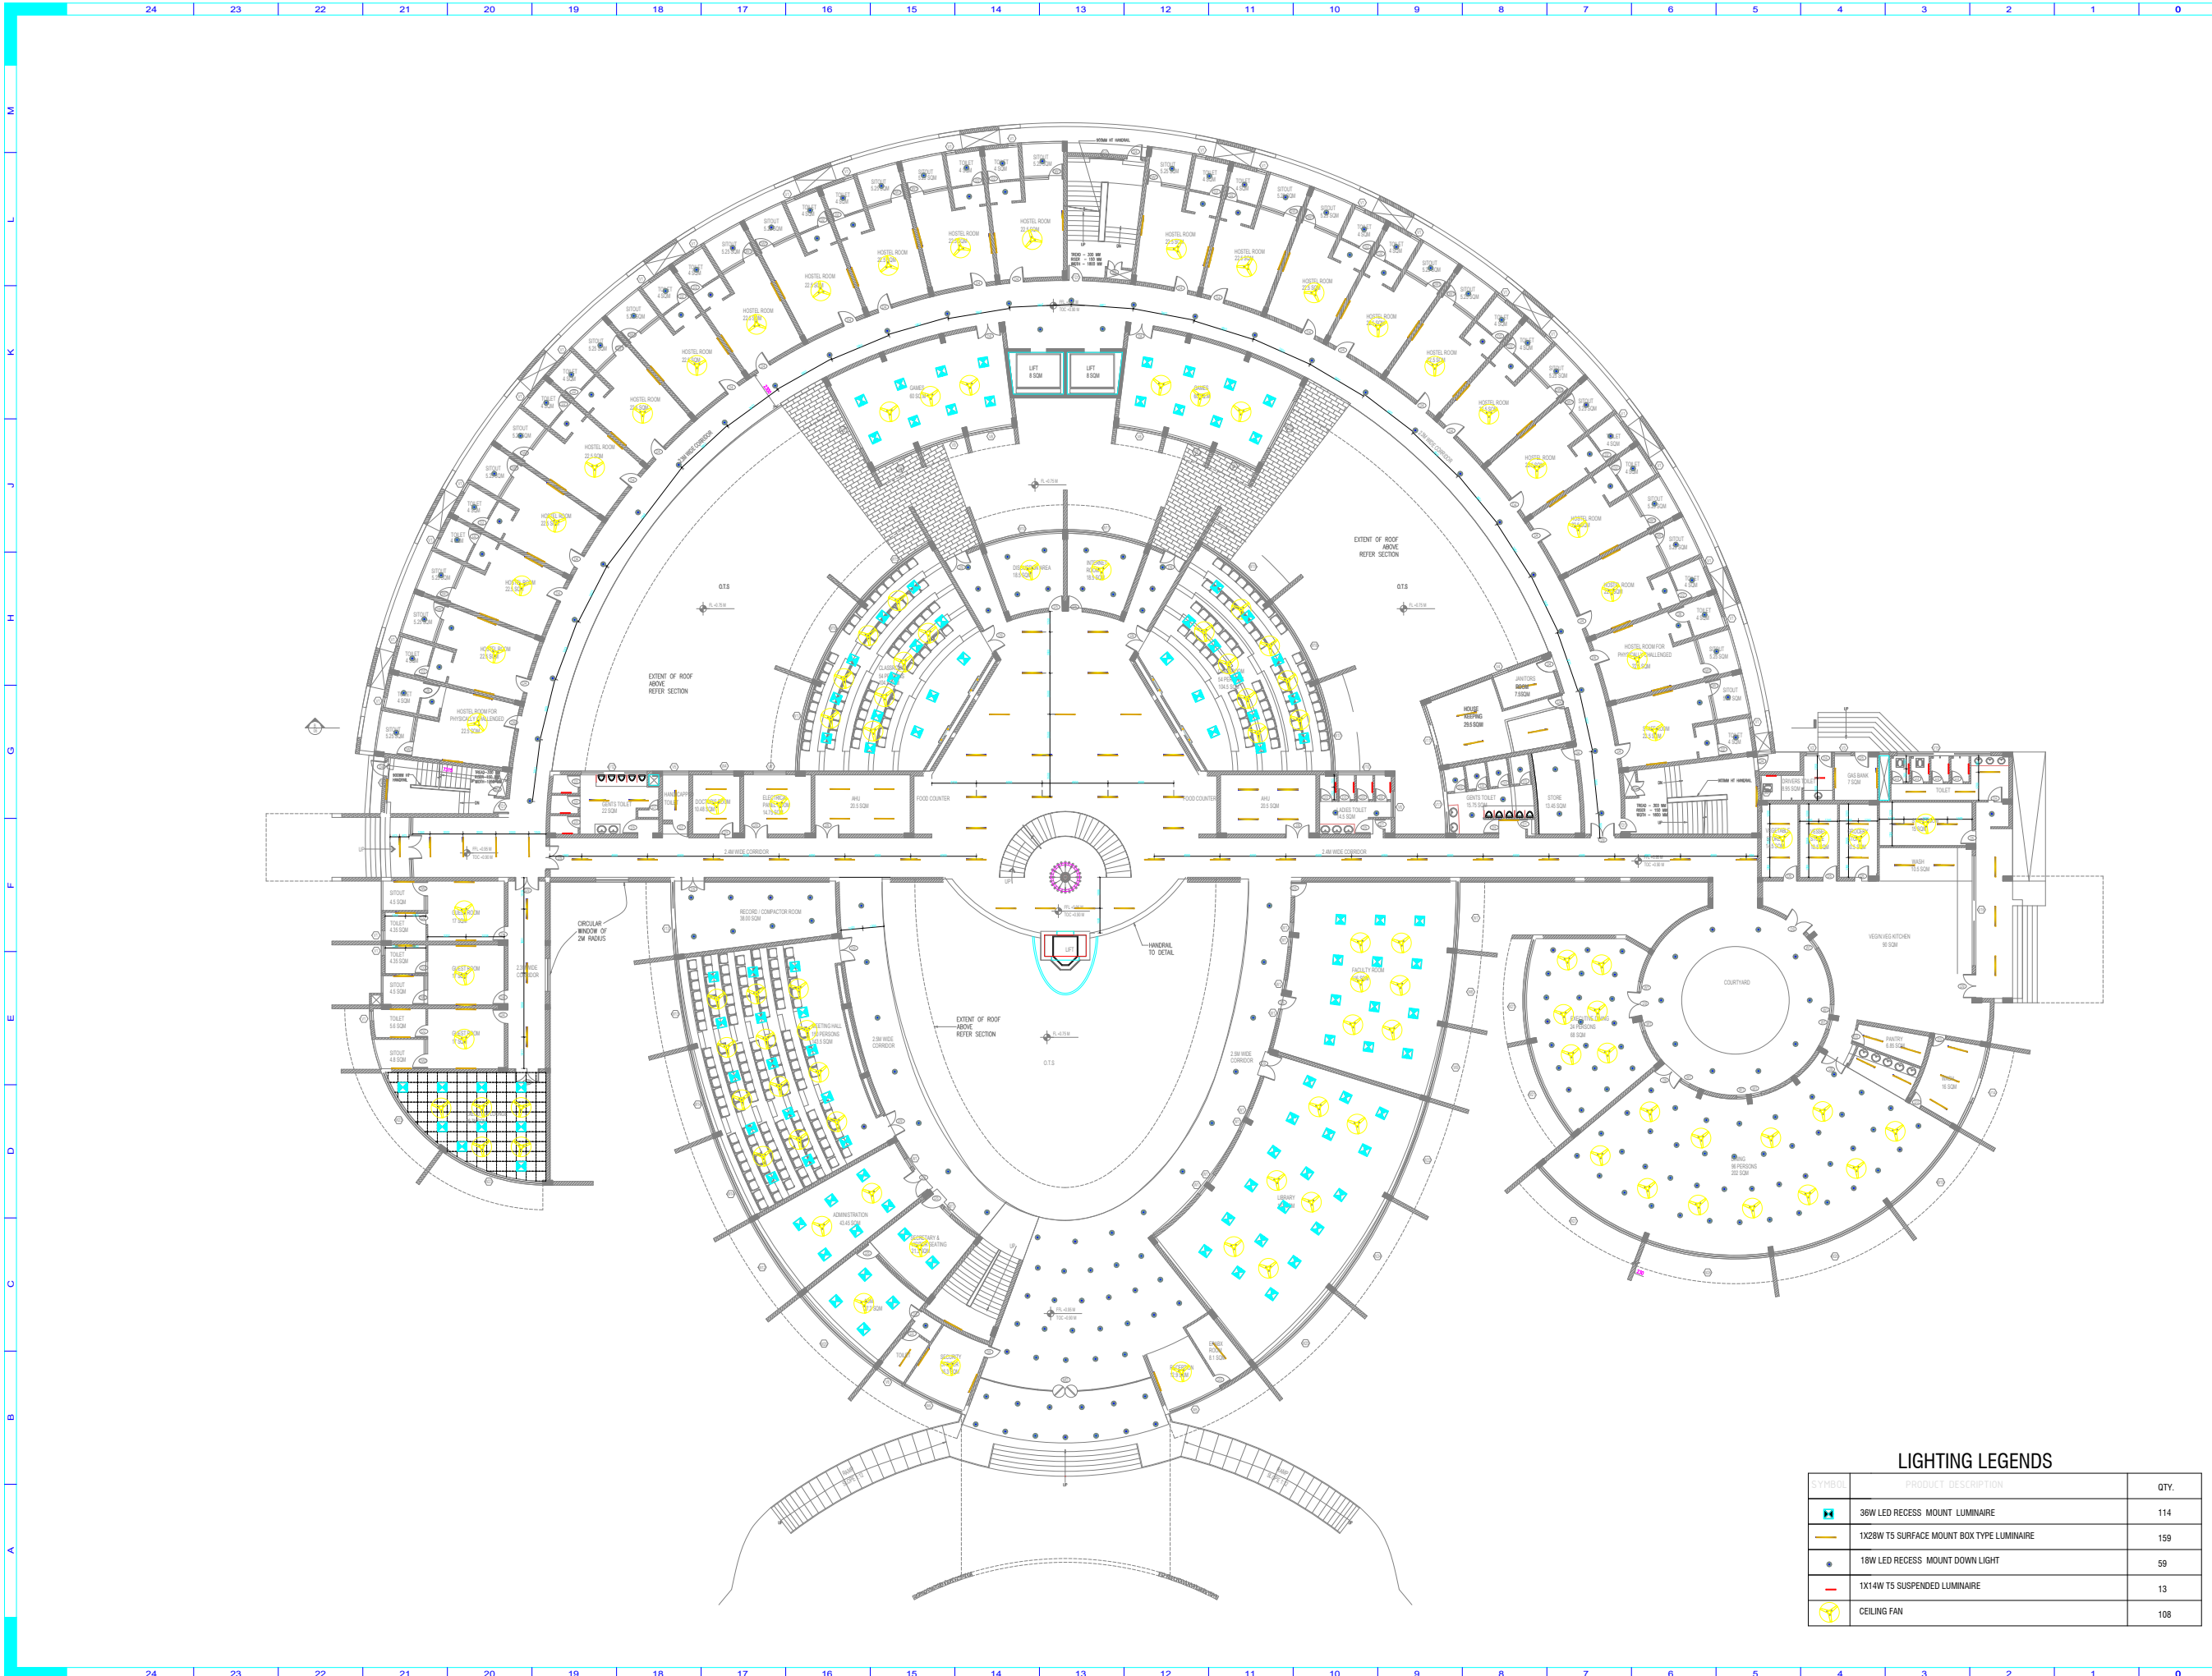

COPYRIGHT
THIS DRAWING IS A COPYRIGHT OF K S RANGANATH ARCHITECTURE
AND IT IS NOT TO BE REPRODUCED OR COPIED IN ANY FORM OR BY ANY MEANS
WITHOUT THE WRITTEN PERMISSION OF K S RANGANATH ARCHITECTURE

PROJECT TITLE
PROPOSED TECHNICAL INSTITUTE AND
STATIONARY STORES FOR STATE BANK OF INDIA
AT 20 & 21 COOCH ROAD, K.S. NO. 27205,
BLOCK NO. 17, PERAMBUR DIVISION,
PURSAGALAYAM - PERAMBUR TALUK, CHENNAI

DRAWING TITLE
TECHNICAL INSTITUTE
FIRST FLOOR PLAN
(APPROVAL DRAWING)

SCALE: 1:200
DATE: 12.02.10
DRAWN BY: DEVANAYAGI
CHECKED BY: KSR

JOINERY SCHEDULE				
S.NO	NOT	DESCRIPTION	SIZE	UNIT
1	MD	MAIN DOOR	1500 X 2100	2100
2	SD	DOOR	1500 X 2100	2100
3	SD	DOOR	800 X 2100	2100
4	SD	DOOR	750 X 2100	2100
5	SD	DOOR	900 X 2400	2250
6	W	WINDOW	2000 X 1300	800
7	W	WINDOW	1000 X 1300	800
8	W	WINDOW	1000 X 2200	180
9	W	WINDOW	800 X 2000	180
10	W	WINDOW	2750 X 1300	500
11	W	WINDOW	7500 X 1500	500
12	V	VENTILATOR	2000 X 600	1500
13	V	VENTILATOR	2000 X 600	1500
14	V	VENTILATOR	1750 X 600	1500
15	V	VENTILATOR	1500 X 600	1500
16	V	VENTILATOR	1200 X 600	1500

FOR TENDERING ONLY

LIGHTING LAYOUT - GROUND FLOOR S&L
**M.S. JS CONSULTANT**
ELECTRICAL CONSULTANT
NO. 17B SHANTHAM COLONY
ANNA NAGAR WEST EAST,
CHENNAI-600101
E-mail: info@msjsconsultant.co.in

PROPOSED
ROAD
SITE BOUNDARY
WATER LINE
SEWER LINE

OWNERS SIGNATURE

ARCHITECT
**K S RANGANATH**
K S RANGANATH ARCHITECTURE 27,
CHOKKALINGA NAGAR, CHENNAI-600036
TELEPHONE : 24321550 FAX : 24327280
MOBILE NUMBER : 98410 88808

ARCHITECT'S SIGNATURE

LIGHTING LEGENDS

SYMBOL	PRODUCT DESCRIPTION	QTY.
	36W LED RECESS MOUNT LUMINAIRE	114
	1X28W T5 SURFACE MOUNT BOX TYPE LUMINAIRE	159
	18W LED RECESS MOUNT DOWN LIGHT	59
	1X14W T5 SUSPENDED LUMINAIRE	13
	CEILING FAN	108