


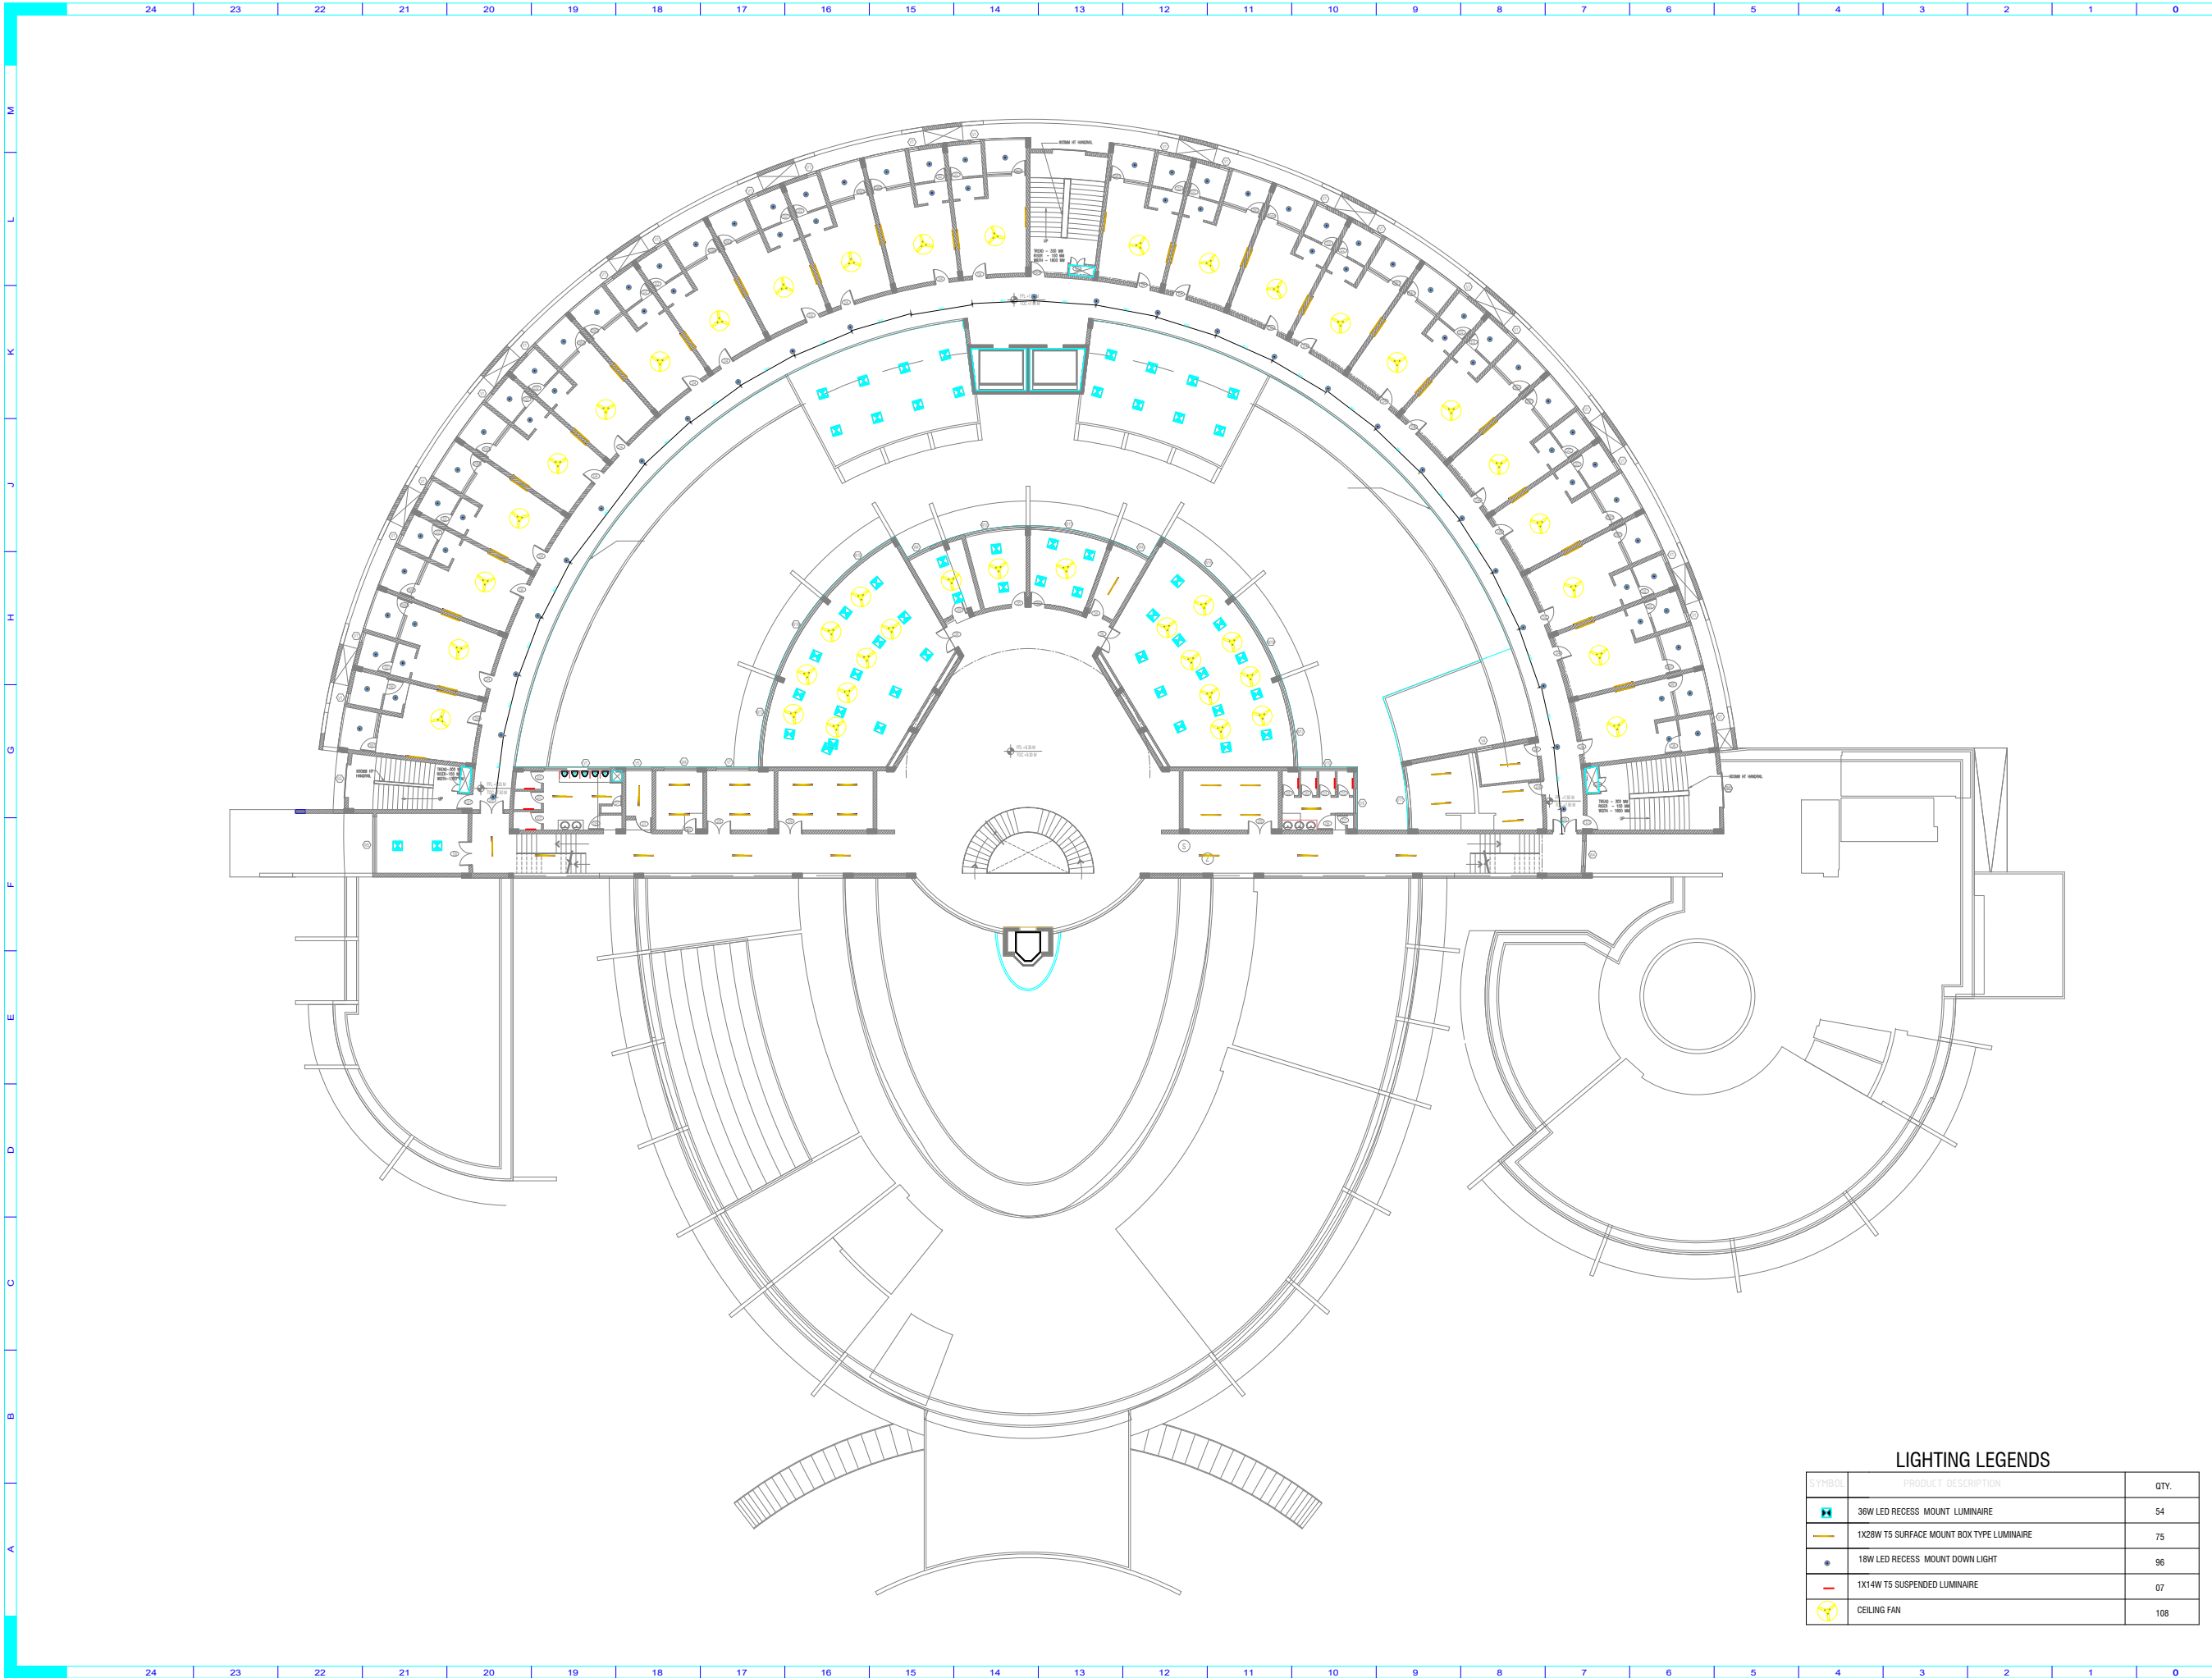

COPYRIGHT
THIS DRAWING IS A COPYRIGHT OF K S RANGANATH ARCHITECTS AND IT IS NOT TO BE REPRODUCED OR TRANSMITTED IN ANY FORM OR BY ANY MEANS, ELECTRONIC OR MECHANICAL, INCLUDING PHOTOCOPYING, RECORDING, OR BY ANY INFORMATION STORAGE AND RETRIEVAL SYSTEM, WITHOUT PERMISSION IN WRITING FROM THE PROJECT MANAGER.

PROJECT TITLE
PROPOSED TECHNICAL INSTITUTE AND
STATIONERY STORES FOR STATE BANK OF INDIA
AT 20 & 21 COOCH ROAD, K.S. NO. 27205,
BLOCK NO 17, PERAMBUR DIVISION,
PURSAGALAYAM - PERAMBUR TALUK, CHENNAI

DRAWING TITLE
TECHNICAL INSTITUTE

APPROVAL DRAWING

SCALE	1:200
DATE	12.02.10
DRAWN BY	DEVANAYAGI
CHECKED BY	KSR

JOINERY SCHEDULE				
S.NO	NOT	DESCRIPTION	SIZE	UNIT
1	MD	MAIN DOOR	1500 X 2100	2100
2	D1	DOOR	1500 X 2100	2100
3	D2	DOOR	800 X 2100	2100
4	D3	DOOR	750 X 2100	2100
5	D4	DOOR	900 X 2400	2250
6	W	WINDOW	2000 X 1300	800
7	W1	WINDOW	1000 X 1300	800
8	W2	WINDOW	1000 X 2200	100
9	W3	WINDOW	880 X 2000	100
10	W4	WINDOW	2750 X 1300	500
11	W5	WINDOW	7500 X 1500	2100
12	V	VENTILATOR	2000 X 600	1500
13	V1	VENTILATOR	2000 X 600	1500
14	V2	VENTILATOR	1750 X 600	1500
15	V3	VENTILATOR	1500 X 600	1500
16	V4	VENTILATOR	1200 X 600	1500

FOR TENDERING ONLY

LIGHTING LAYOUT - SECOND FLOOR SBL

MIS. JS CONSULTANT
ELECTRICAL CONSULTANT
NO. 17B SHANTHAM COLONY
ANNA NAGAR WEST EAST,
CHENNAI-600101
E-mail: info@jsconsultant.co.in

PROPOSED
ROAD
SITE BOUNDARY
WATER LINE
SEWER LINE

OWNERS SIGNATURE

ARCHITECT
KS RANGANATH
K S RANGANATH ARCHITECTURE 27,
CHOKKALINGU NAGAR, CHENNAI-600 086
TELEPHONE : 24321350 FAX : 24337280
MOBILE NUMBER - 98410 88608

ARCHITECT'S SIGNATURE

LIGHTING LEGENDS

SYMBOL	PRODUCT DESCRIPTION	QTY.
	36W LED RECESS MOUNT LUMINAIRE	54
	1X28W T5 SURFACE MOUNT BOX TYPE LUMINAIRE	75
	18W LED RECESS MOUNT DOWN LIGHT	96
	1X14W T5 SUSPENDED LUMINAIRE	07
	CEILING FAN	108